

*Palestine Polytechnic University*  
*civil engineering college*

*Supervisor :*

 
 
 

*Dr: Nasr abboushi*

*Done by :*

*Hamza.haddad*


*Mohammed Abu Lawi*

**EYE  
HOSPITAL  
PROJECT**

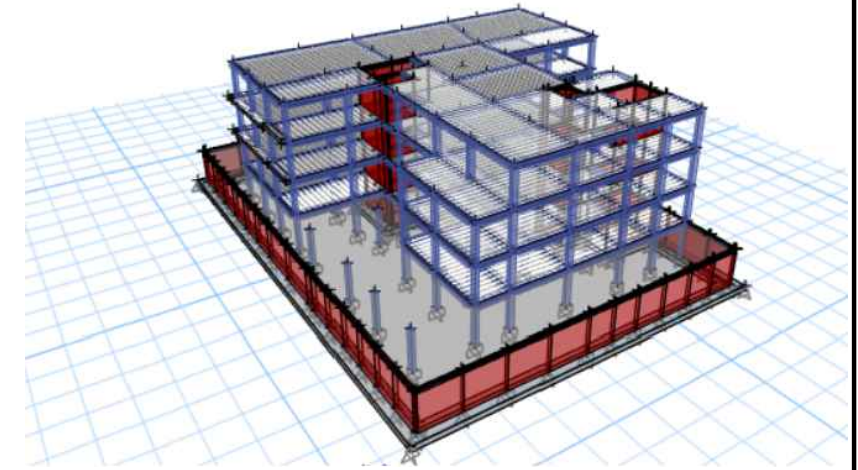

ARCHITECTURAL DRAWINGS			STRUCTURAL DRAWINGS		
DWG.NO.	DRAWING TITTLE	SCALE	DWG.NO.	DRAWING TITTLE	SCALE
DWG.NO.	COVER SHEET	N .T .S.	S 00	Columns Layout plan	1/100
A 01	SITE PLAN DIMENSION	1/200	S 01	Footings Layout plan	1/100
A 02	SITE PLAN	1/100	S 02-7	Footings Detailing	1/25
A 03	MASTER PLAN	1/100	S 8	Columns Groups	1/50
A 04	Basement Floor Dimension plan	1/100	S 9	Columns Detailing	1/50
A 05	Ground Floor Dimension plan	1/100	S 10-13	SLAB Plans	1/100
A 06	First Floor Dimension plan	1/100	S 14-17	SLAB Detailing	1/100
A 07	Secound Floor Dimension plan	1/100	S 18-48	Beams Detailing	1/50
A 08	Basement Floor Furniture plan	1/100	S 49	Shear Walls Key Plan	1/50
A 09	Ground Floor Furniture plan	1/100	S 50-53	Shear Walls Detailing	1/50
A 10	First Floor Furniture plan	1/100	S 54-55	Stairs Detailings	1/25
A 11	Secound Floor Furniture plan	1/100			
A 12	EAST-ELEVATION	1/100			
A 13	SOUTH-ELEVATION	1/100			
A 14	NOYRTH-ELEVATION	1/100			
A 15	WEST-ELEVATION	1/100			
A 16	SECTION A-A	1/100			
A 17	SECTION B-B	1/100			



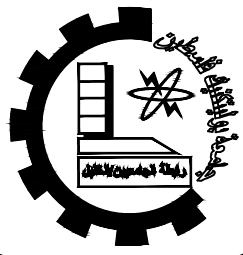

Palestine Polytechnic  
University  
Department of Civil  
Engineering  
College of Engineering  
Civil Engineering

Design V  
Project I

Eye-specialist Hospital

supervisors:

Dr. Nasr Abboushi  
Design by Roa' Al-jondi  
Hamza.haddad  
Mohammad abu lawi

Drawing Sympol



Arch02

Drawing Tittle


Site plan

scale

 1:200

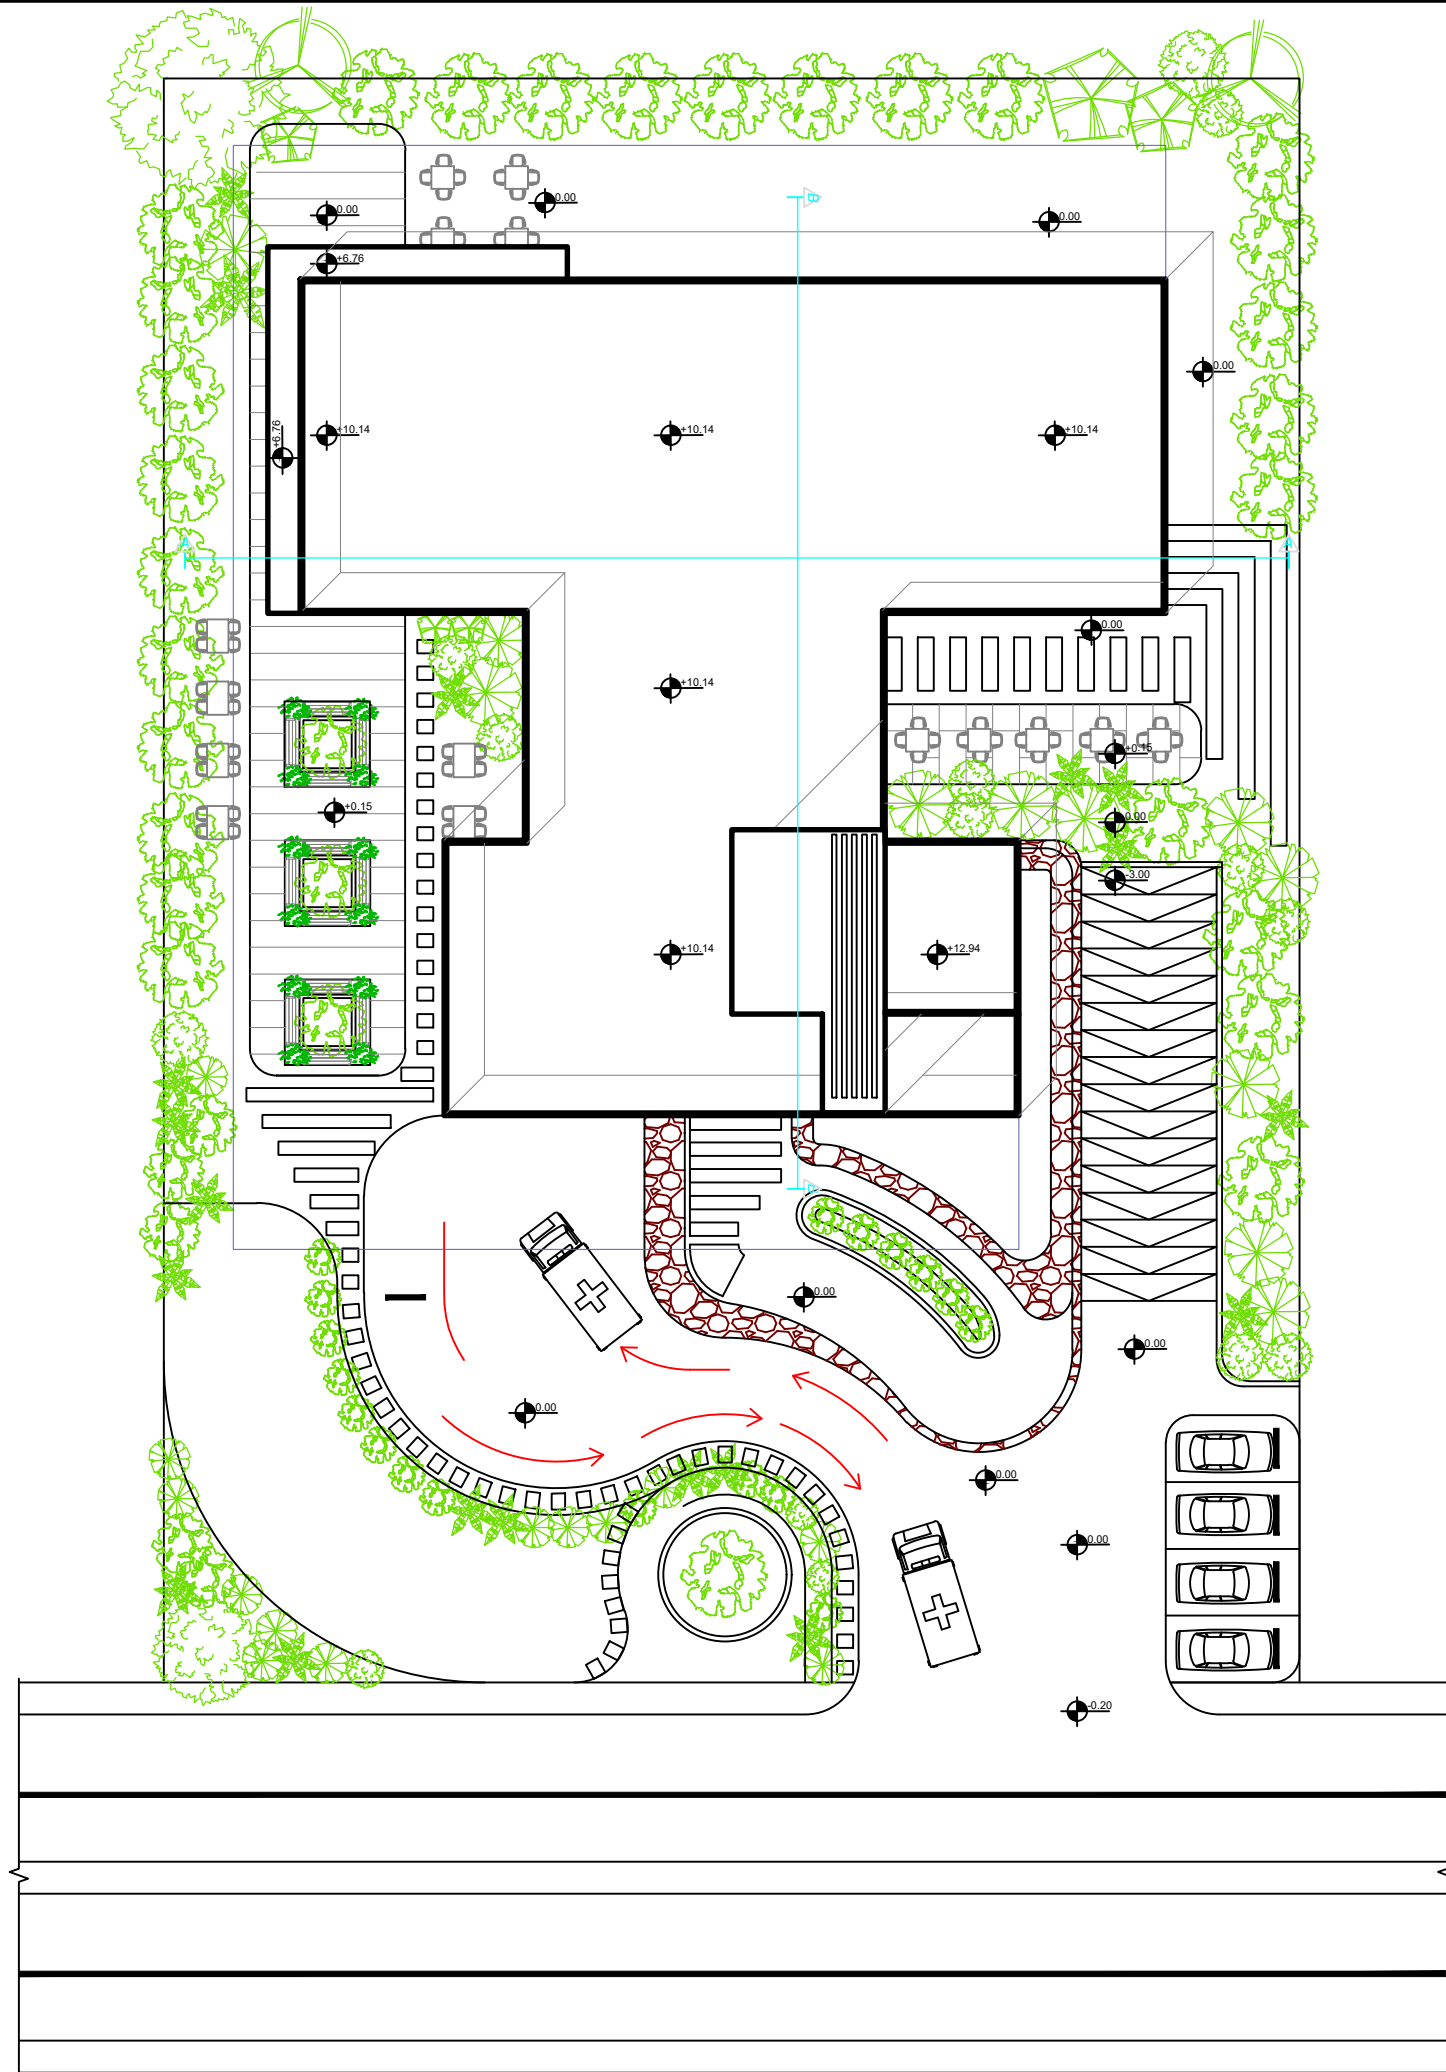



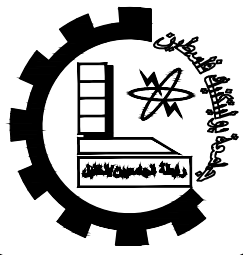

Palestine Polytechnic  
University  
Department of Civil  
Engineering  
College of Engineering  
Civil Engineering

Design V  
Project I

Eye-specialist Hospital

supervisors:

Dr. Nasr Abboushi  
Design by Roa' Al-jondi  
Hamza.haddad  
Mohammad abu lawi

Drawing Symbol



Arch03

Drawing Tittle

Master Plan

scale

 1:200

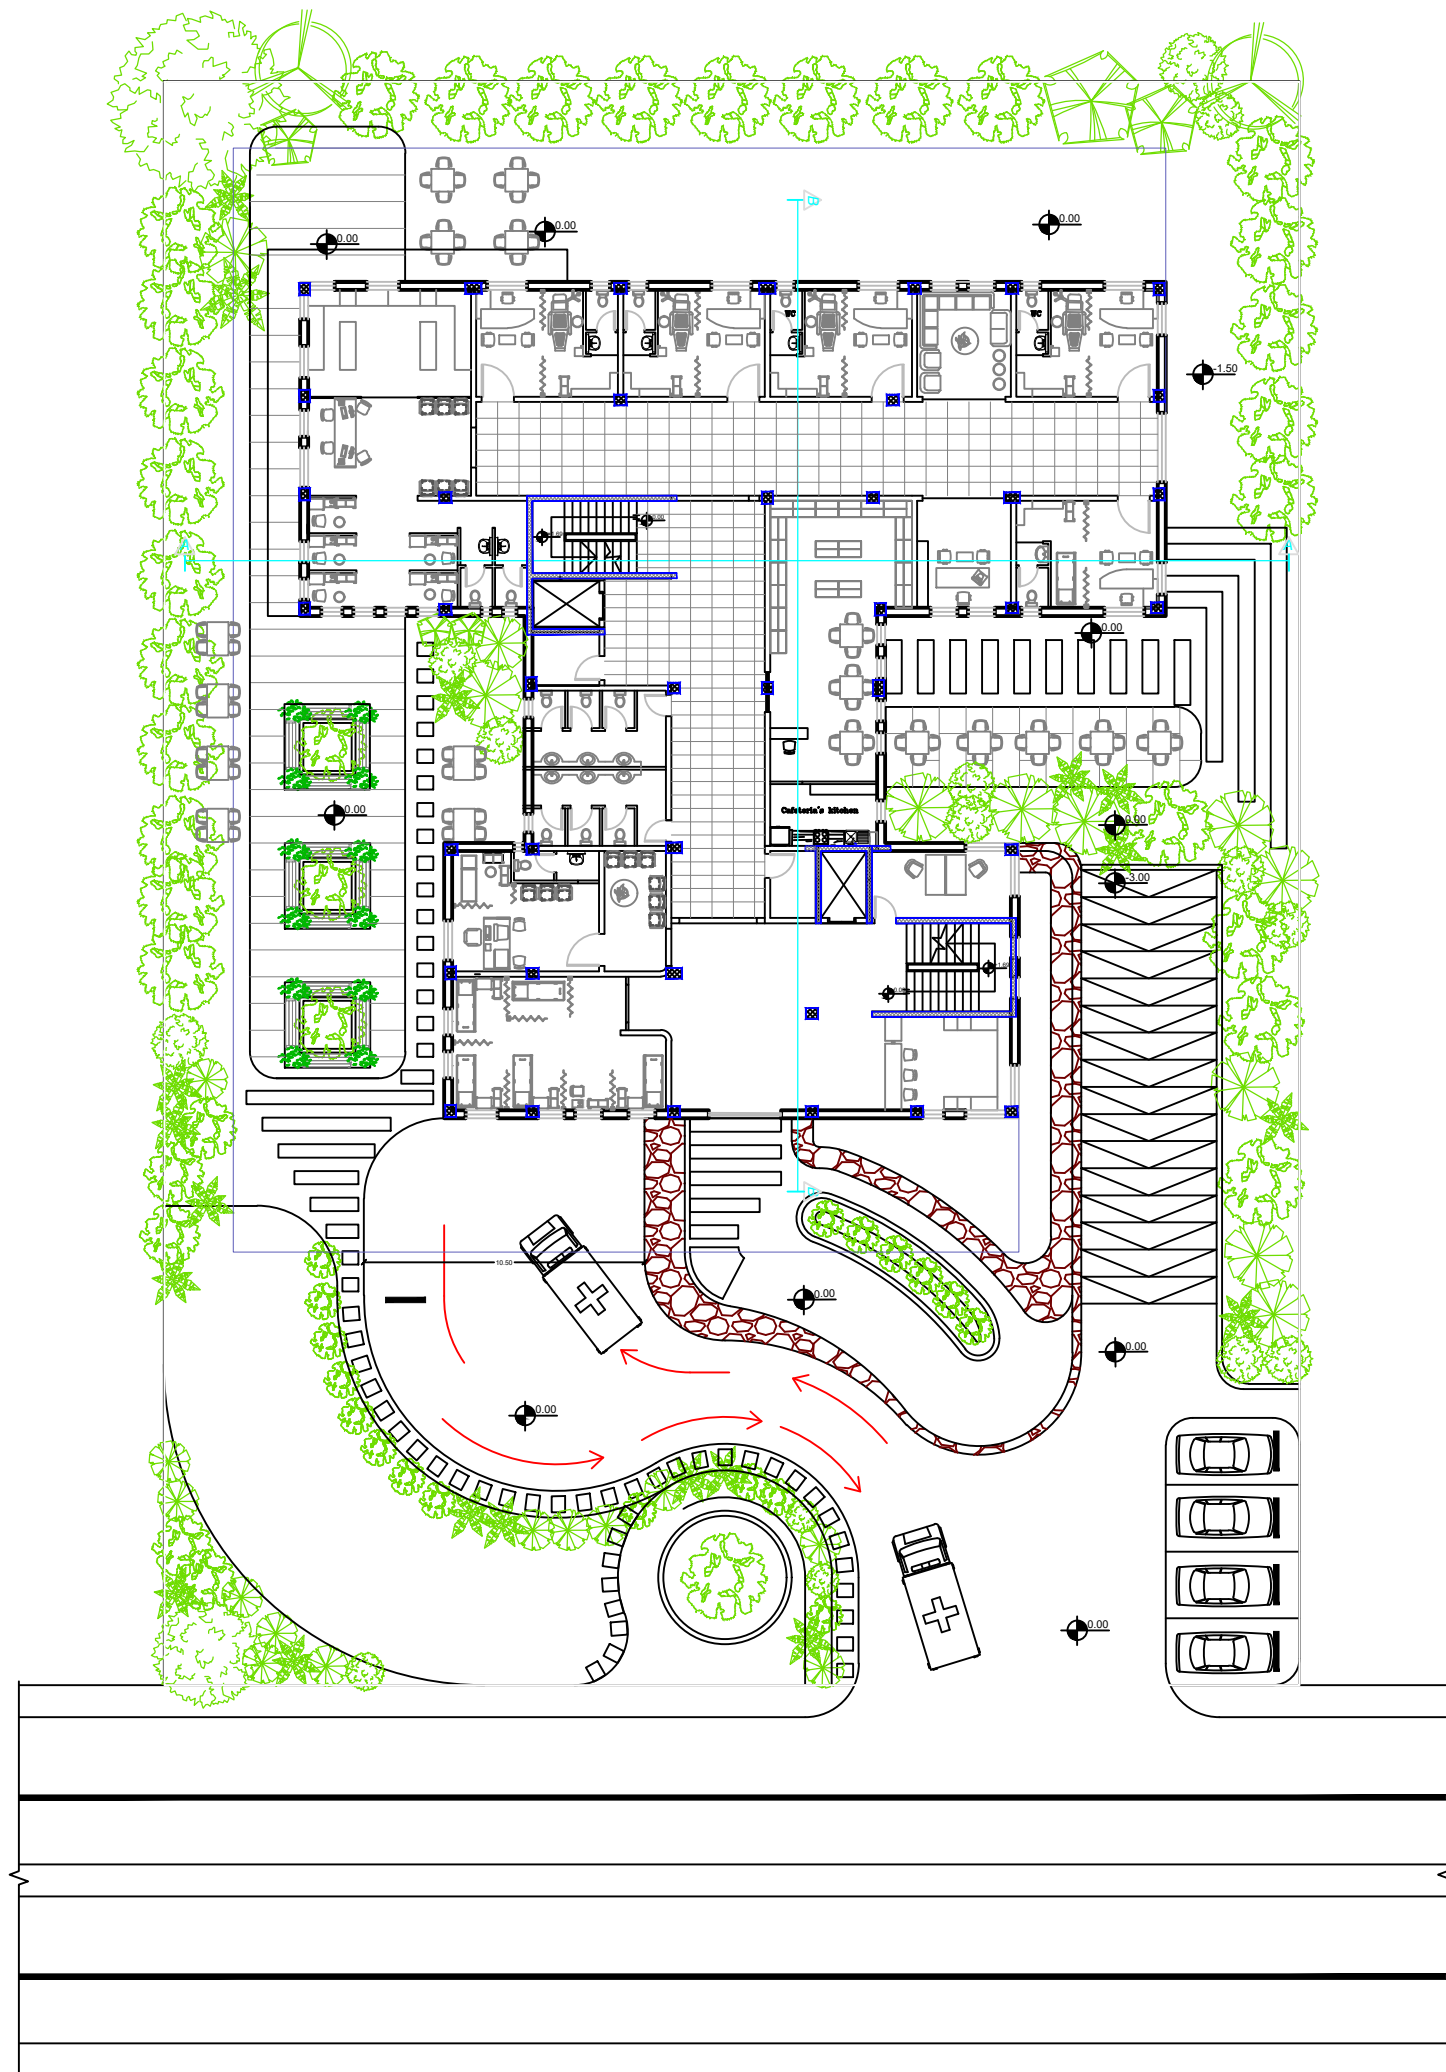



Palestine Polytechnic University

Department of Civil Engineering

College of Engineering

Civil Engineering

Design V

Project I

Eye-specialist Hospital

supervisors:

Dr. Nasr Abboushi  
Design by Roa' Al-jondi

Hamza.haddad  
Mohammad abu lawi

Drawing Symbol


Arch04


Drawing Tittle

Basement Floor Plan  
-Dimension

scale

1:100

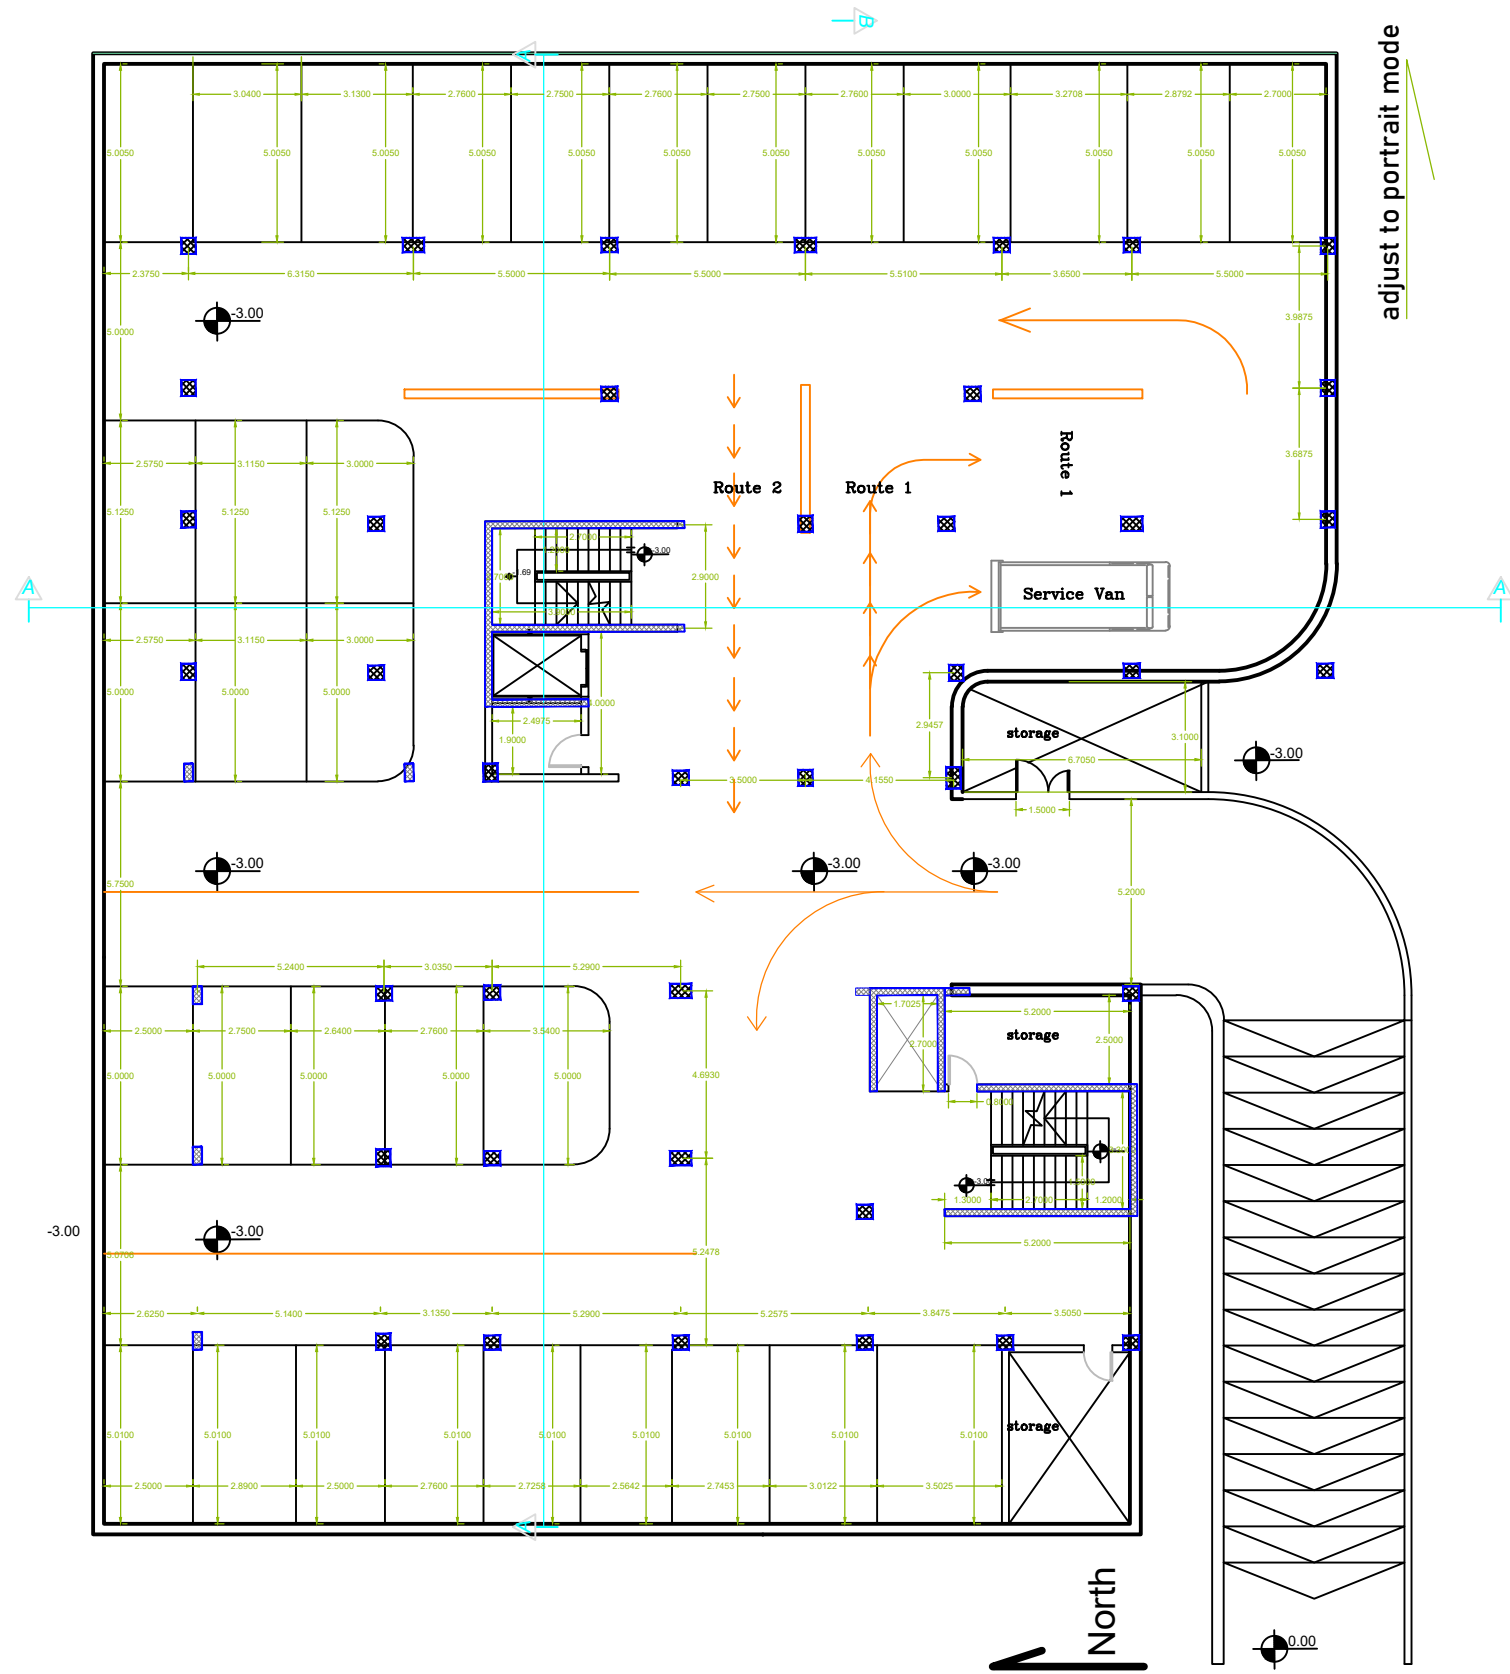

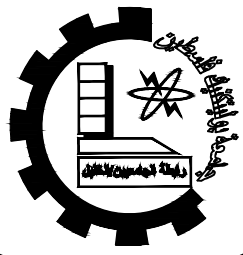

Palestine Polytechnic University

Department of Civil Engineering

College of Engineering

Civil Engineering

Design V

Project I

Eye-specialist Hospital

supervisors:

Dr. Nasr Abboushi  
Design by Roa' Al-jondi

Hamza.haddad  
Mohammad abu lawi

Drawing Symbol


Arch05


Drawing Tittle

Ground Floor Plan  
-Dimension

scale

1:100

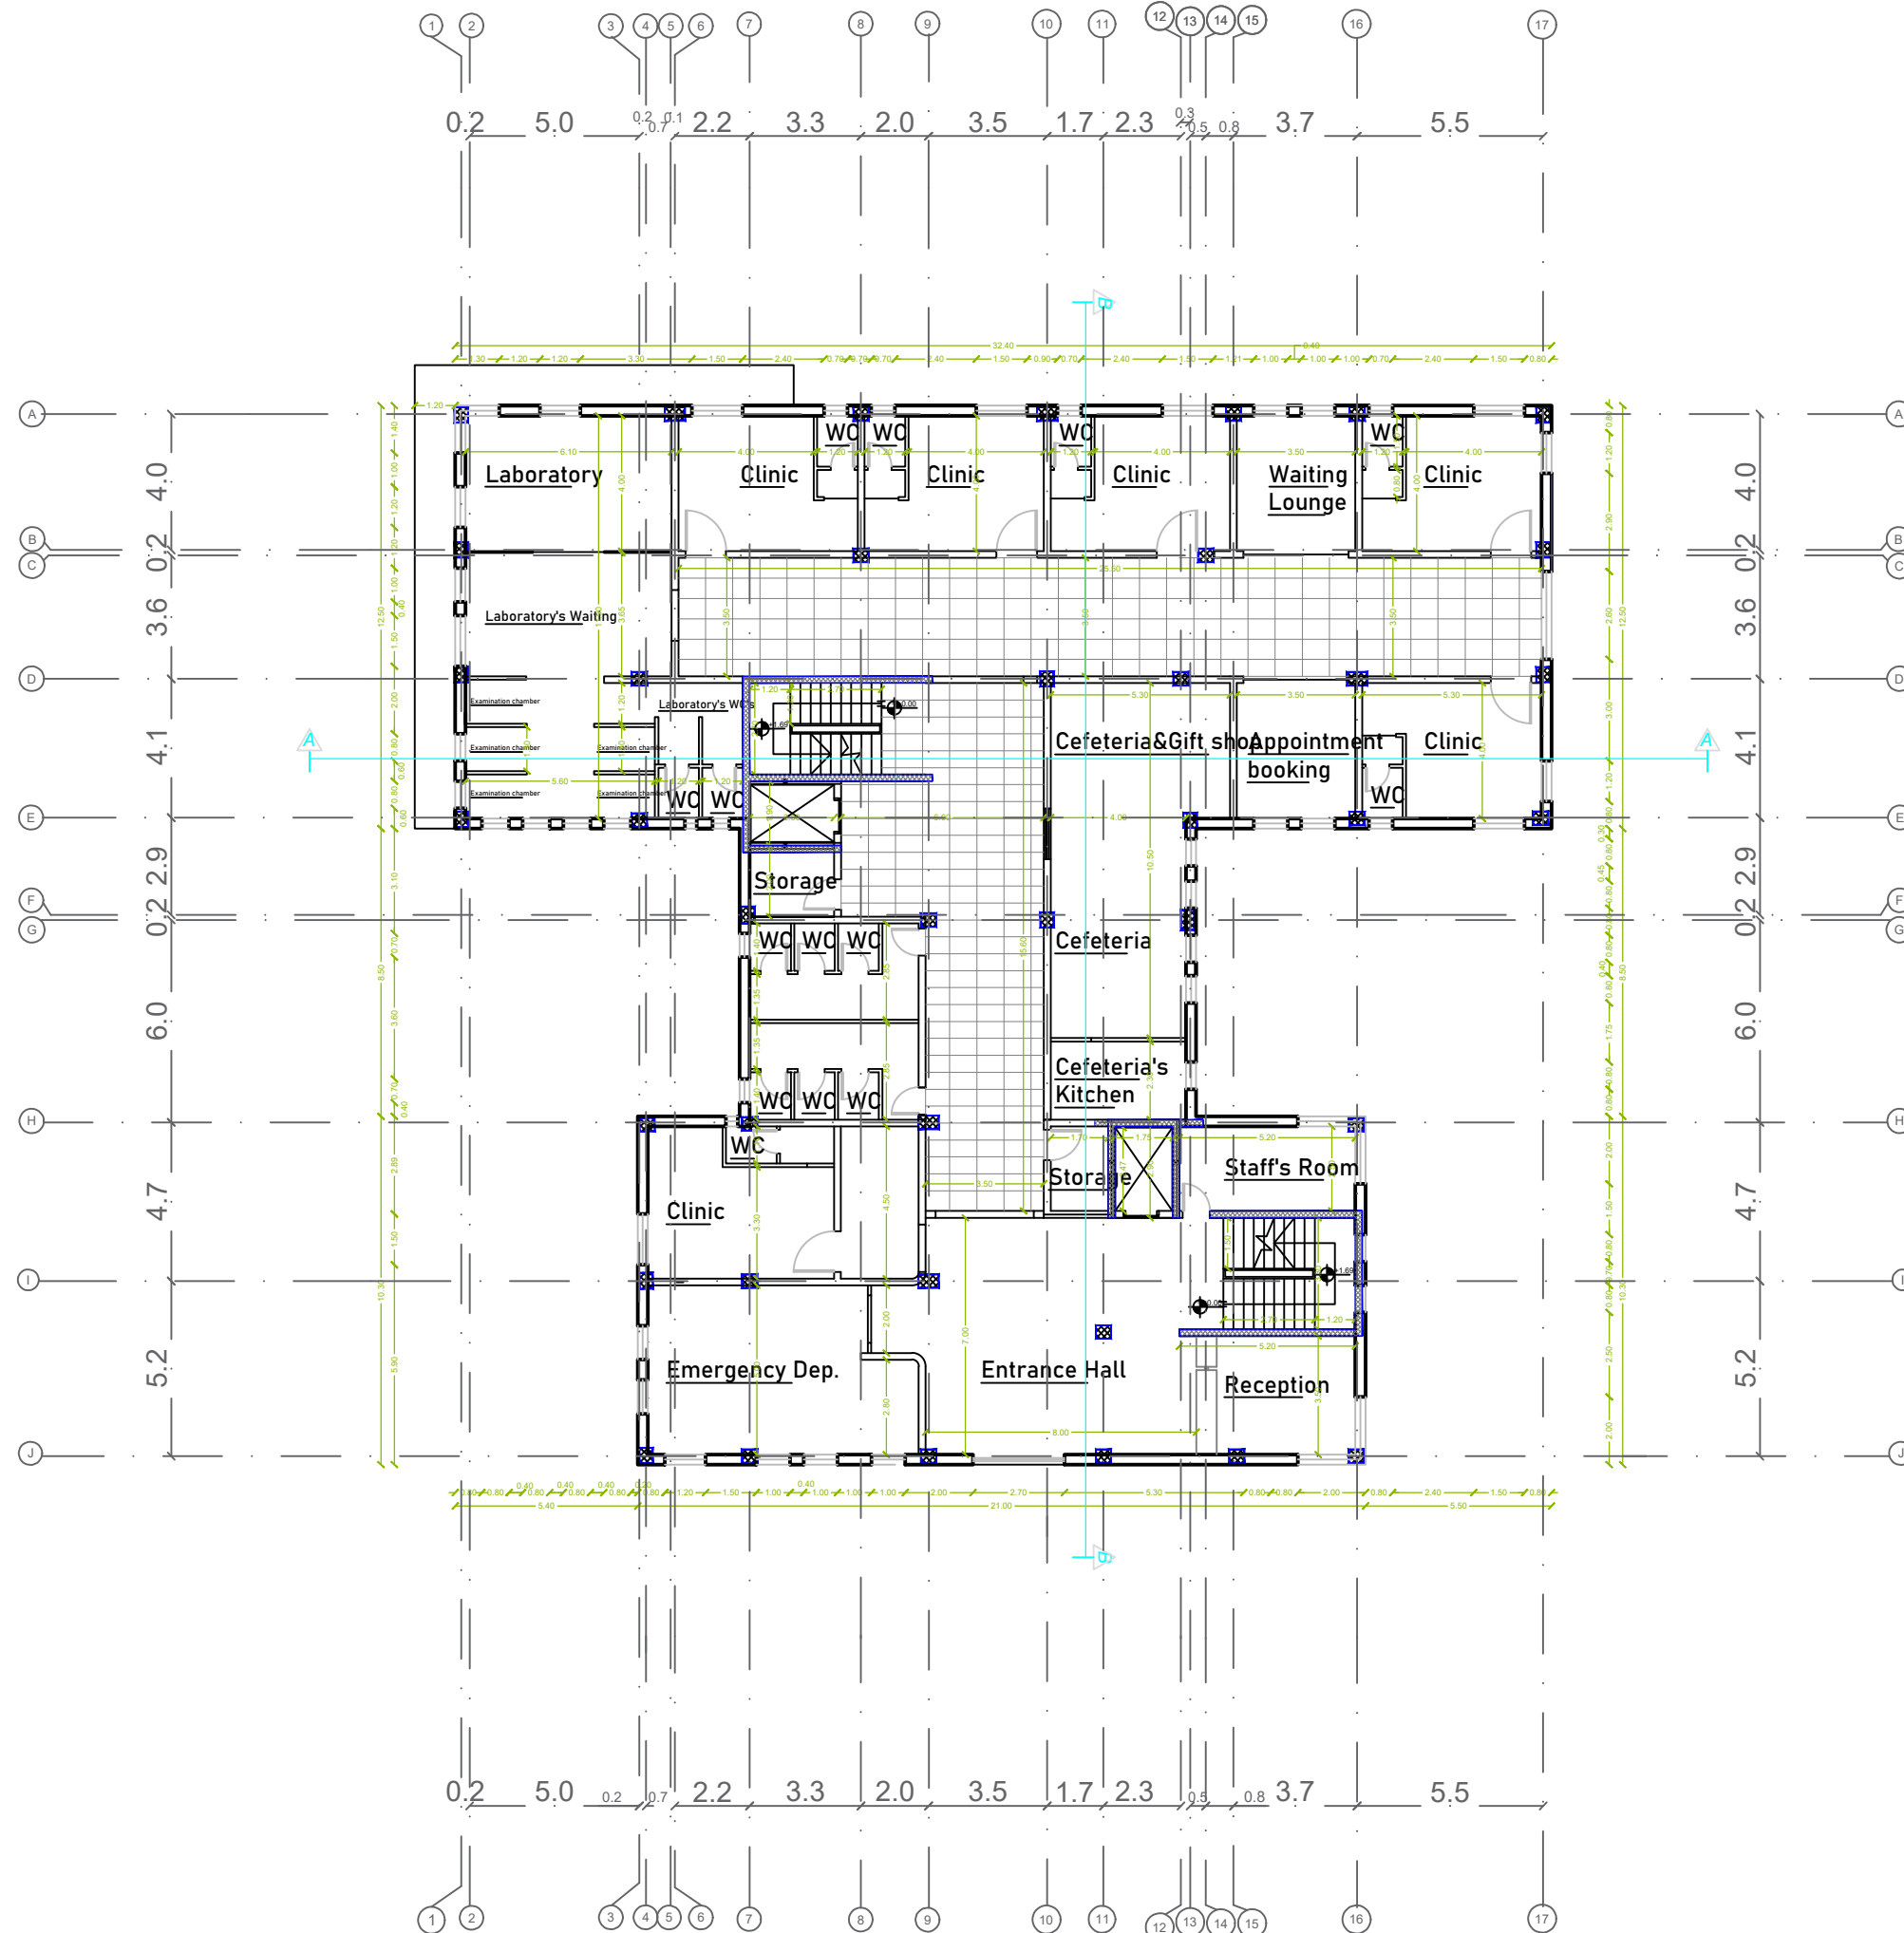

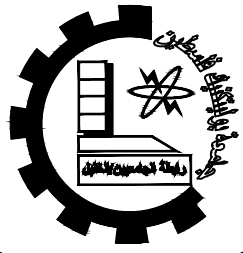

Palestine Polytechnic University

Department of Civil Engineering

College of Engineering

Civil Engineering

Design V

Project I

Eye-specialist Hospital

supervisors:

Dr. Nasr Abboushi  
Design by Roa' Al-jondi

Hamza.haddad  
Mohammad abu lawi

Drawing Symbol


Arch06

Drawing Tittle


First Floor Plan  
-Dimension

scale

1:100

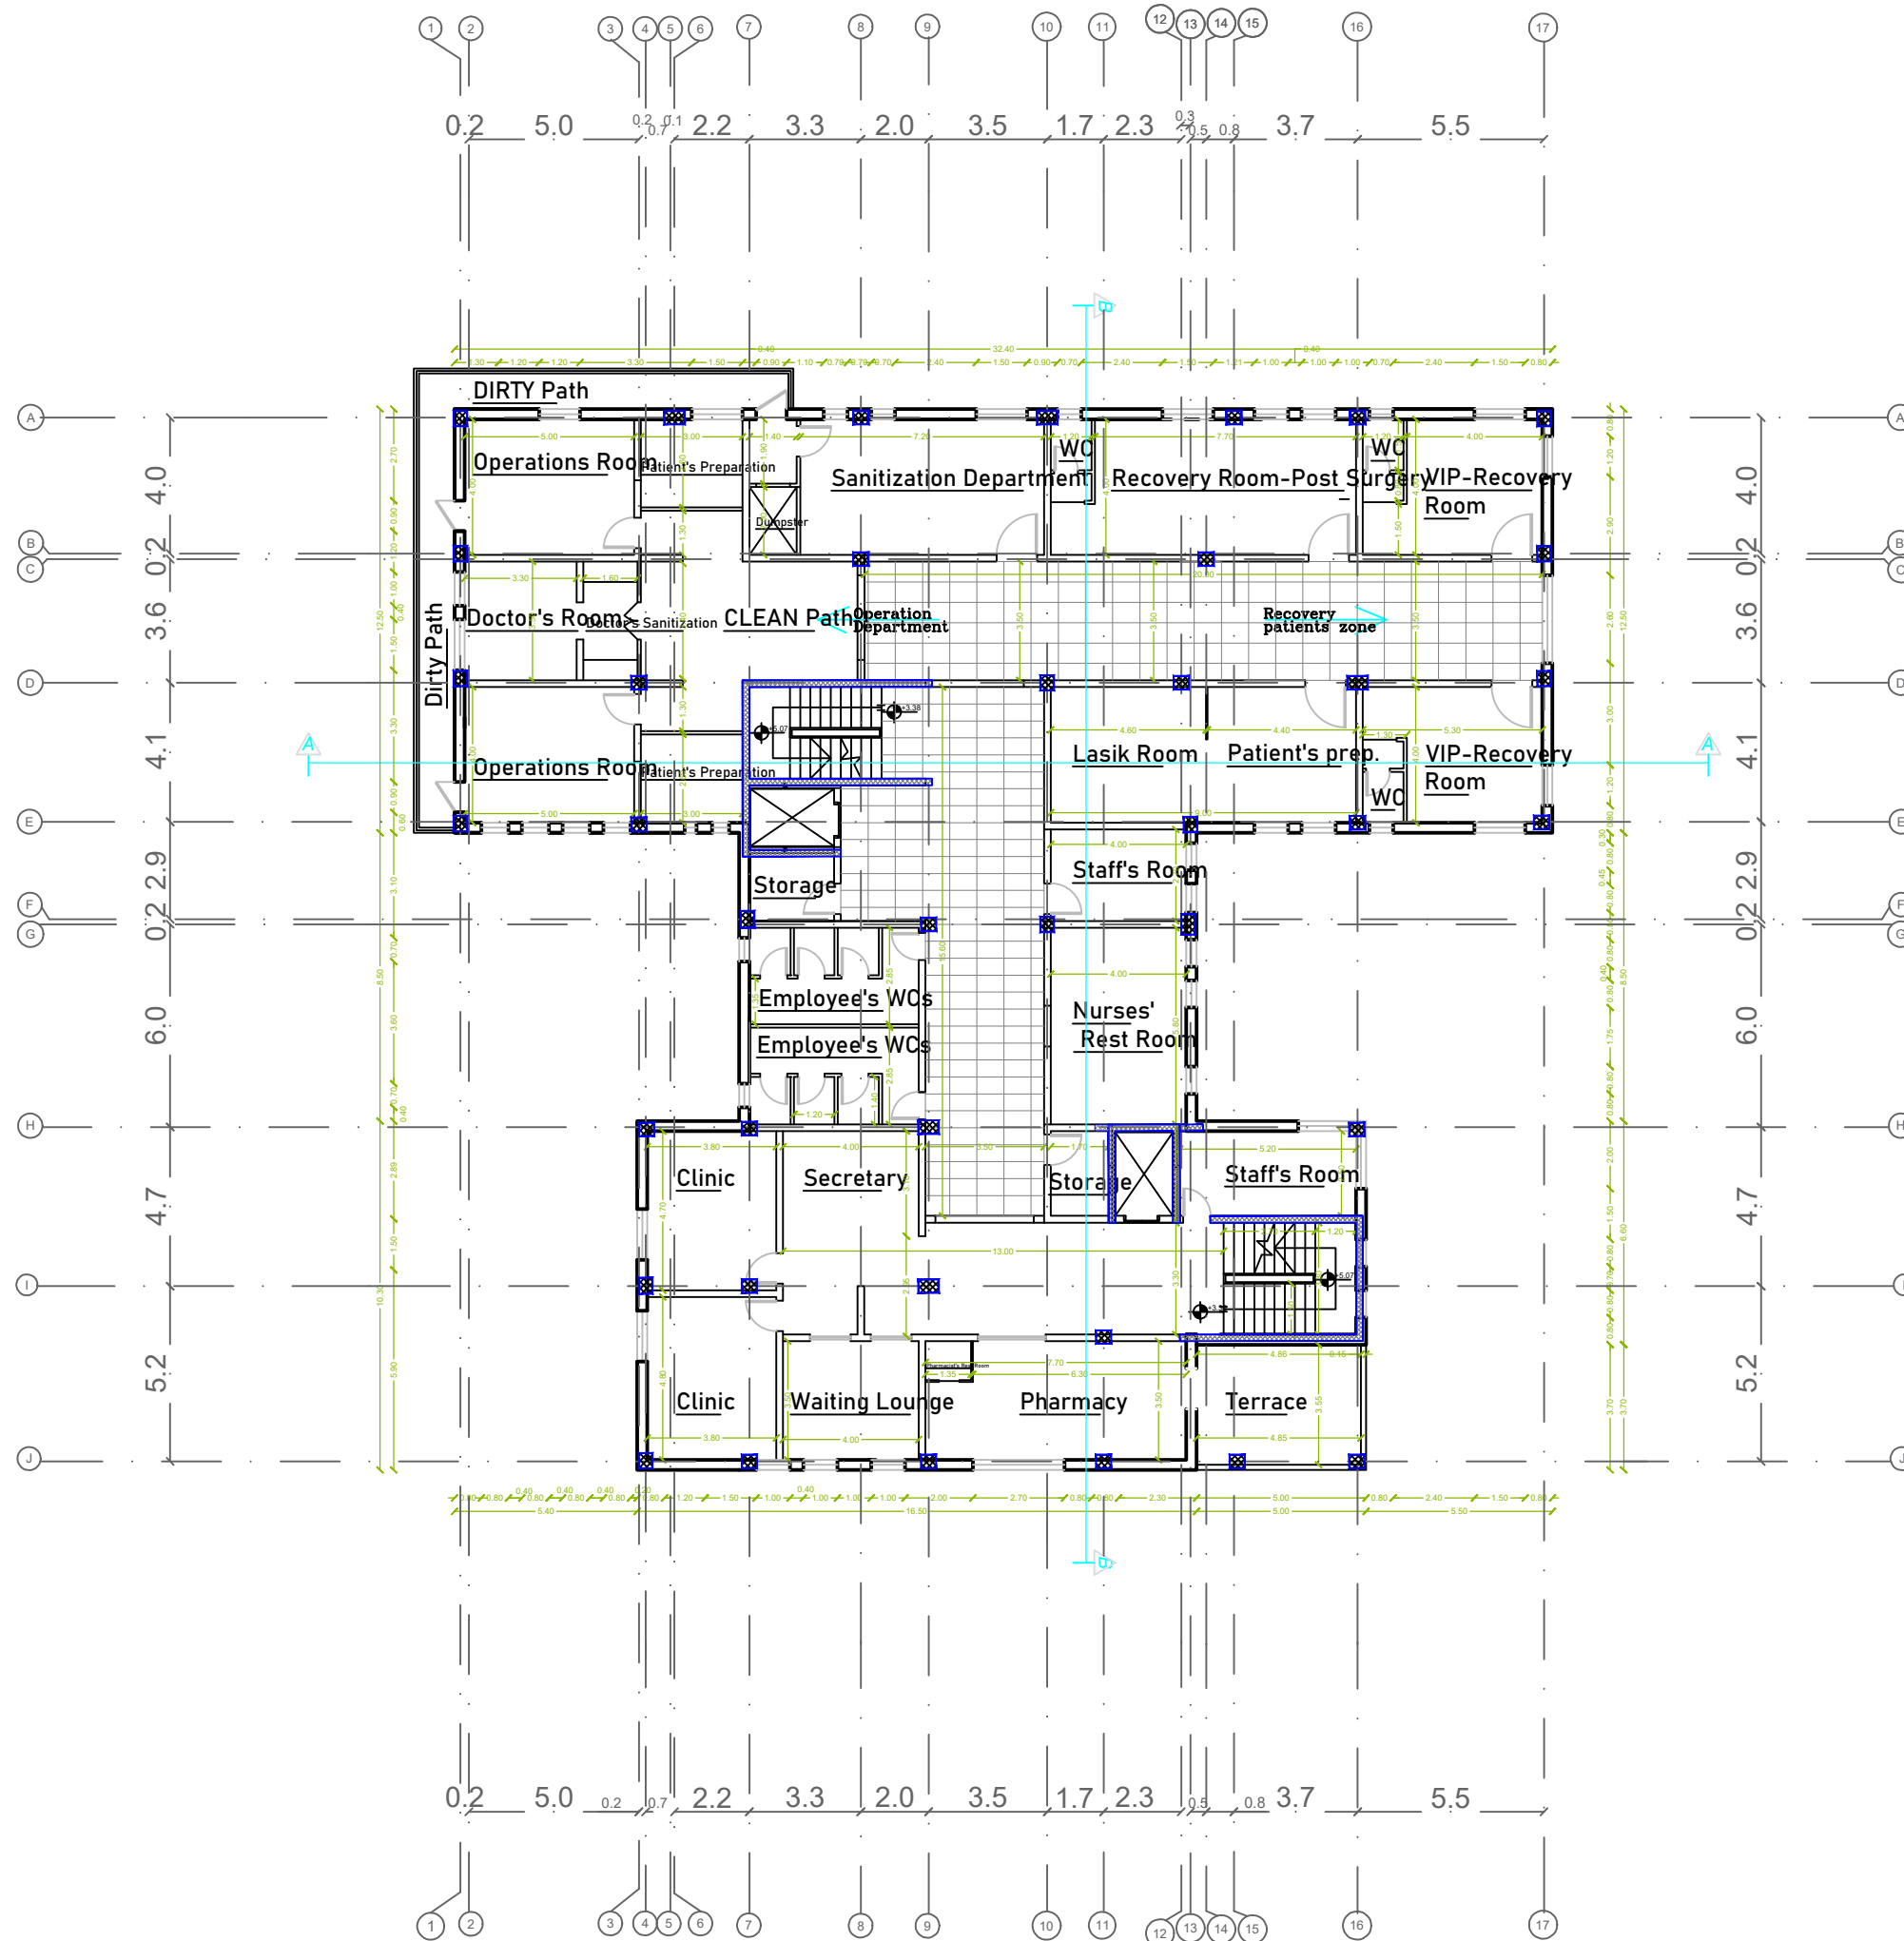



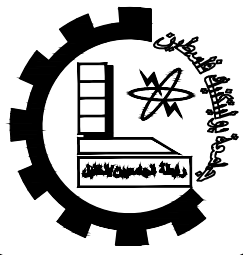

Palestine Polytechnic University

Department of Civil Engineering

College of Engineering

Civil Engineering

Design V

Project I

Eye-specialist Hospital

supervisors:

Dr. Nasr Abboushi  
Design by Roa' Al-jondi

Hamza.haddad  
Mohammad abu lawi

Drawing Symbol


Arch07

Drawing Tittle

Secound Floor Plan  
-Dimension

scale

1:100

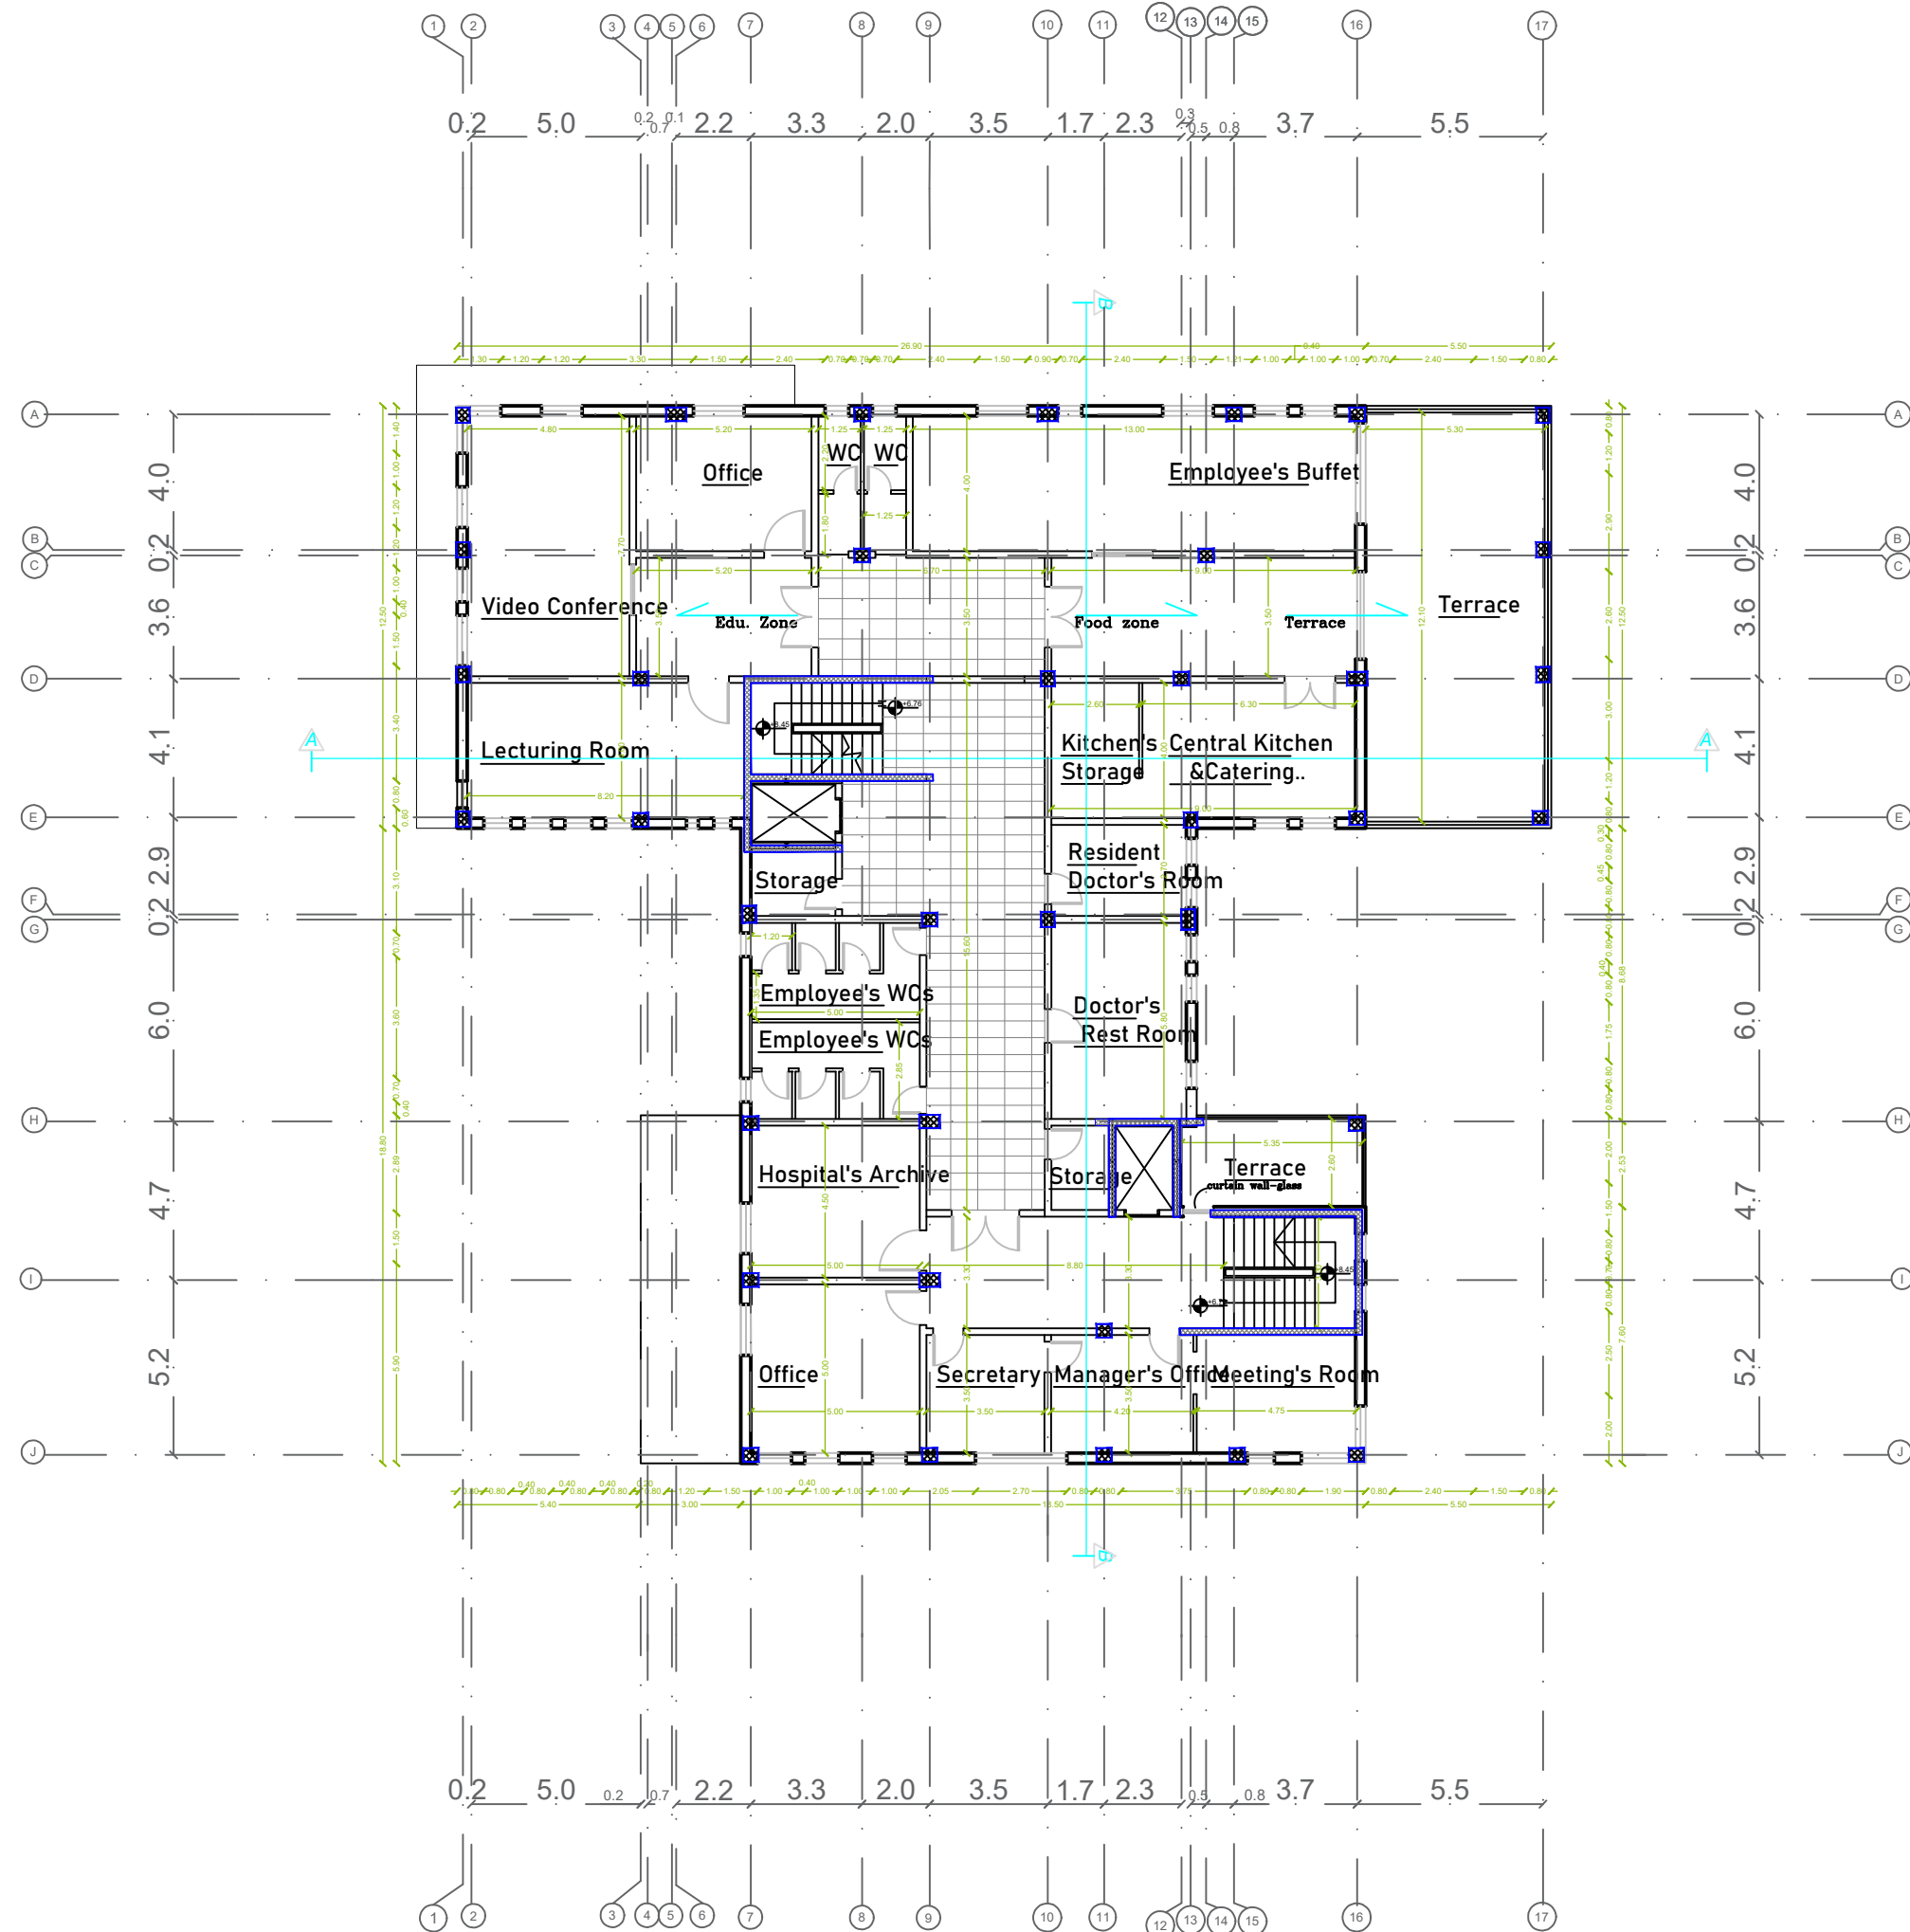



Palestine Polytechnic University

Department of Civil Engineering

College of Engineering

Civil Engineering

Design V

Project I

Eye-specialist Hospital

supervisors:

Dr. Nasr Abboushi  
Design by Roa' Al-jondi

Hamza.haddad  
Mohammad abu lawi

Drawing Sympol



Arch08


Drawing Tittle

Basement Floor Plan  
-Furniture

scale

 1:100

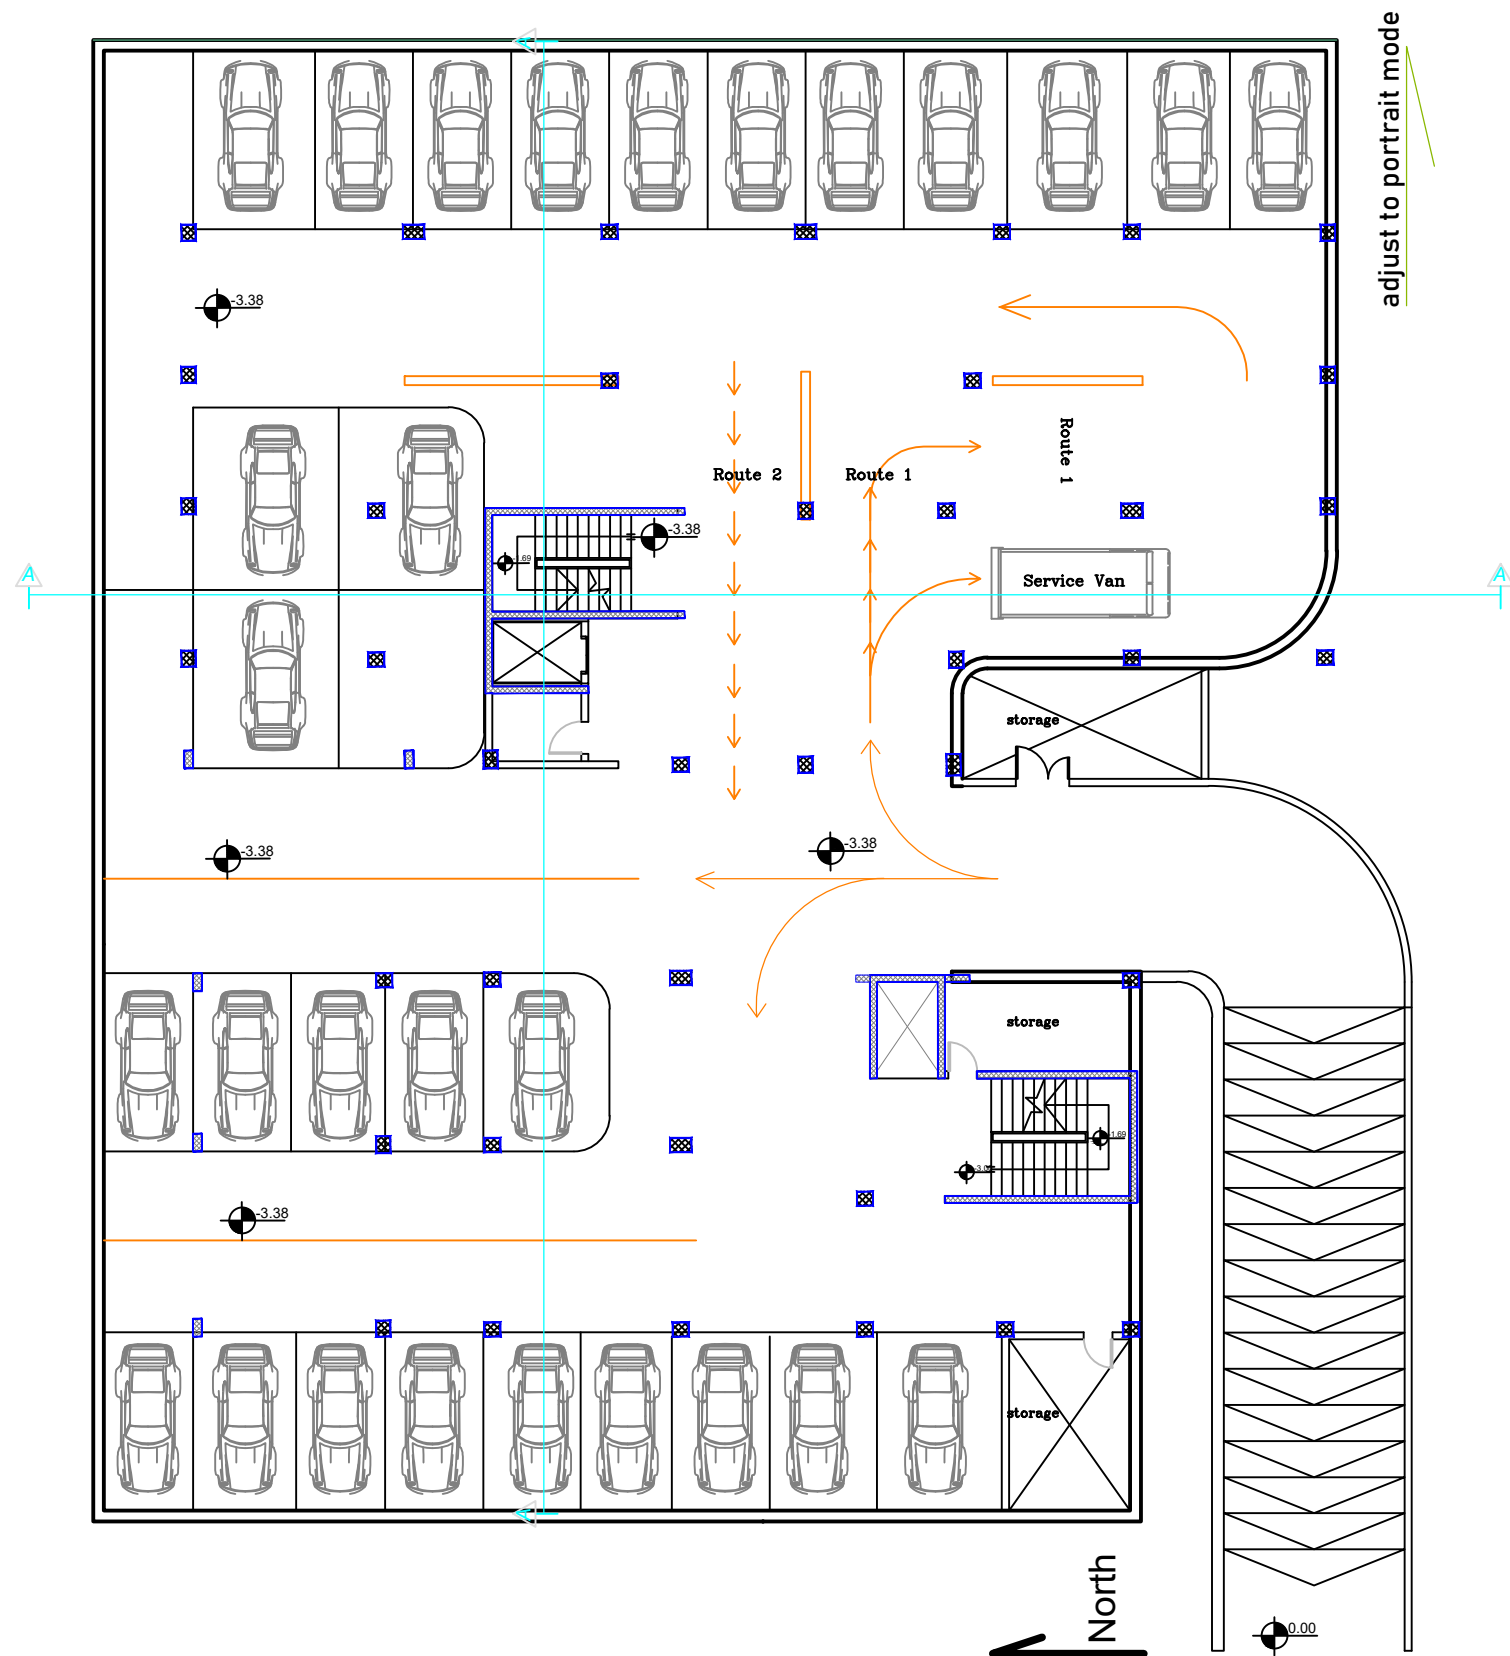

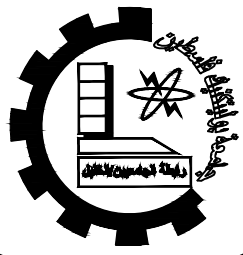

Palestine Polytechnic  
University  
Department of Civil  
Engineering  
College of Engineering  
Civil Engineering

Design V  
Project I

Eye-specialist Hospital

supervisors:

Dr. Nasr Abboushi  
Design by Roa' Al-jondi  
Hamza.haddad  
Mohammad abu lawi

Drawing Sympol



Arch09


Drawing Tittle

Ground Floor Plan  
-Furniture

scale

 1:100

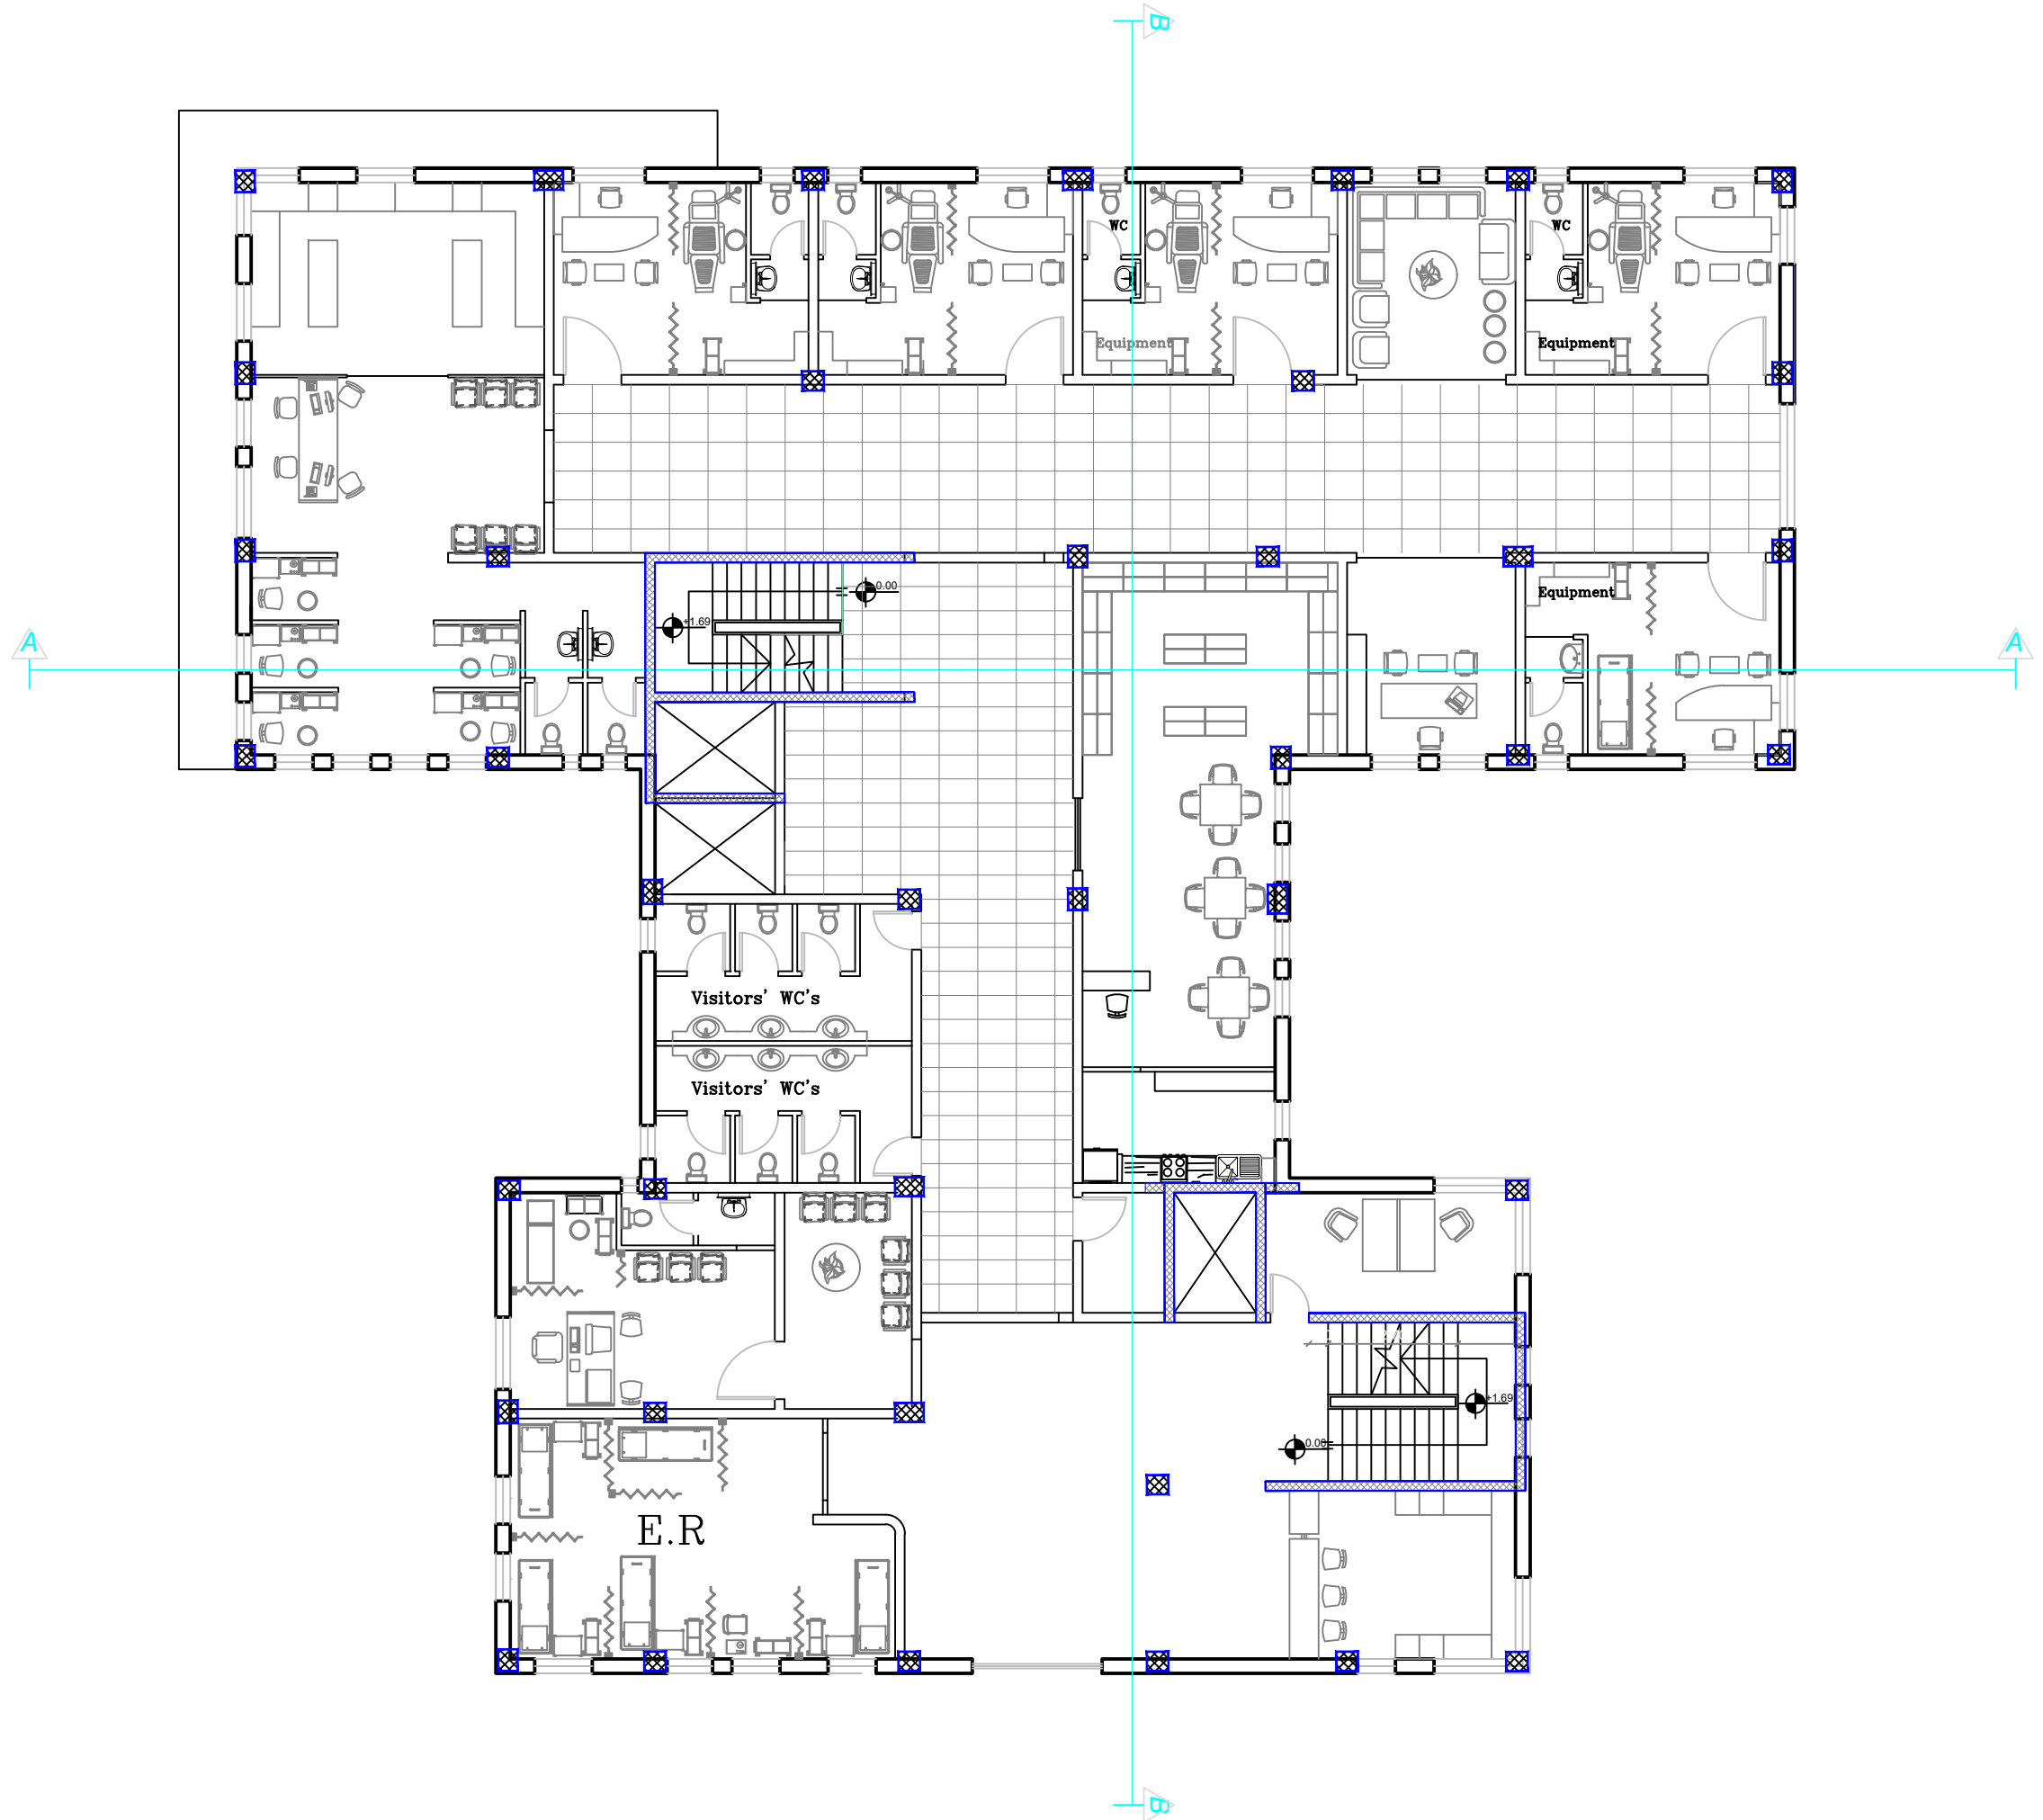

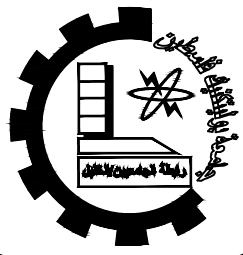

Palestine Polytechnic University  
 Department of Civil Engineering  
 College of Engineering  
 Civil Engineering

Design V  
 Project I

Eye-specialist Hospital

supervisors:

Dr. Nasr Abboushi  
 Design by Roa' Al-jondi  
 Hamza.haddad  
 Mohammad abu lawi

Drawing Symbol



Arch10

Drawing Tittle


First Floor Plan  
 -Furniture

scale

 1:100

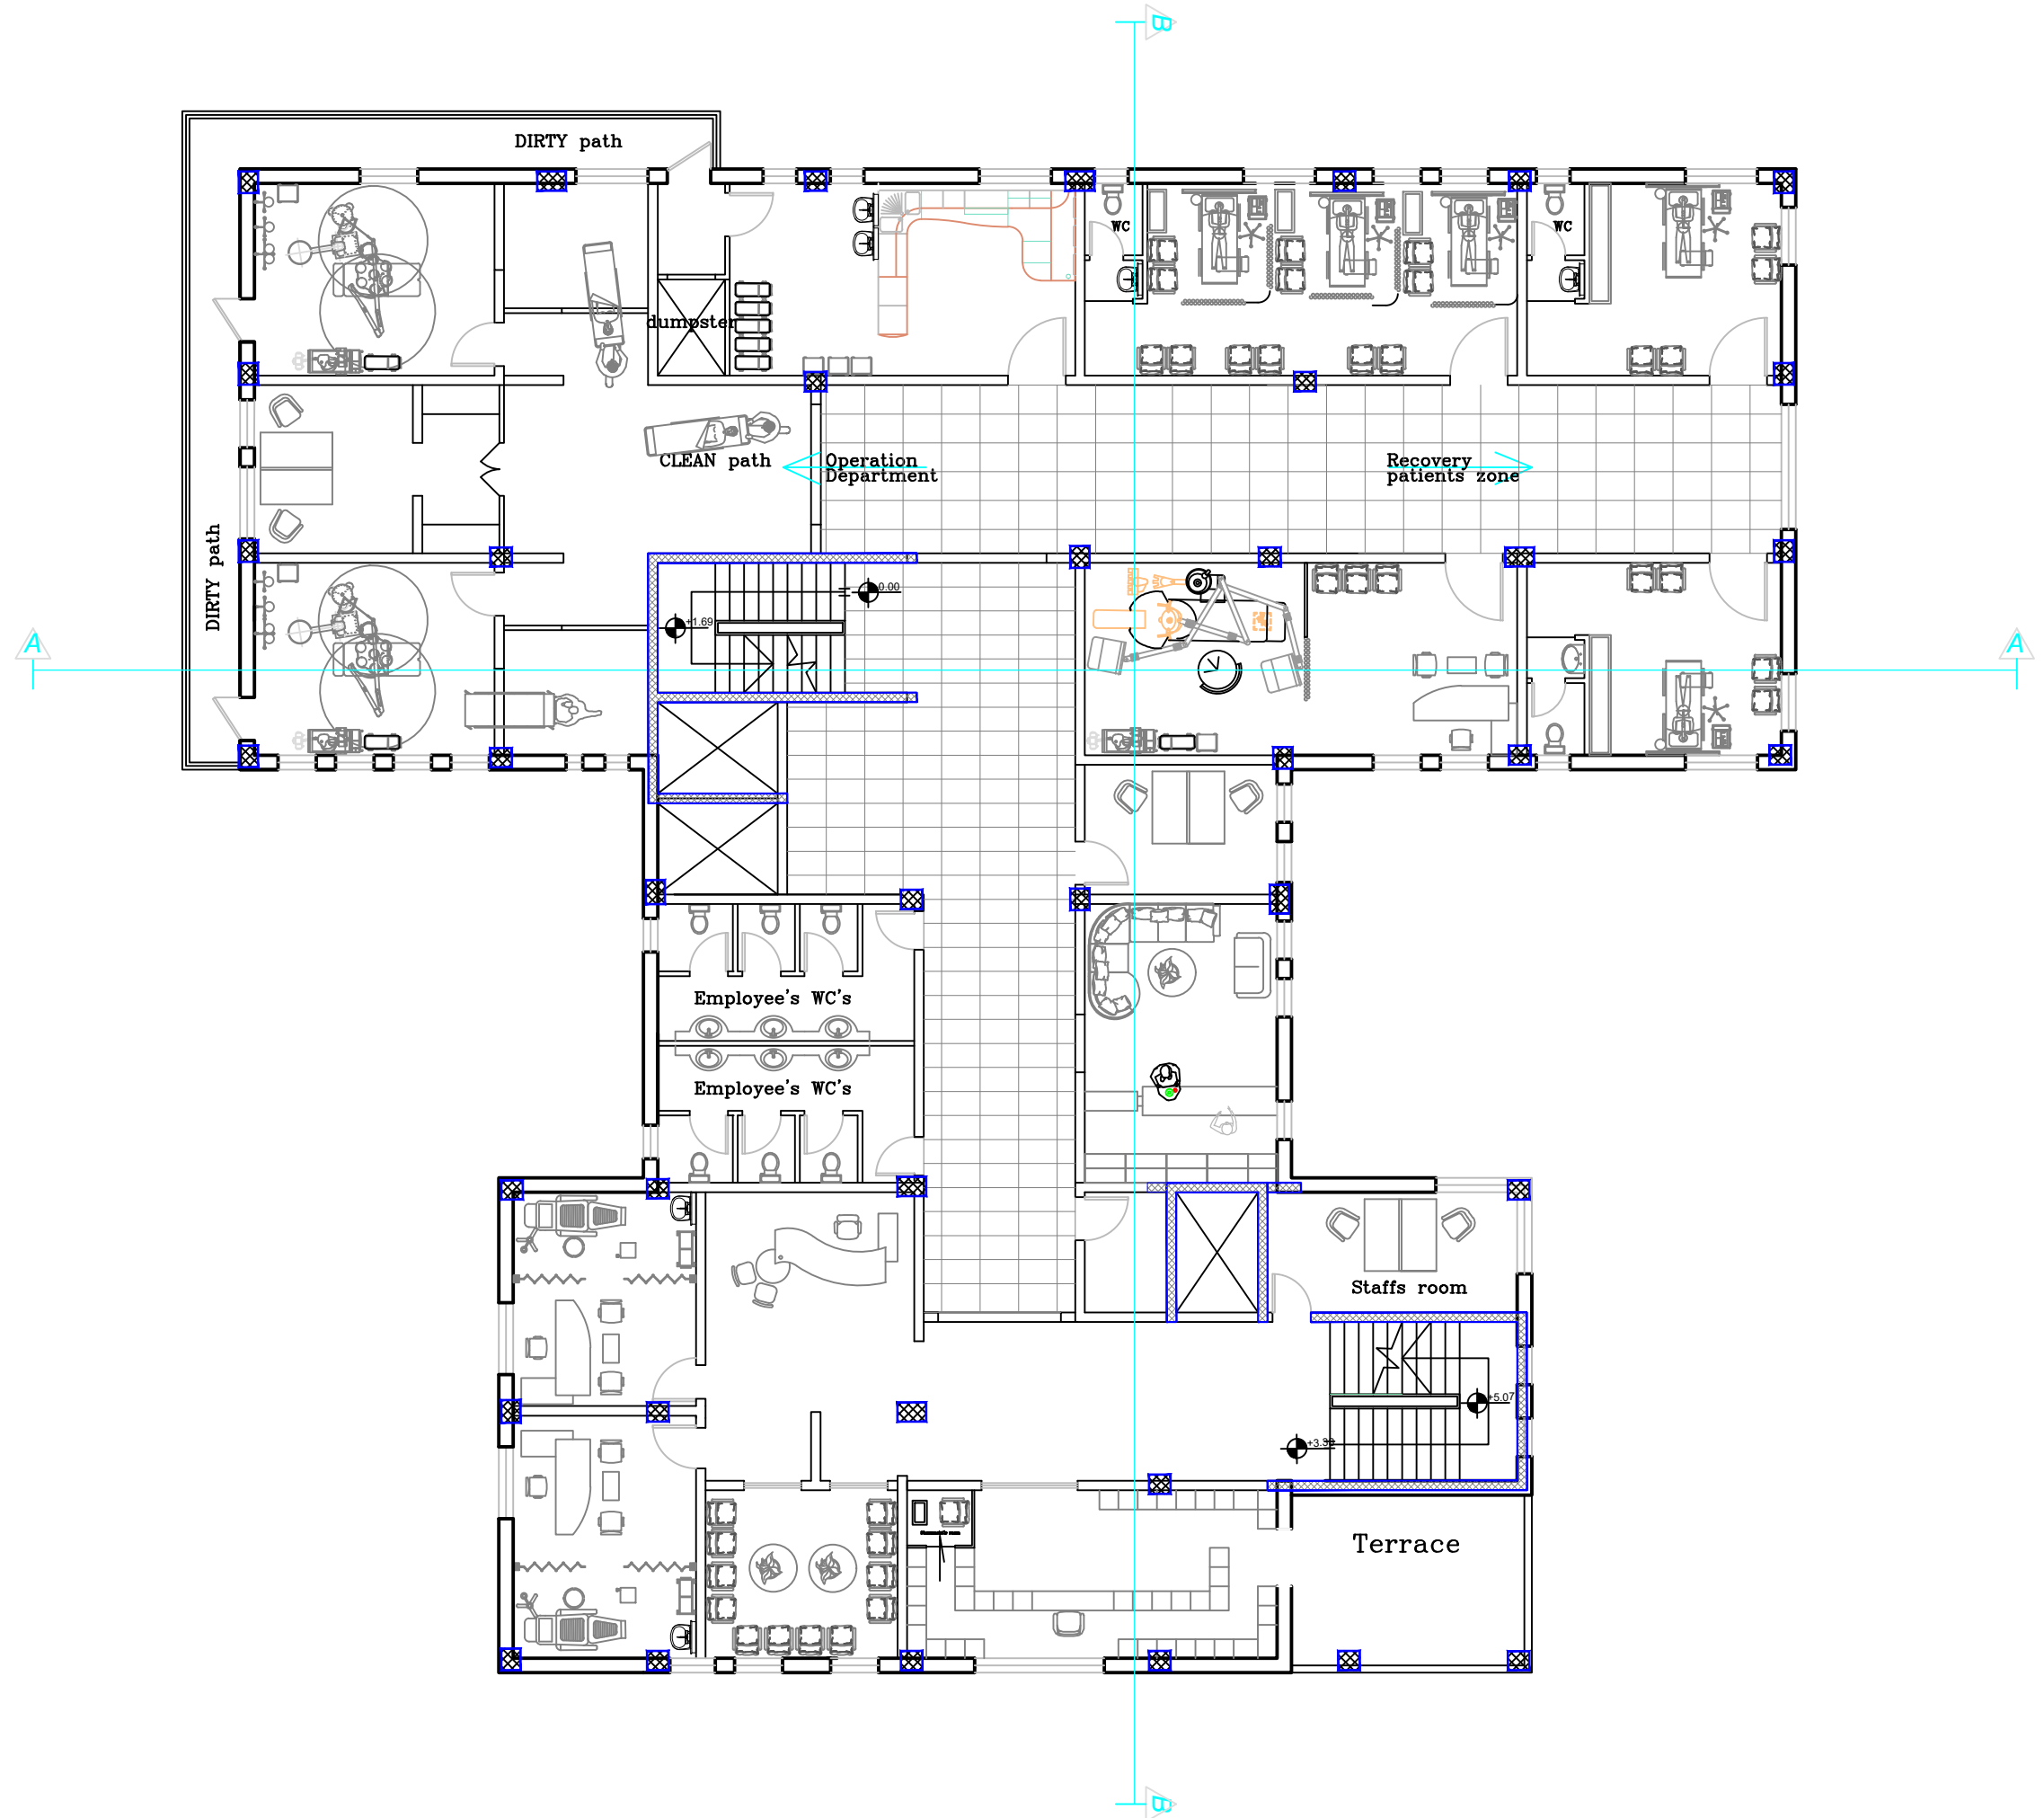



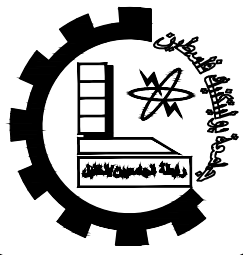

Palestine Polytechnic  
University  
Department of Civil  
Engineering  
College of Engineering  
Civil Engineering

Design V  
Project I

Eye-specialist Hospital

supervisors:

Dr. Nasr Abboushi  
Design by Roa' Al-jondi  
Hamza.haddad  
Mohammad abu lawi

Drawing Symbol



Arch11


Drawing Tittle

Second Floor Plan  
-Furniture

scale

 1:100

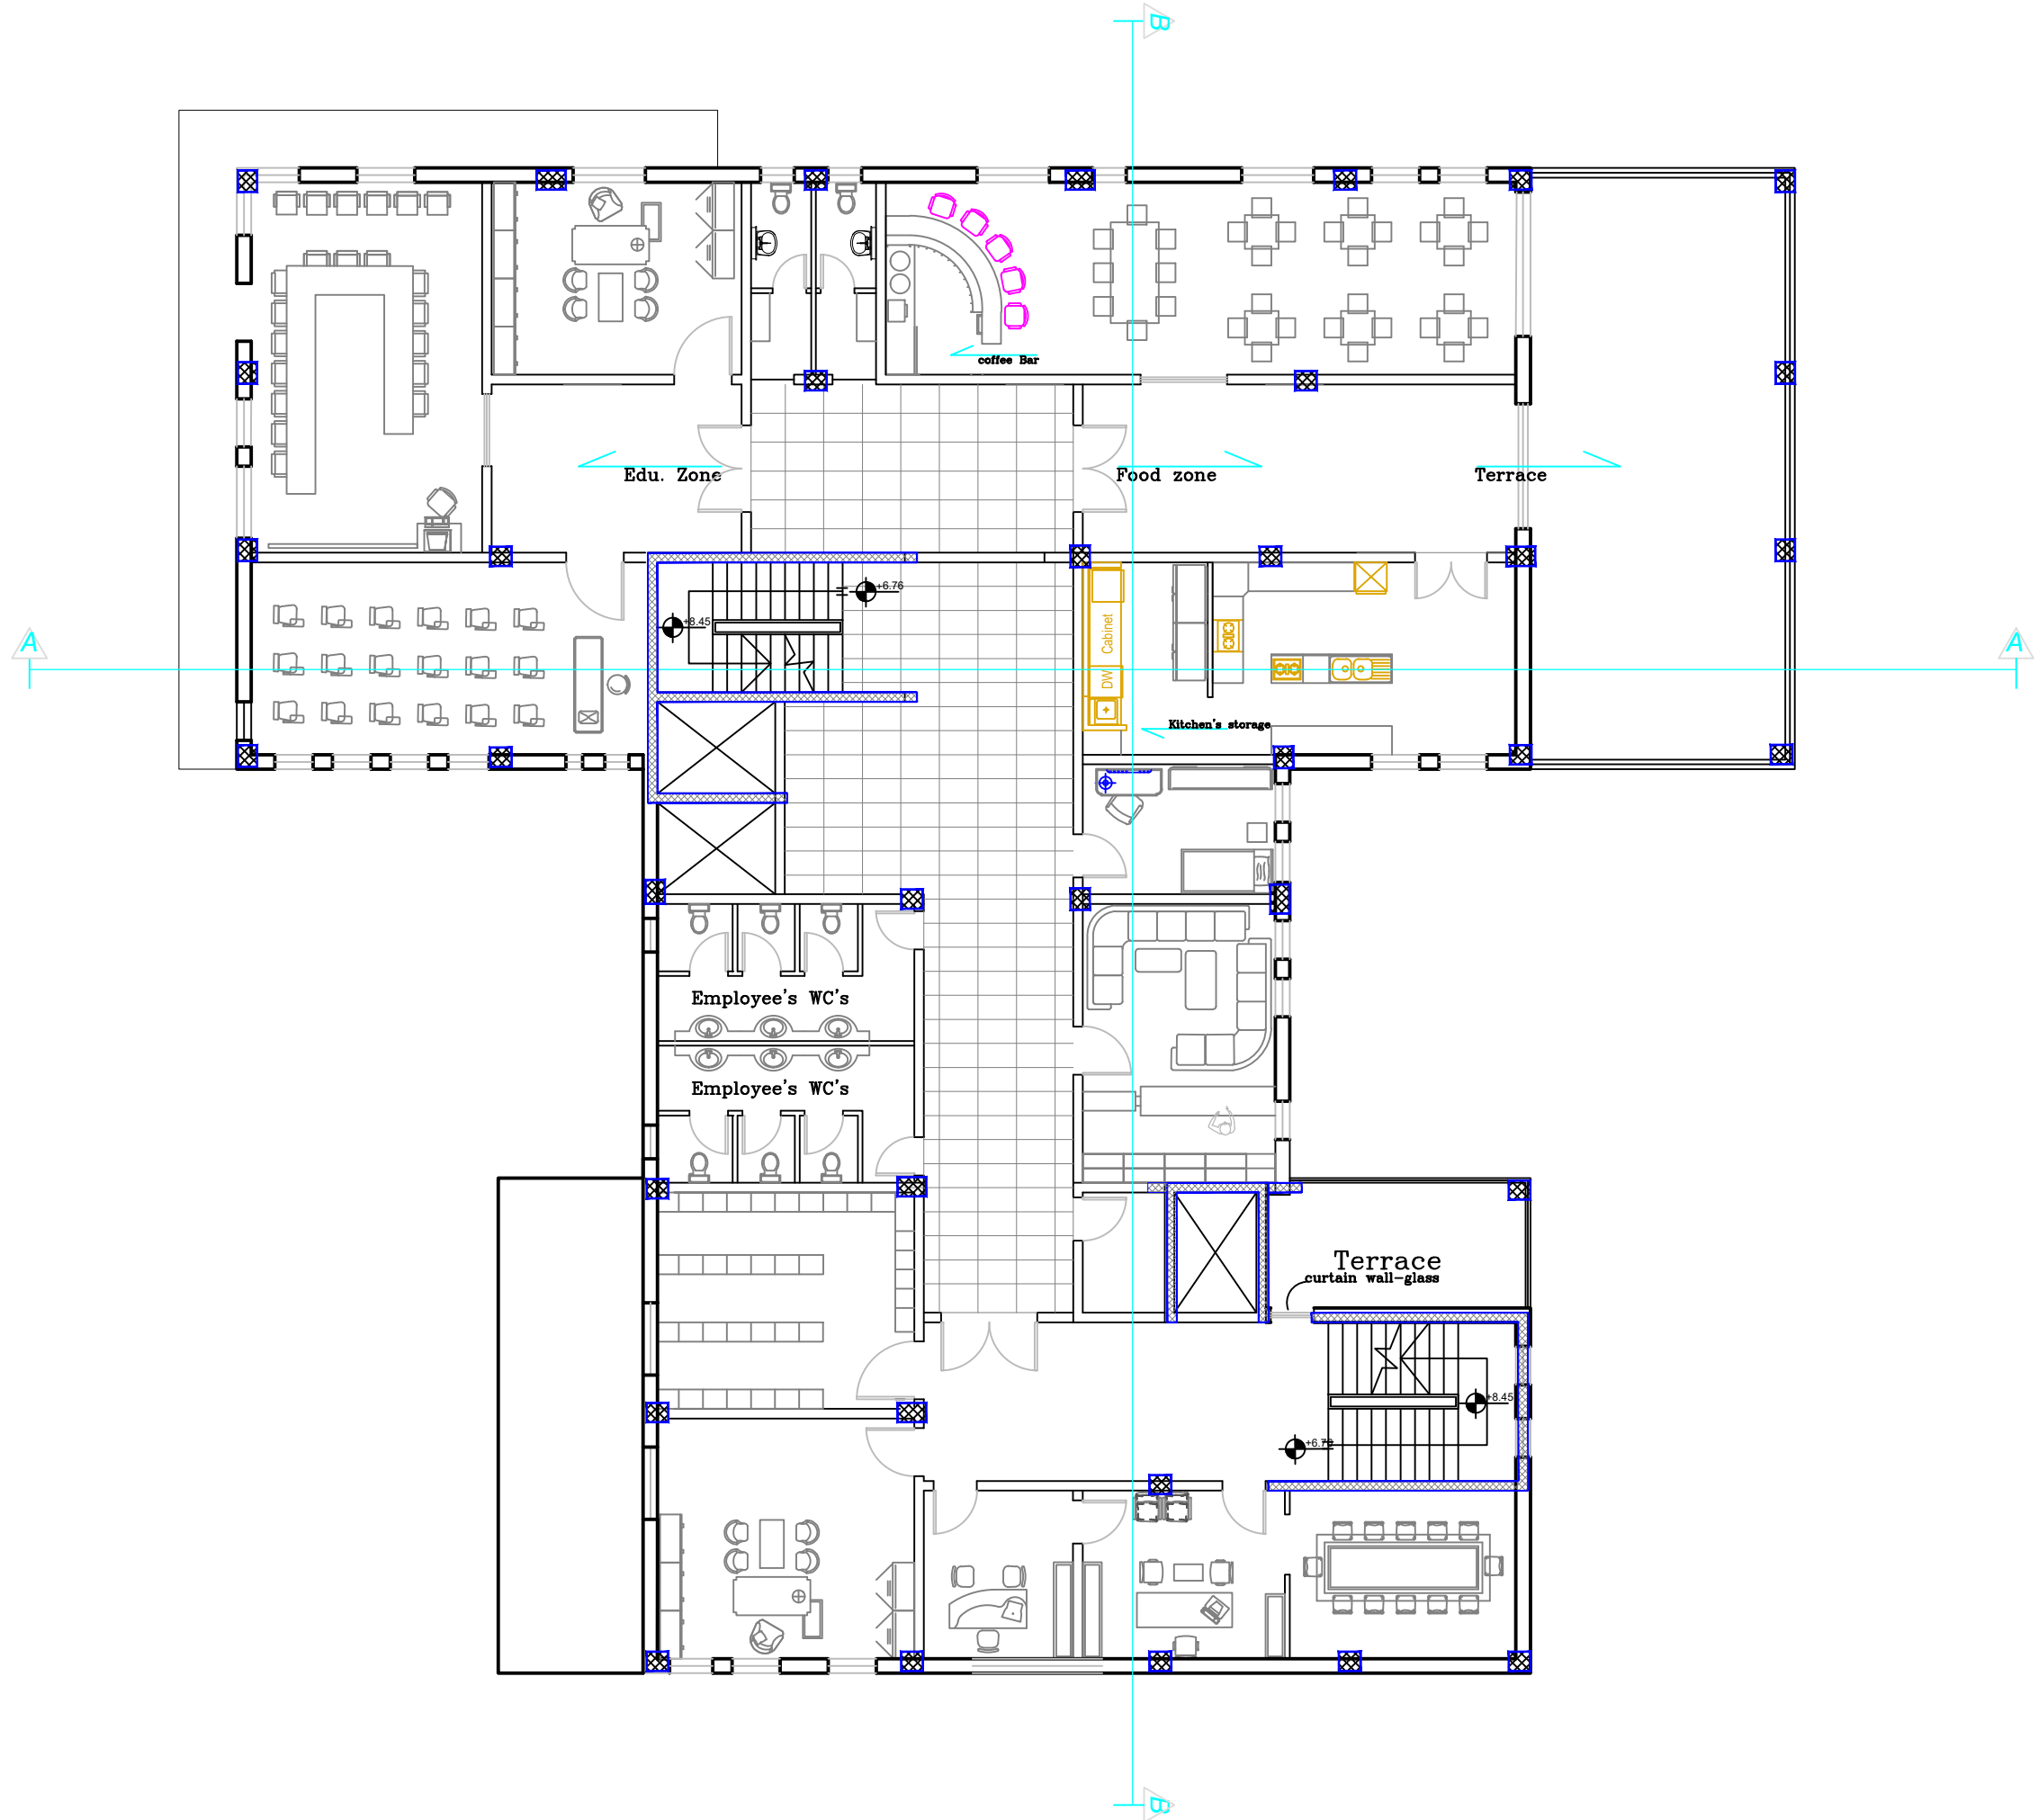

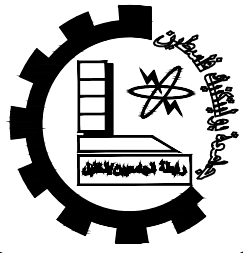

Palestine Polytechnic University

Department of Civil Engineering

College of Engineering

Civil Engineering

Design V

Project I

Eye-specialist Hospital

supervisors:

Dr. Nasr Abboushi  
Design by Roa' Al-jondi

Hamza.haddad  
Mohammad abu lawi

Drawing Symbol


Arch12


Drawing Tittle

Eastern Elevation-  
Main Elevation

scale

1:100

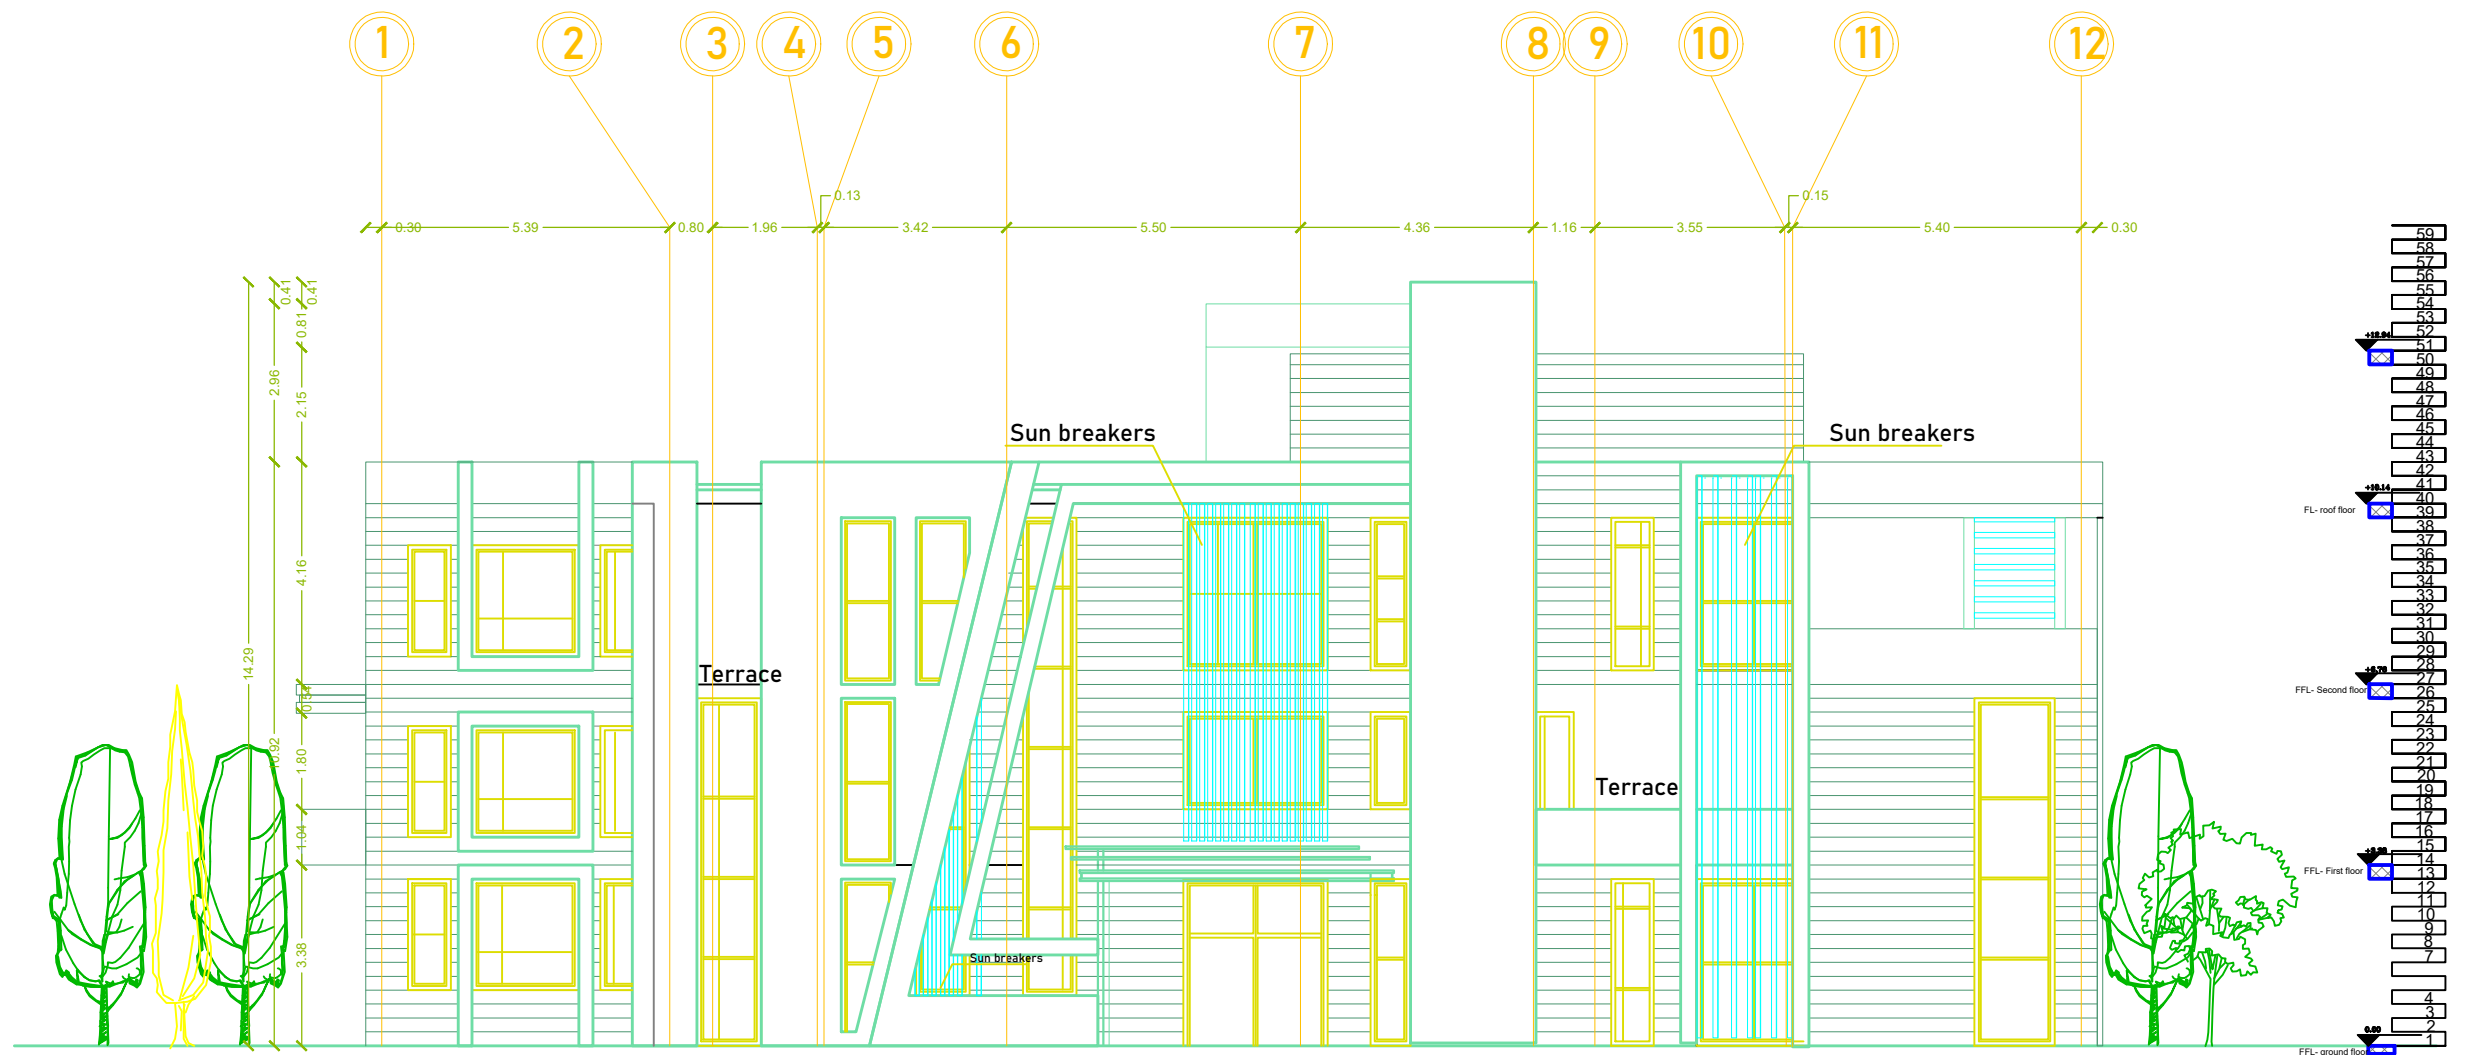

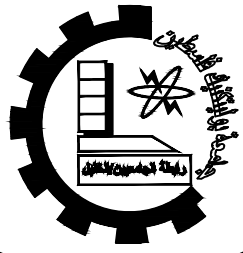

Palestine Polytechnic University

Department of Civil Engineering

College of Engineering

Civil Engineering

Design V

Project I

Eye-specialist Hospital

supervisors:

Dr. Nasr Abboushi  
Design by Roa' Al-jondi

Hamza.haddad  
Mohammad abu lawi

Drawing Symbol


Arch13


Drawing Tittle

Southern Elevation

scale

1:100

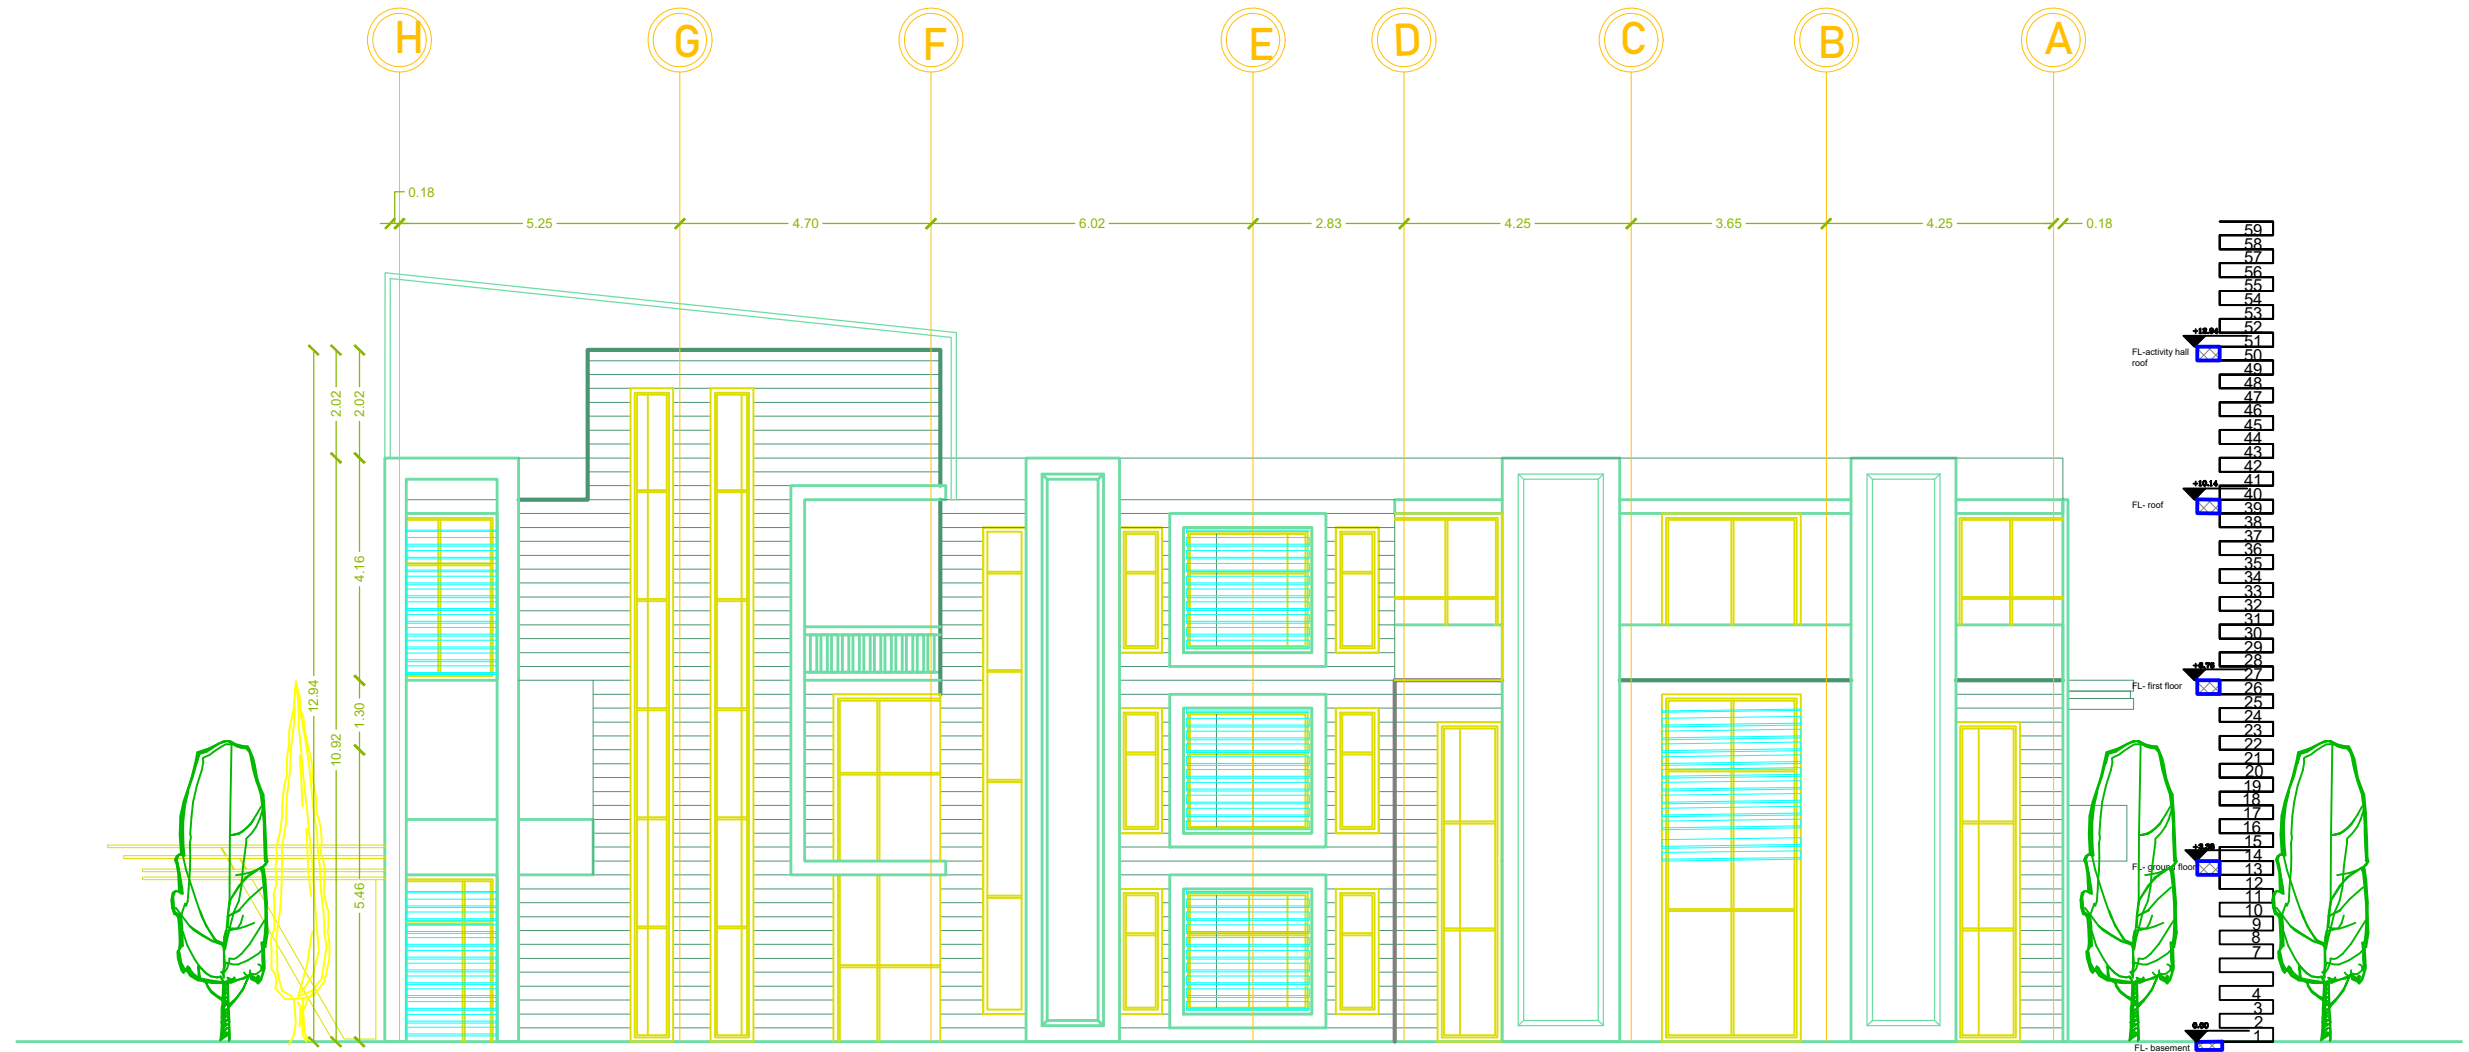

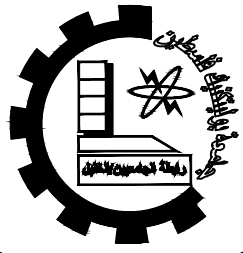

Palestine Polytechnic University

Department of Civil Engineering

College of Engineering

Civil Engineering

Design V

Project I

Eye-specialist Hospital

supervisors:

Dr. Nasr Abboushi  
Design by Roa' Al-jondi

Hamza.haddad  
Mohammad abu lawi

Drawing Symbol


Arch14

Drawing Tittle


Northern Elevation

scale

1:100

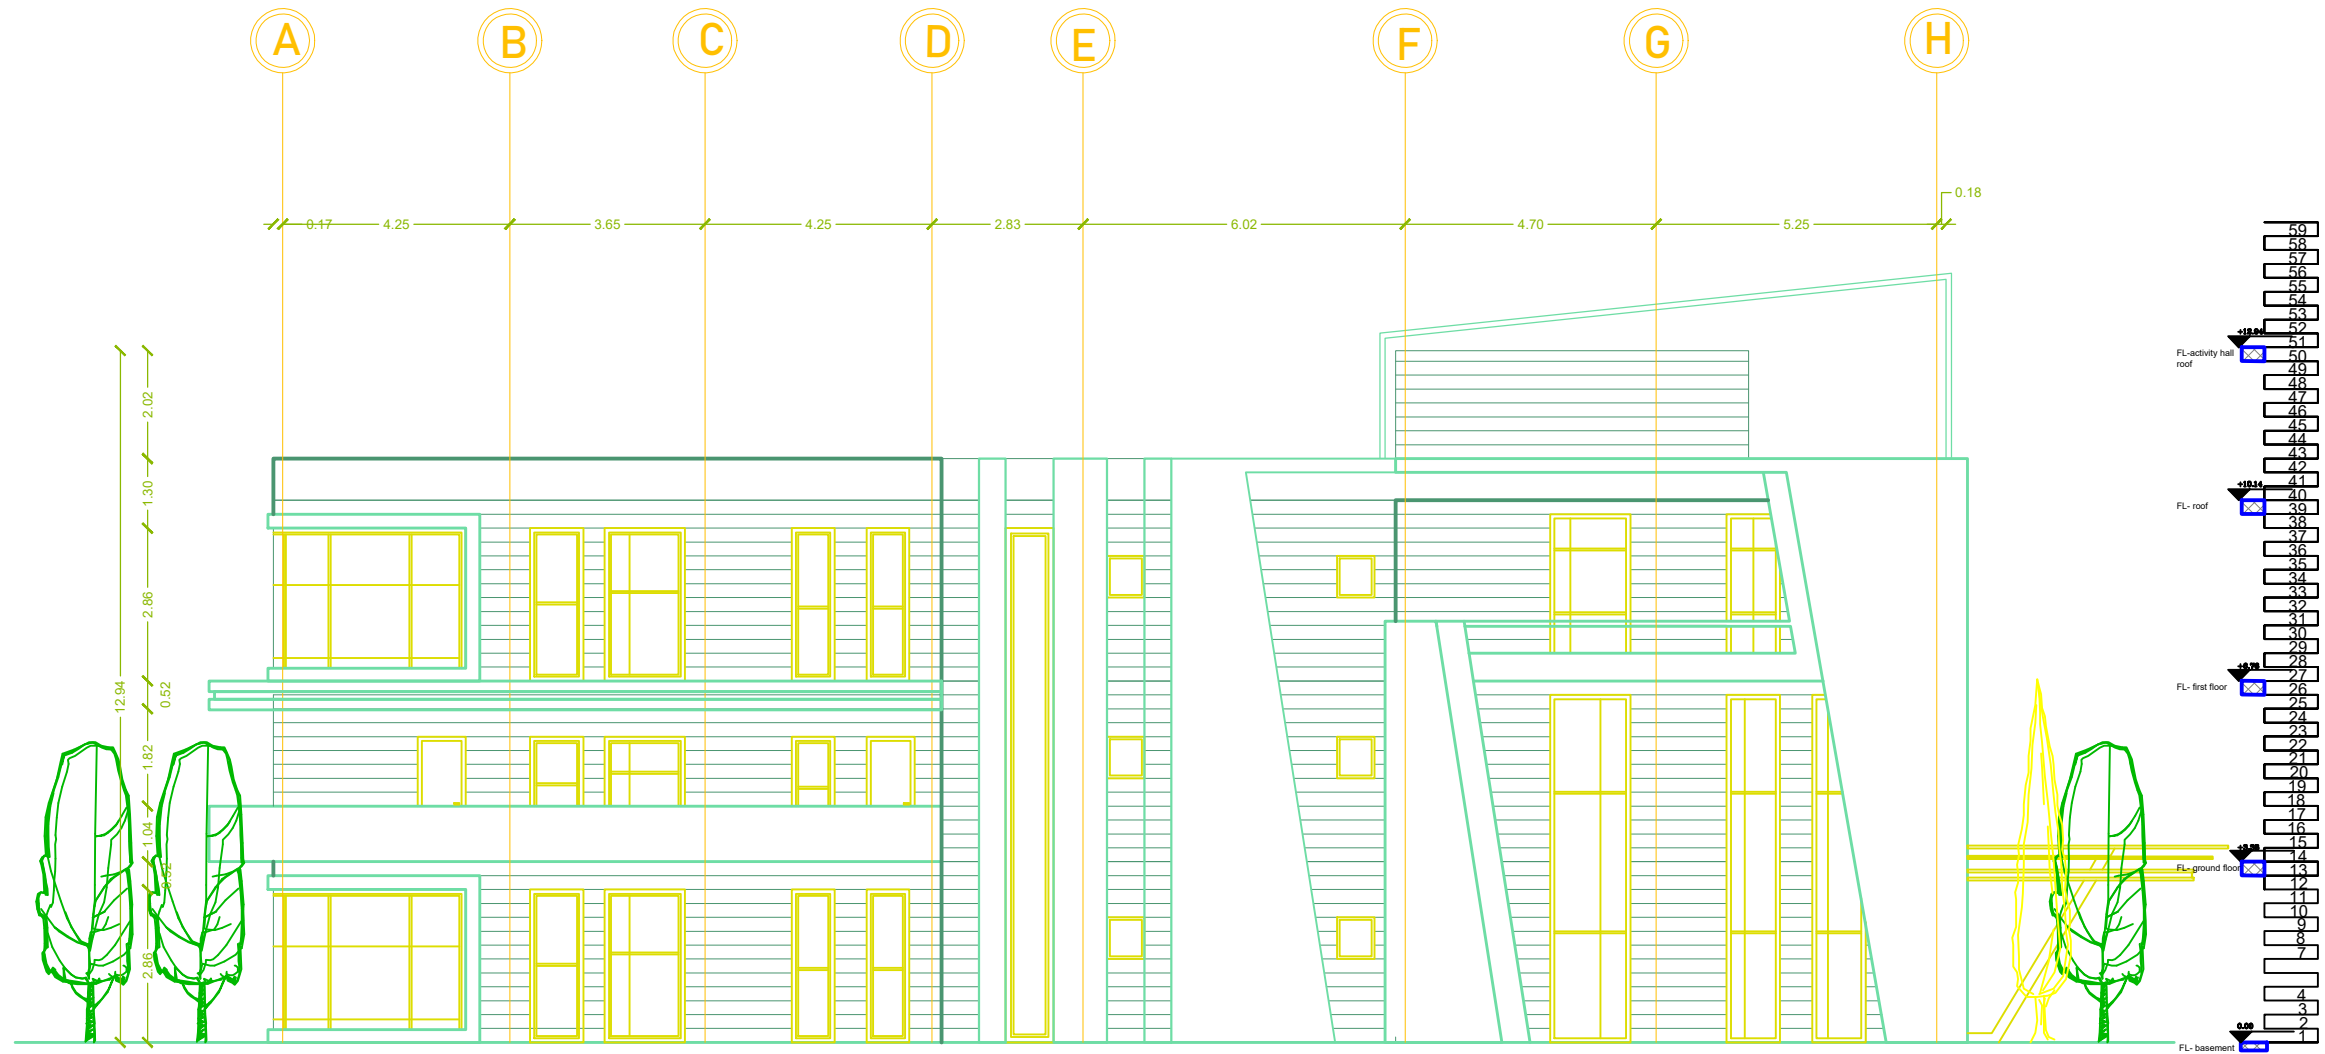



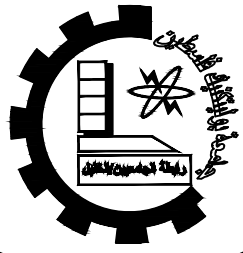

Palestine Polytechnic University

Department of Civil Engineering

College of Engineering

Civil Engineering

Design V

Project I

Eye-specialist Hospital

supervisors:

Dr. Nasr Abboushi  
Design by Roa' Al-jondi

Hamza.haddad  
Mohammad abu lawi

Drawing Symbol


Arch15


Drawing Tittle

Western Elevation

scale

1:100

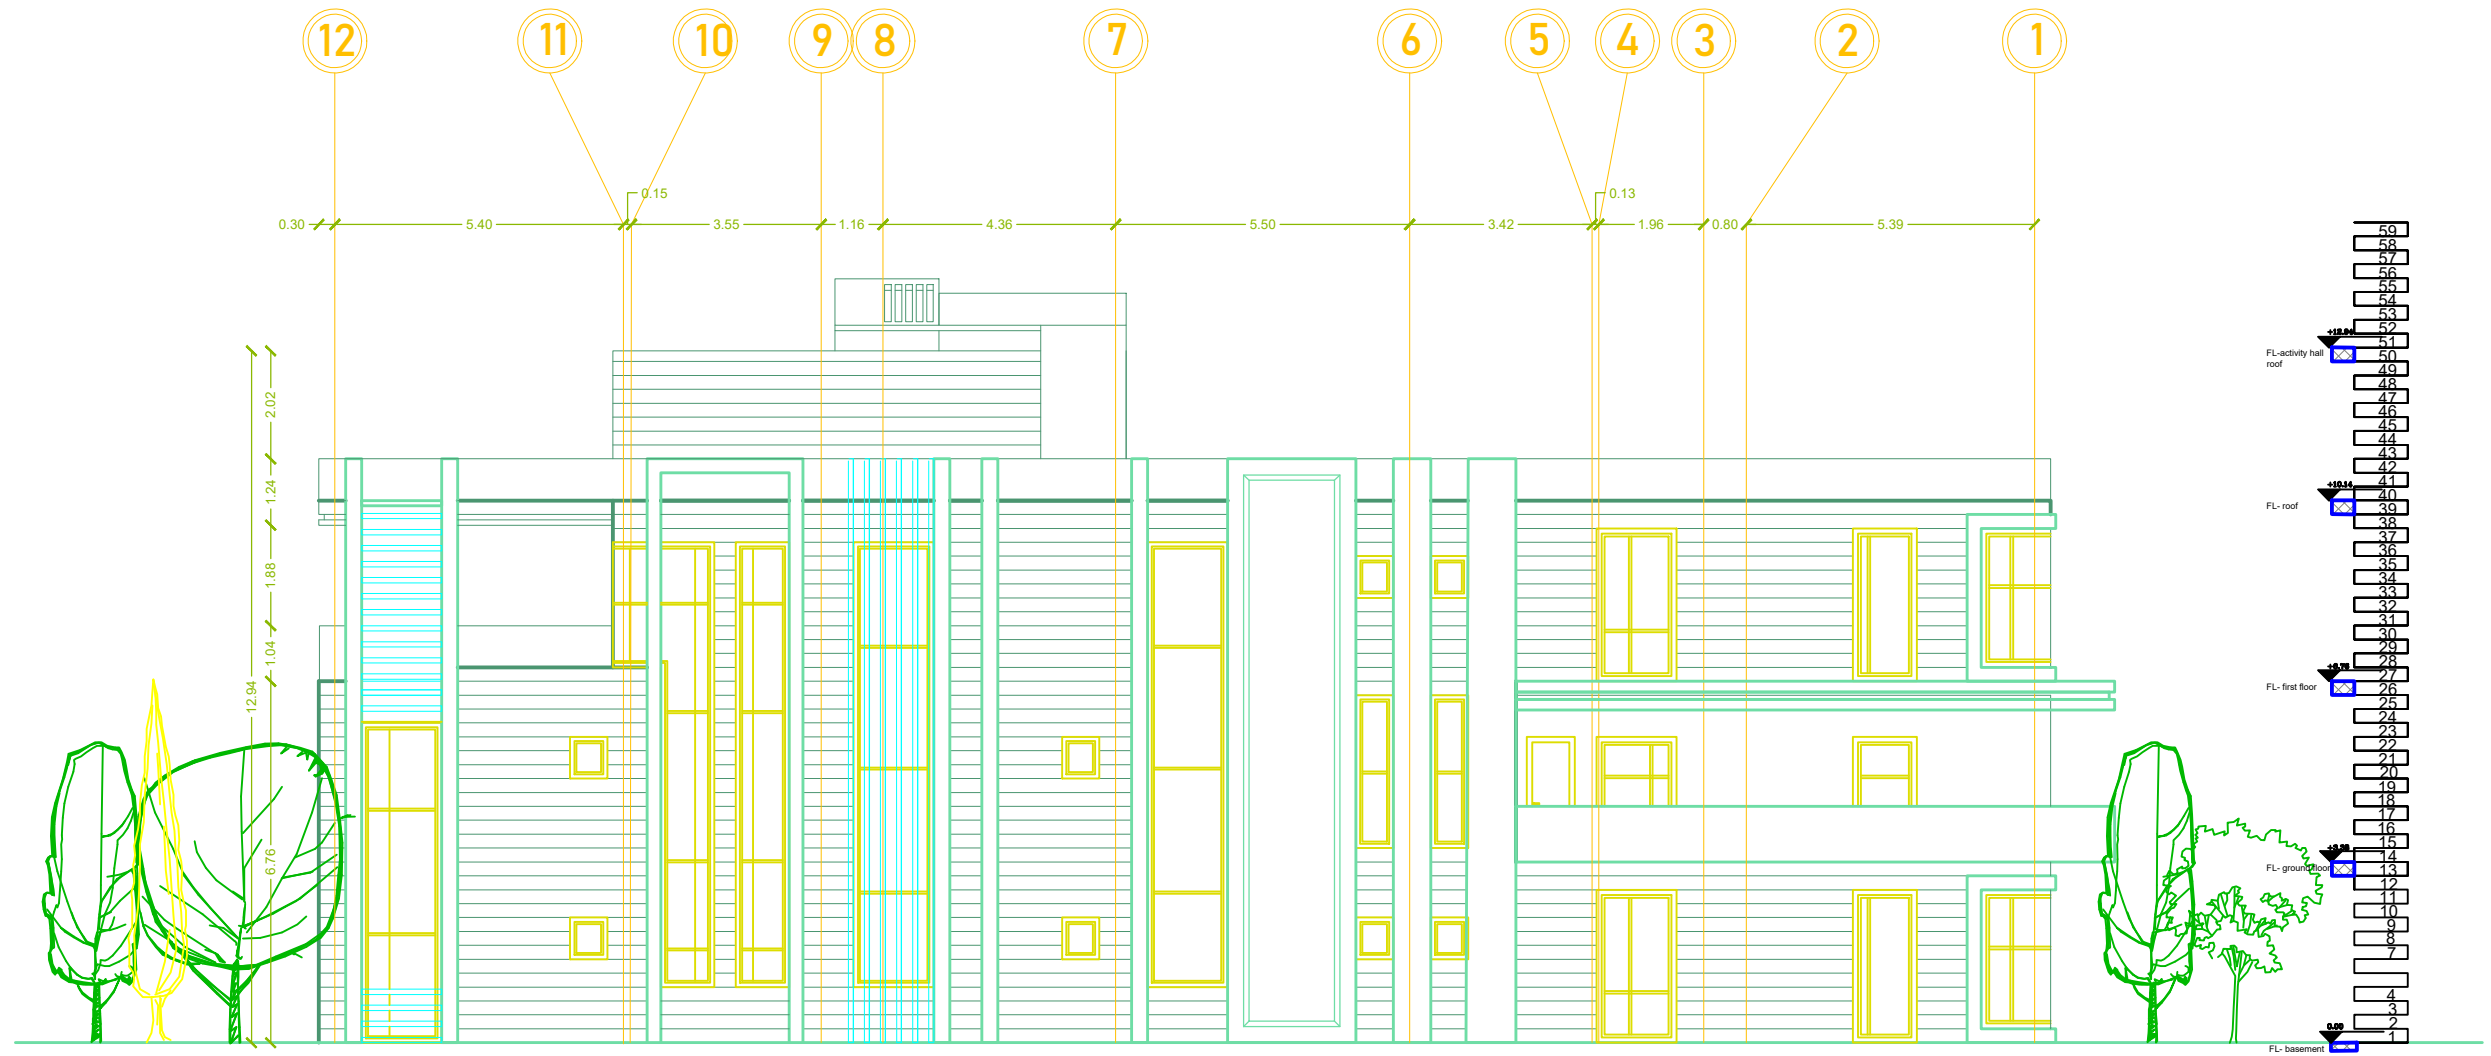

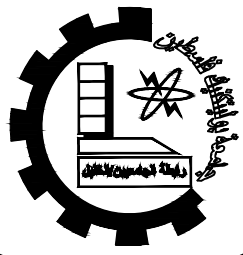

Palestine Polytechnic University

Department of Civil Engineering

College of Engineering

Civil Engineering

Design V

Project I

Eye-specialist Hospital

supervisors:

Dr. Nasr Abboushi  
Design by Roa' Al-jondi

Hamza.haddad  
Mohammad abu lawi

Drawing Symbol


Arch16


Drawing Tittle

Section A-A

scale

1:100

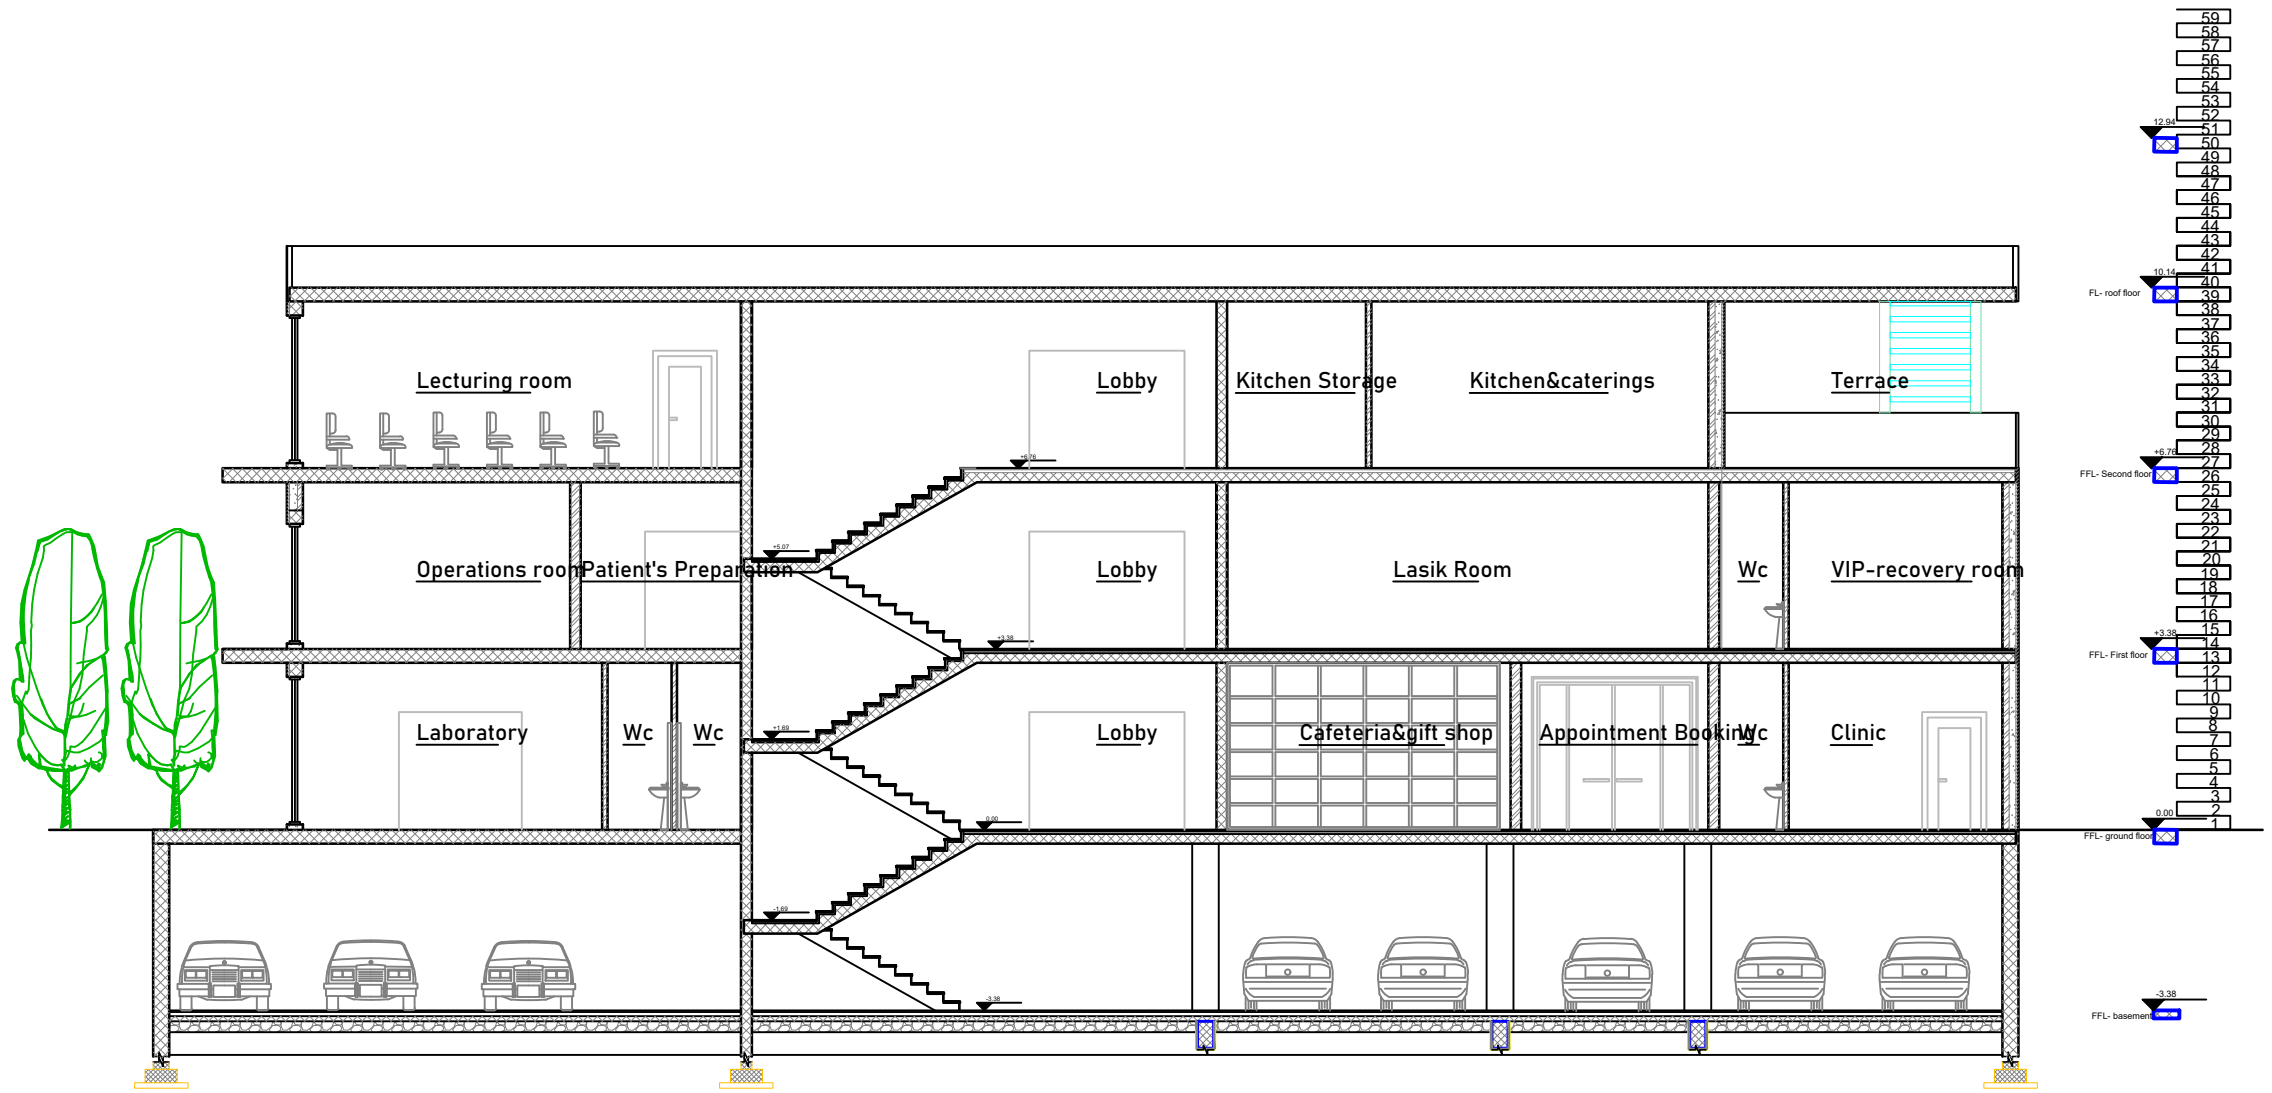

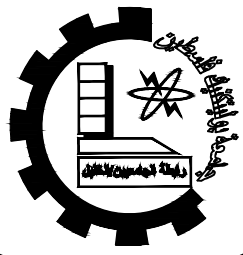

Palestine Polytechnic University

Department of Civil Engineering

College of Engineering

Civil Engineering

Design V

Project I

Eye-specialist Hospital

supervisors:

Dr. Nasr Abboushi  
Design by Roa' Al-jondi

Hamza.haddad  
Mohammad abu lawi

Drawing Symbol


Arch17


Drawing Tittle

Section B-B

scale

1:100

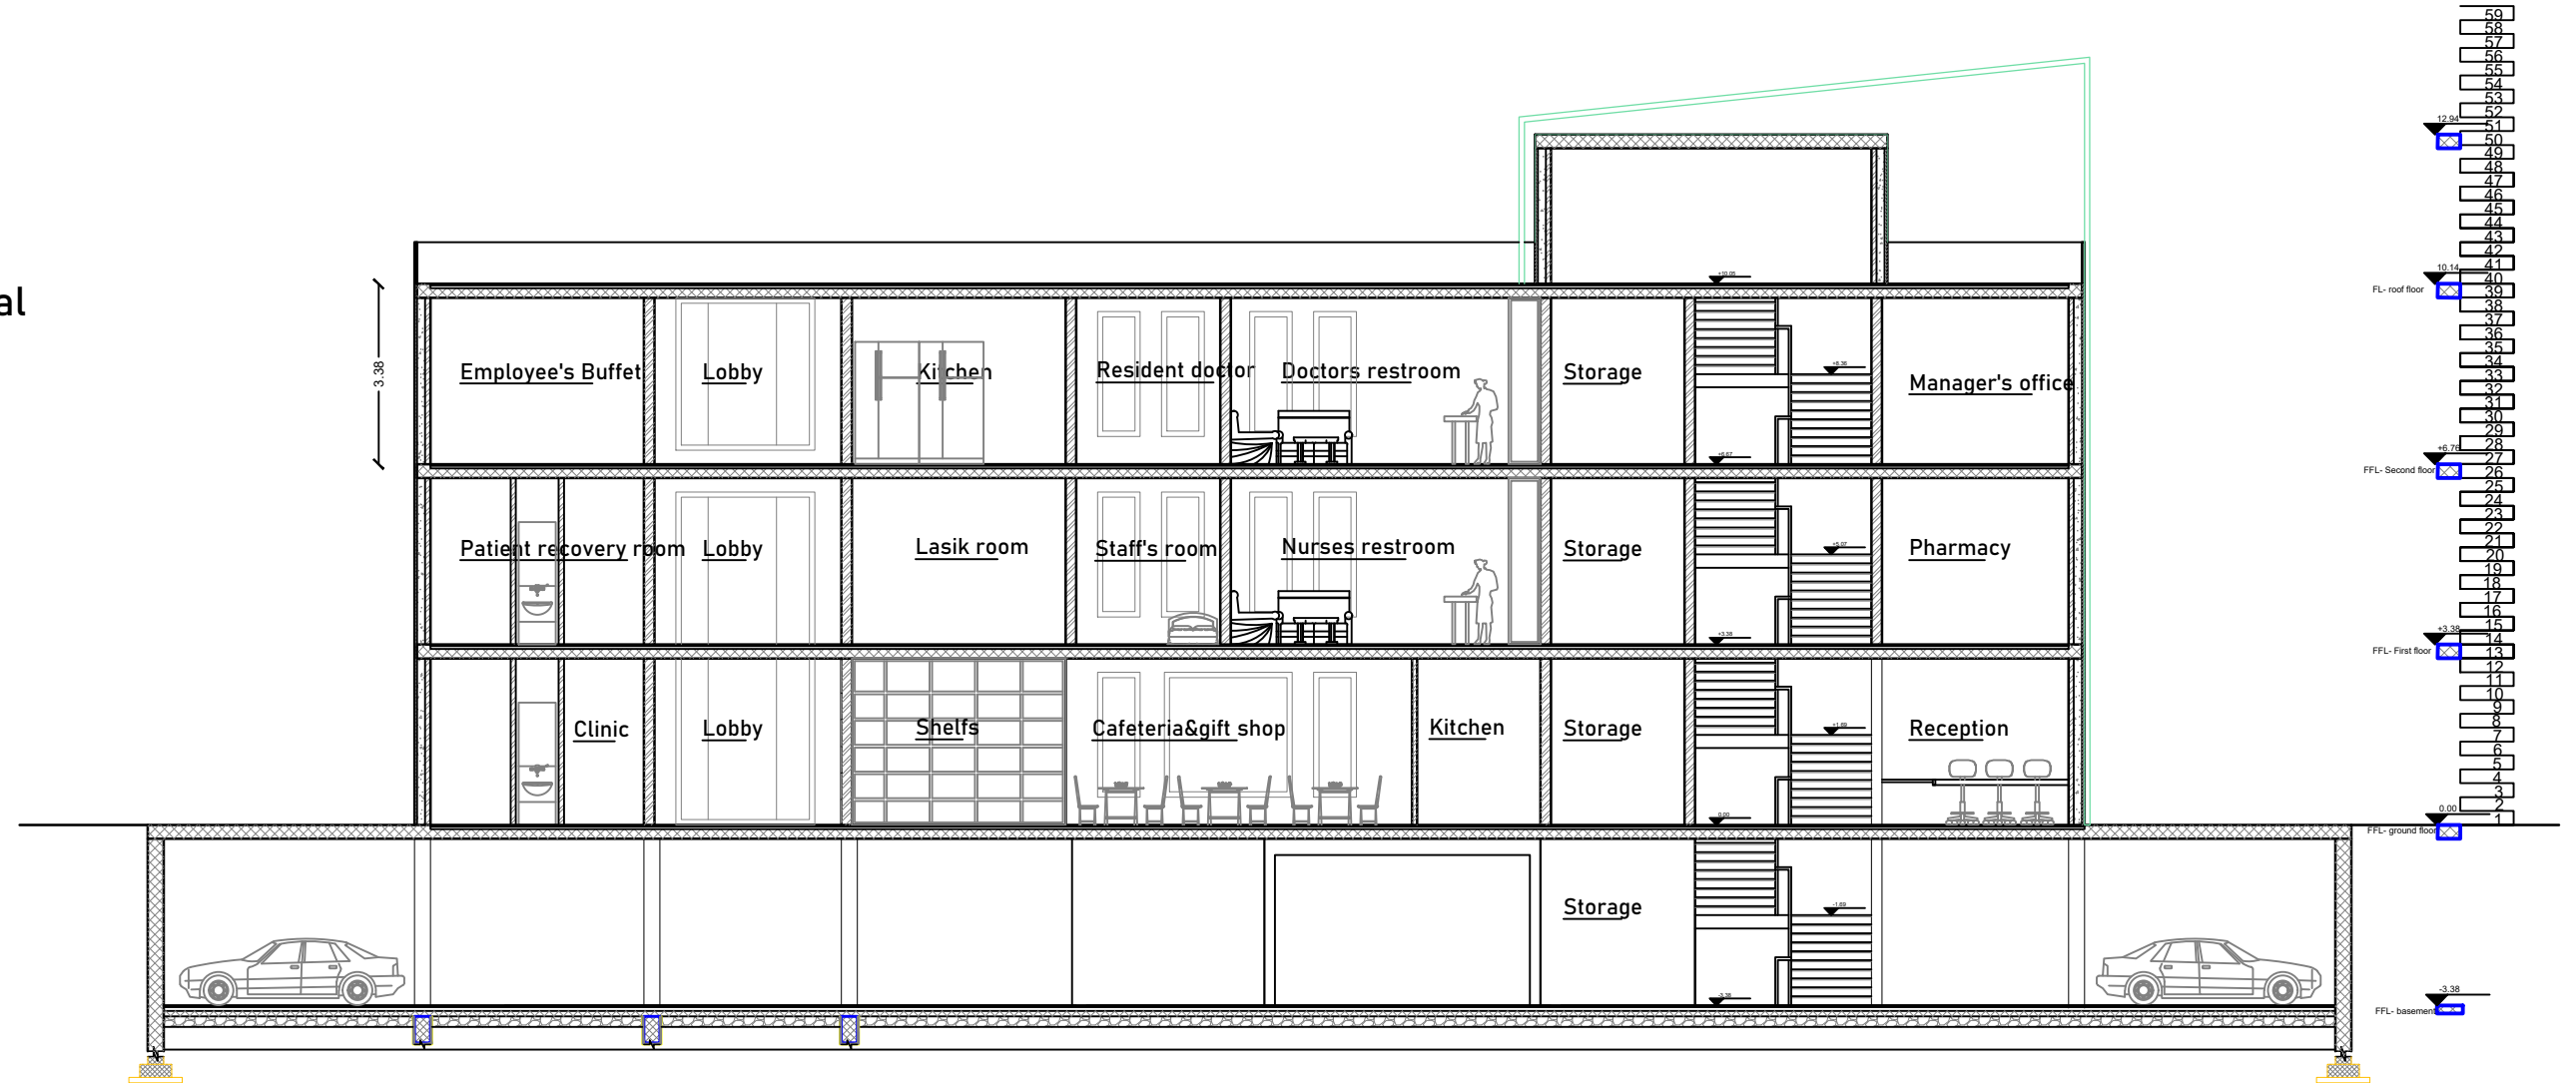

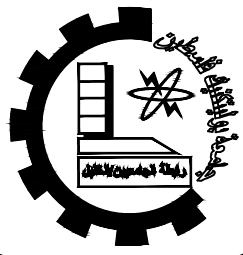

Palestine Polytechnic University

Department of Civil Engineering

College of Engineering

Civil Engineering

Design V

Project I

Eye-specialist Hospital

supervisors:

Dr. Nasr Abboushi  
Design by Roa' Al-jondi

Hamza.haddad  
Mohammad abu lawi

Drawing Symbol


 
S00

Drawing Tittle


COLUMN LAYOUT  
PLAN

scale

1:100

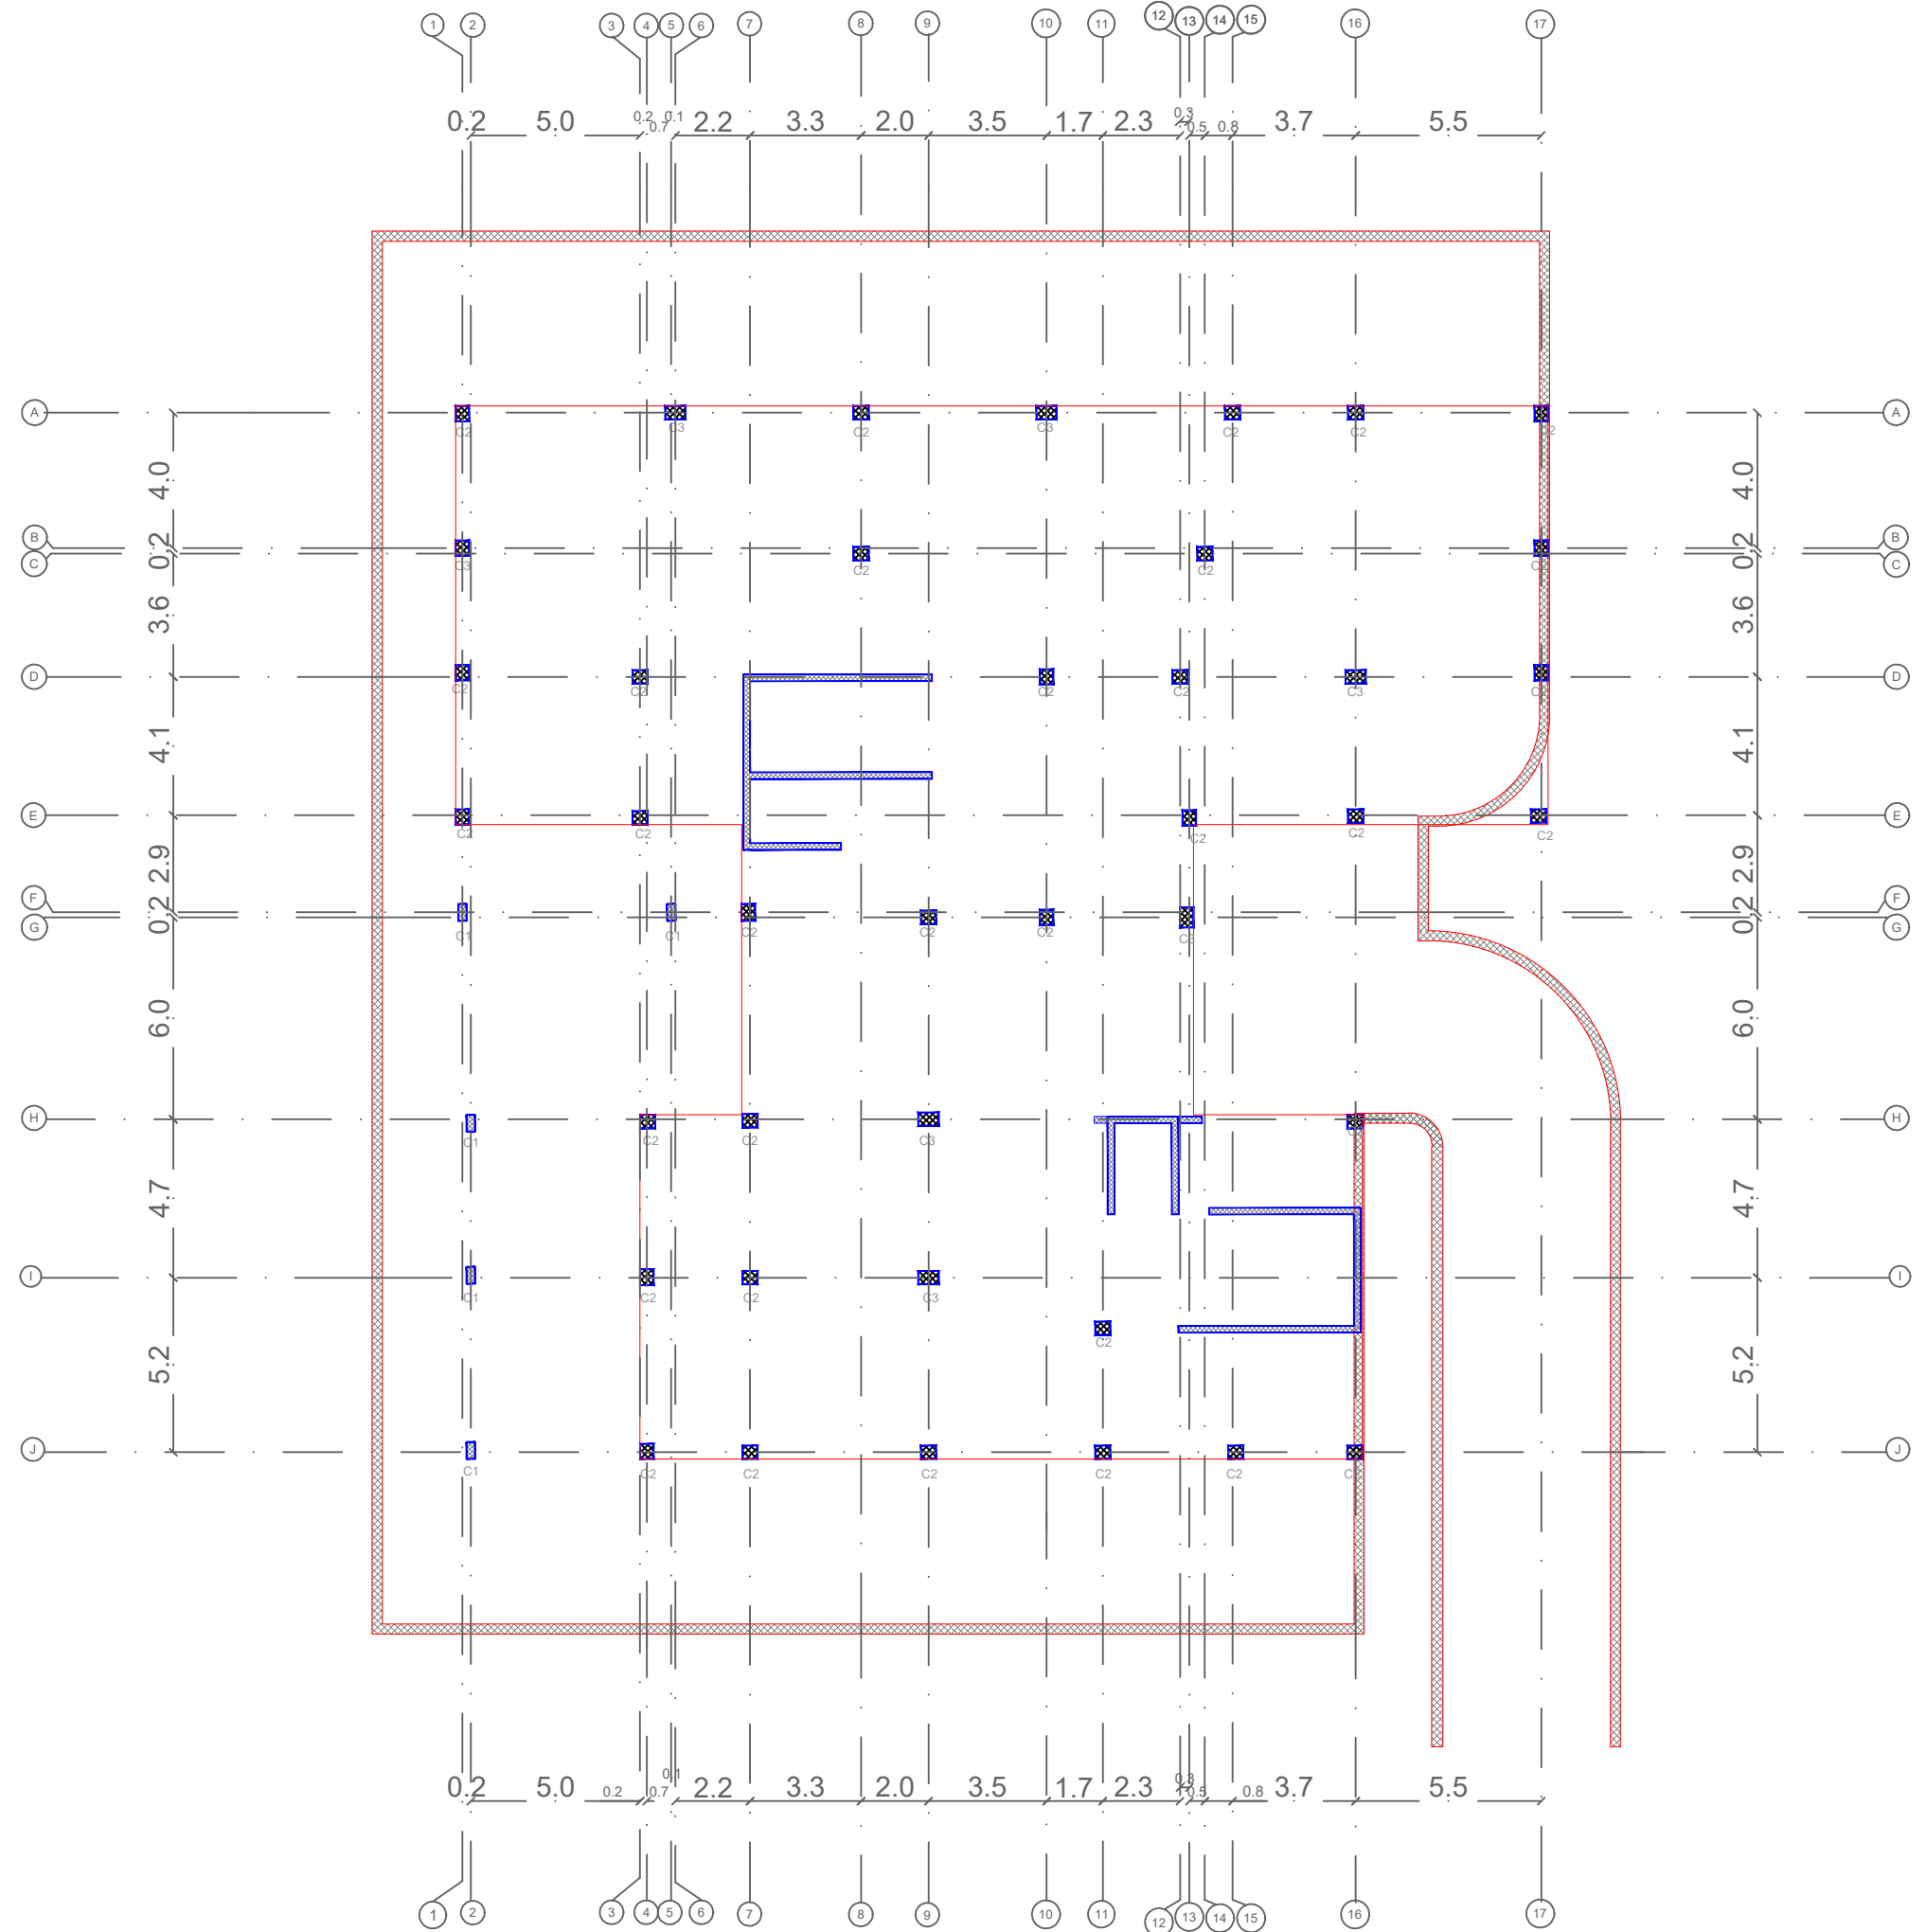



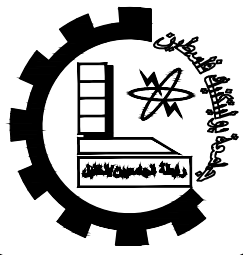

Palestine Polytechnic University

Department of Civil Engineering

College of Engineering

Civil Engineering

Design V

Project I

Eye-specialist Hospital

supervisors:

Dr. Nasr Abboushi  
Design by Roa' Al-jondi

Hamza.haddad  
Mohammad abu lawi

Drawing Symbol


 
S01

Drawing Tittle

FOOTINGS  
LAYOUT PLAN

scale

1:100

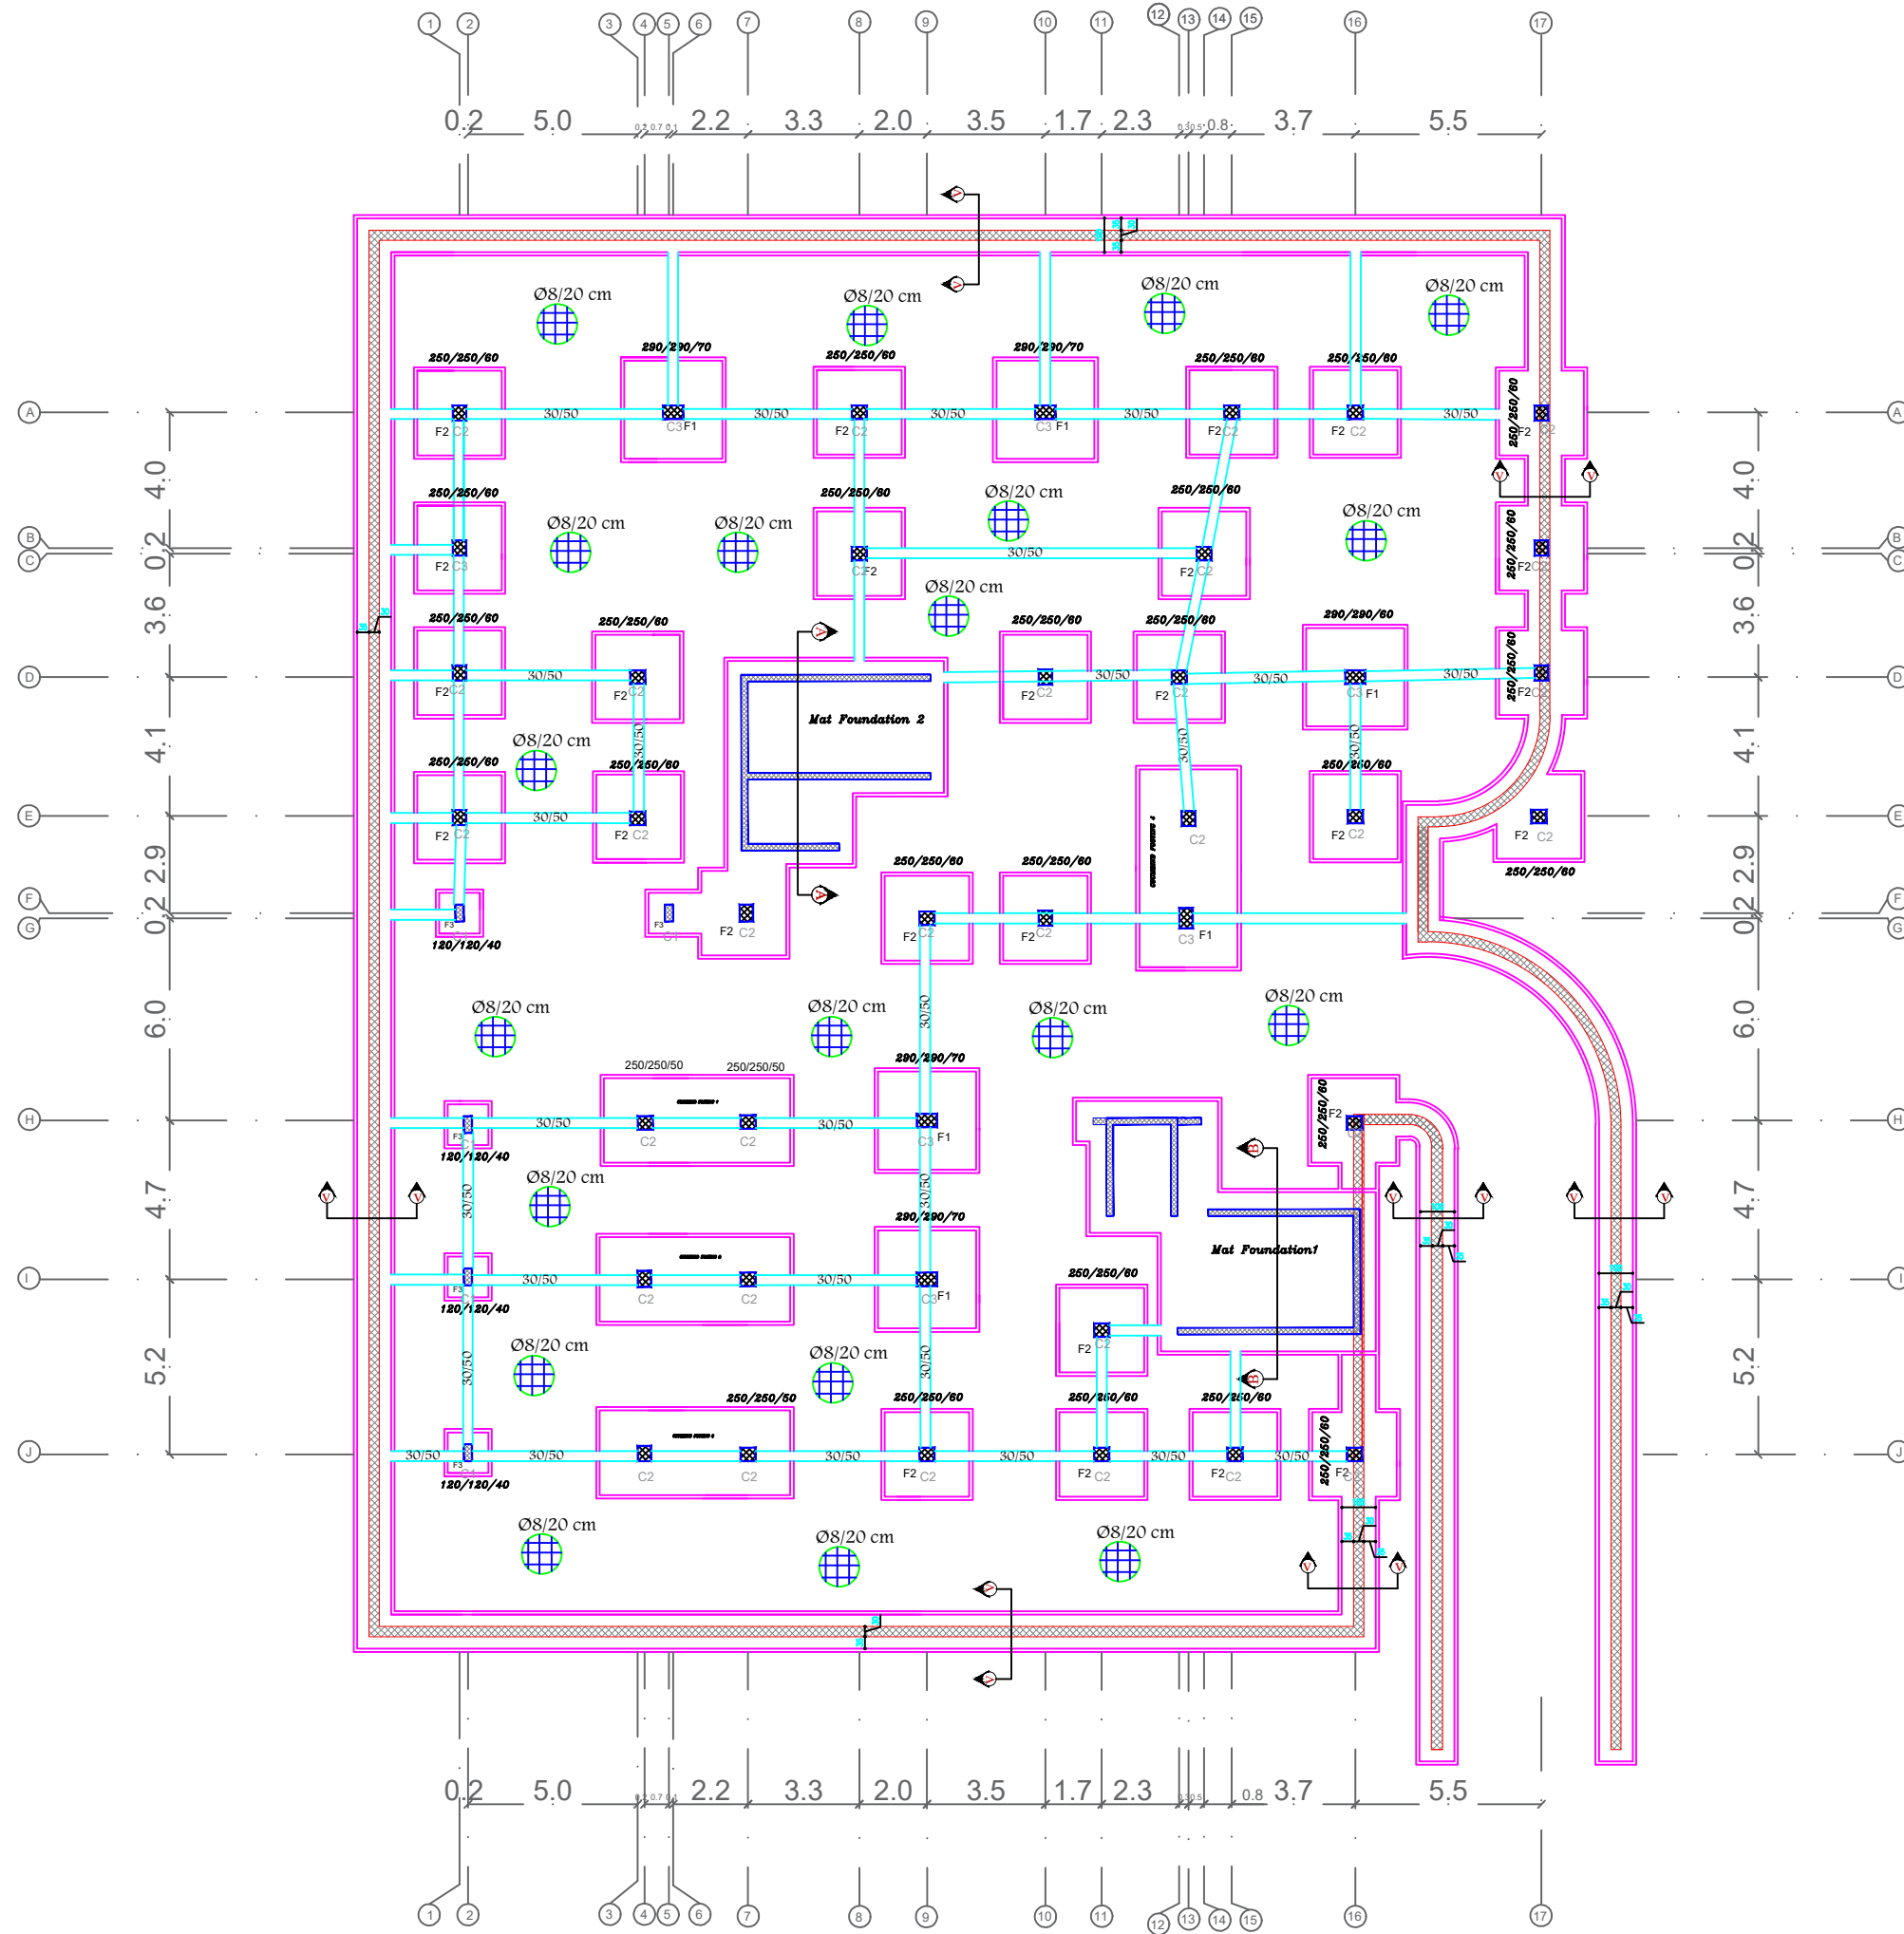



Palestine Polytechnic University

Department of Civil Engineering

College of Engineering

Civil Engineering

Design V

Project I

Eye-specialist Hospital

supervisors:

Dr. Nasr Abboushi  
Design by Roa' Al-jondi

Hamza.haddad  
Mohammad abu lawi

Drawing Symbol

 
S02

Drawing Tittle



FOOTINGS  
DETAILING

scale



1:25




F1(2.90X2.90X0.60)m  
SCALE 1:25

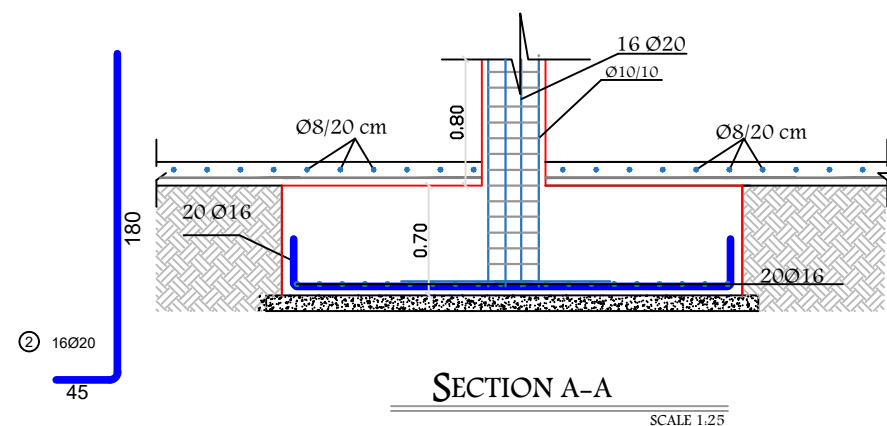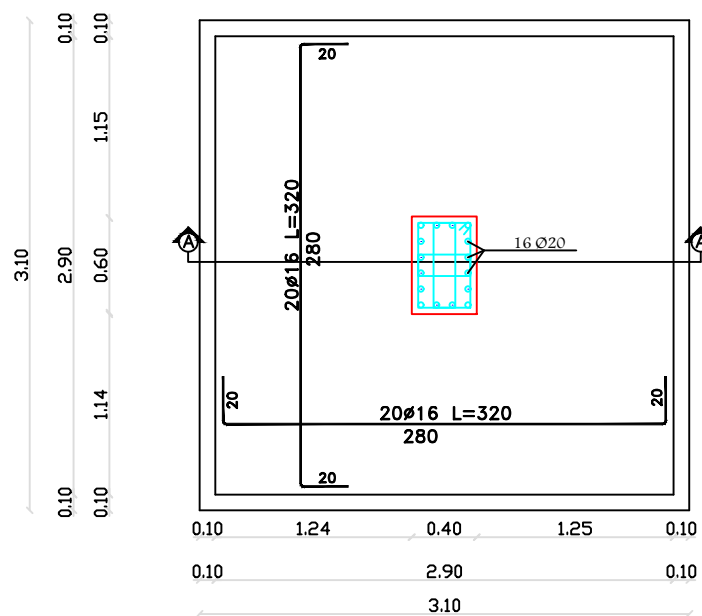

F2(2.50X2.50X0.50)m  
SCALE 1:25

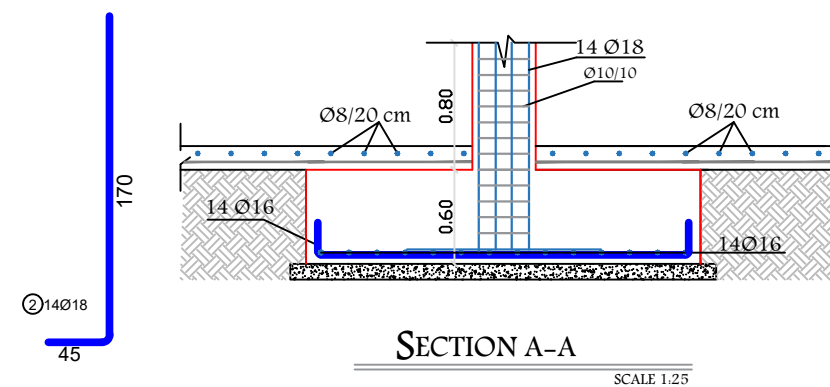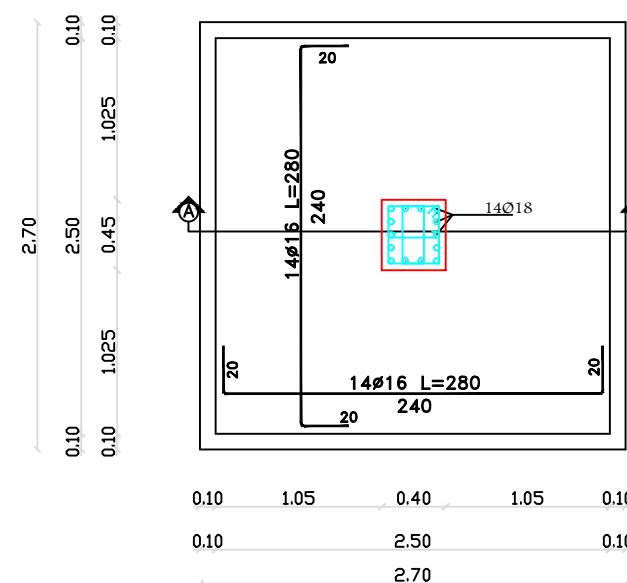

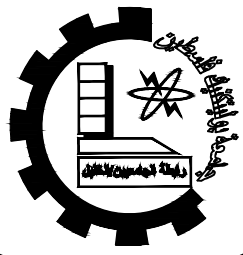

Palestine Polytechnic University

Department of Civil Engineering

College of Engineering

Civil Engineering

Design V

Project I

Eye-specialist Hospital

supervisors:

Dr. Nasr Abboushi  
Design by Roa' Al-jondi

Hamza.haddad  
Mohammad abu lawi

Drawing Symbol

 
S03

Drawing Tittle

FOOTINGS  
DETAILING



scale

1:25




# F3(1.20X1.20X0.40)m

## SCALE 1:25

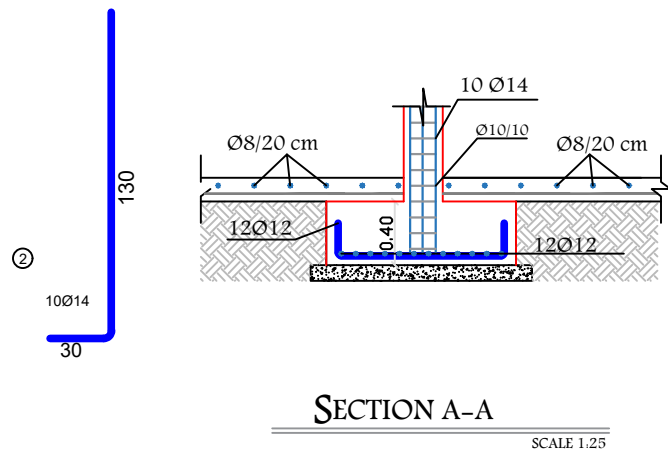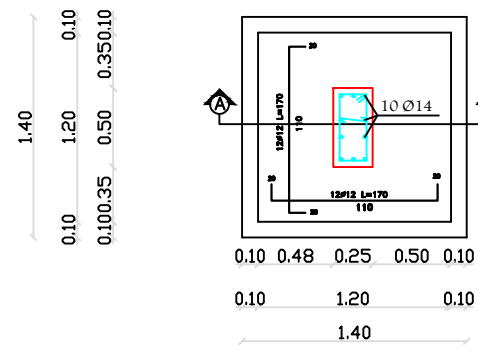


# COUMBIND FOOTING 1


## SCALE 1:25

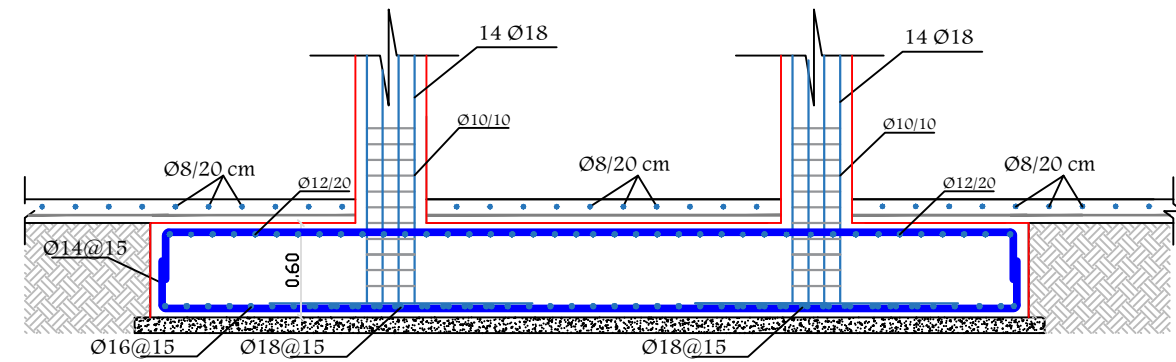

SECTION A-A

SCALE 1:25

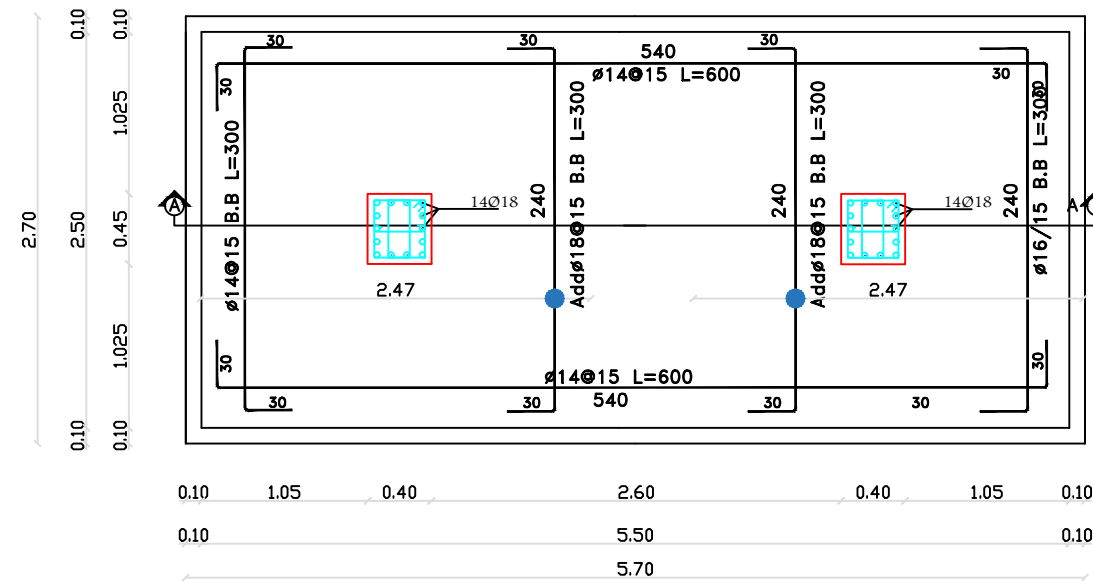

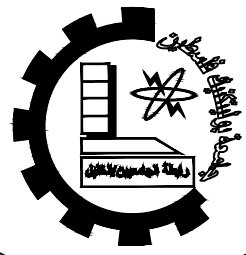

Palestine Polytechnic University

Department of Civil Engineering

College of Engineering

Civil Engineering

Design V

Project I

Eye-specialist Hospital

supervisors:

Dr. Nasr Abboushi  
Design by Roa' Al-jondi

Hamza.haddad  
Mohammad abu lawi

Drawing Symbol

 
S04

Drawing Tittle

FOOTINGS  
DETAILING


scale

1:25




# COUMBIND FOOTING 2


## SCALE 1:25

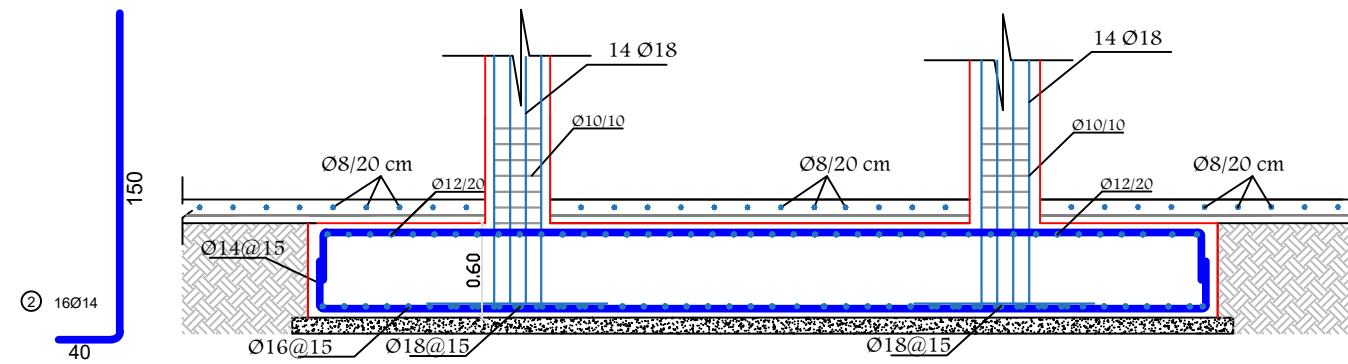

SECTION A-A

SCALE 1:25

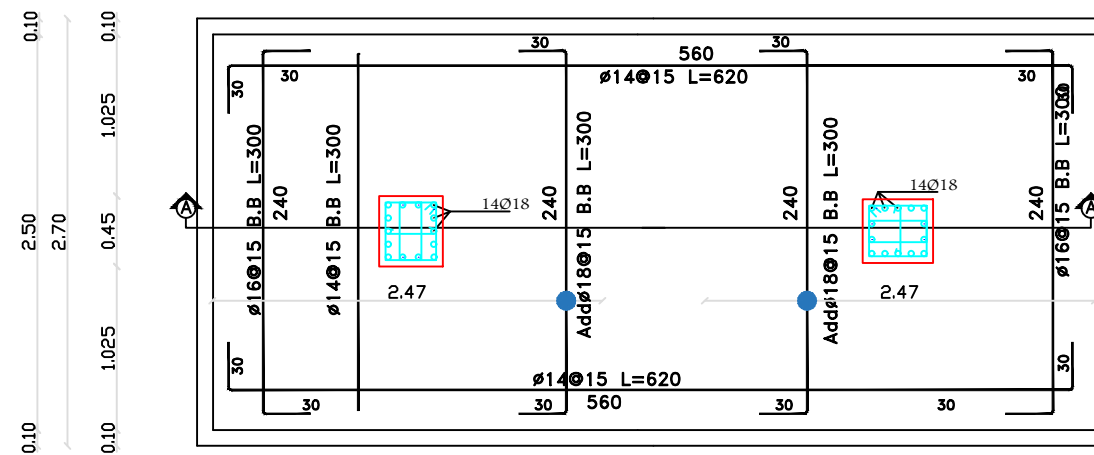

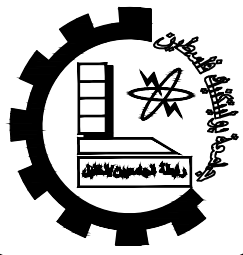

Palestine Polytechnic University

Department of Civil Engineering

College of Engineering

Civil Engineering

Design V

Project I

Eye-specialist Hospital

supervisors:

Dr. Nasr Abboushi  
Design by Roa' Al-jondi

Hamza.haddad  
Mohammad abu lawi

Drawing Symbol

 
S05

Drawing Tittle

FOOTINGS  
DETAILING


scale

1:25





# COUMBIND FOOTING 3


## SCALE 1:25

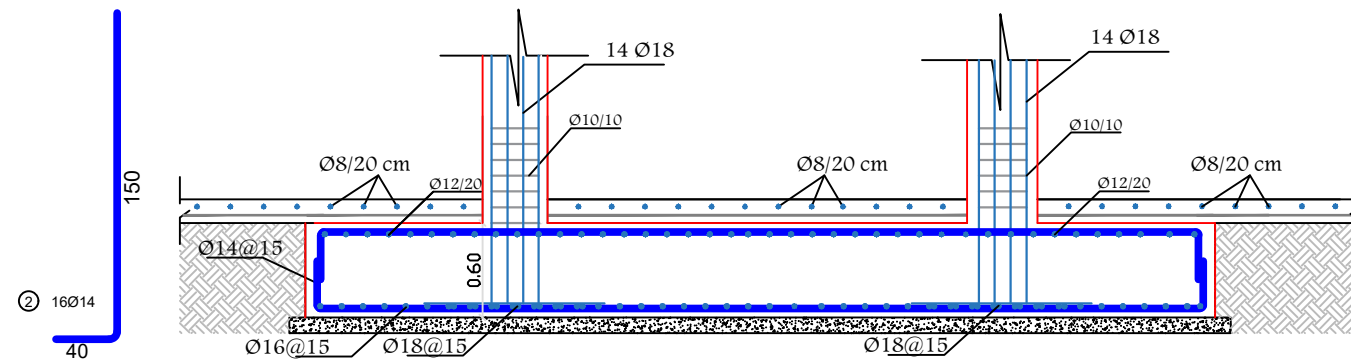

SECTION A-A

SCALE 1:25

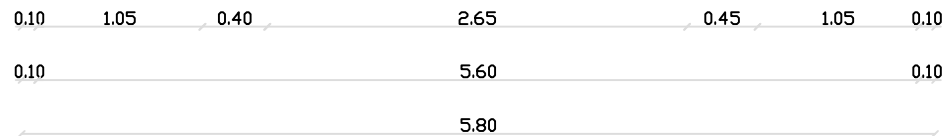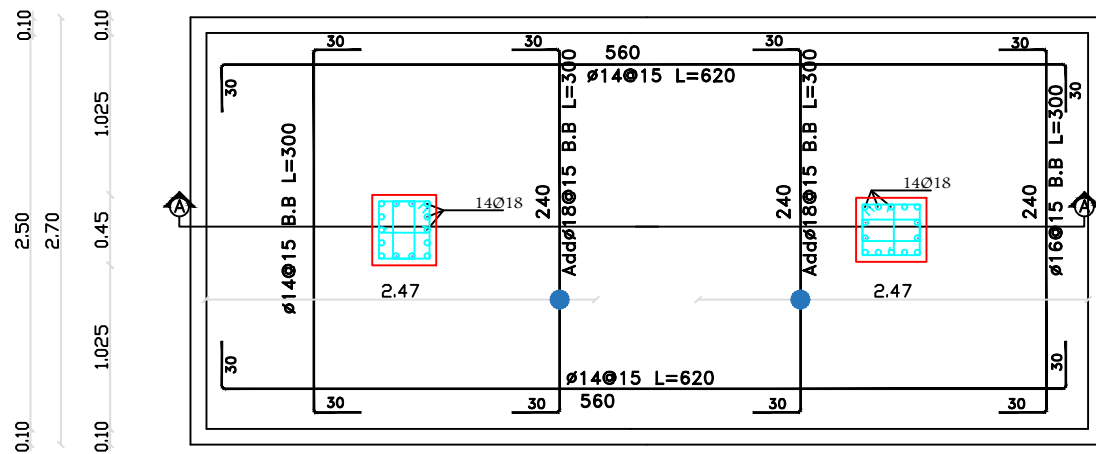

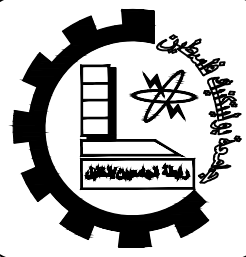

Palestine Polytechnic University  
 Department of Civil Engineering  
 College of Engineering  
 Civil Engineering

Design V  
 Project I

Eye-specialist Hospital

supervisors:

Dr. Nasr Abboushi  
 Design by Roa' Al-jondi  
 Hamza.haddad  
 Mohammad abu lawi

Drawing Symbol

 
S06

Drawing Tittle

FOOTINGS  
 DETAILING



scale

1:25




# COUMBIND FOOTING 4

## SCALE 1:25

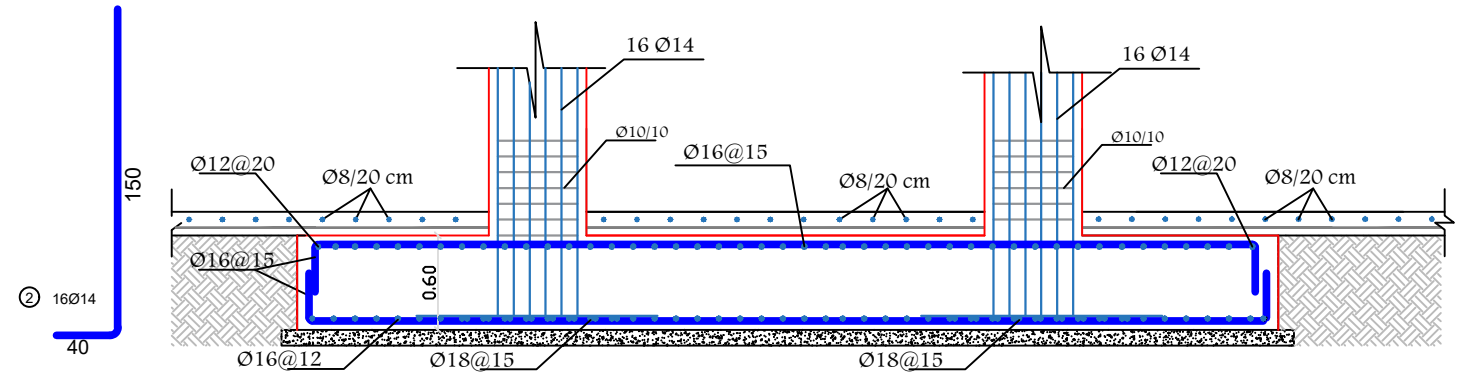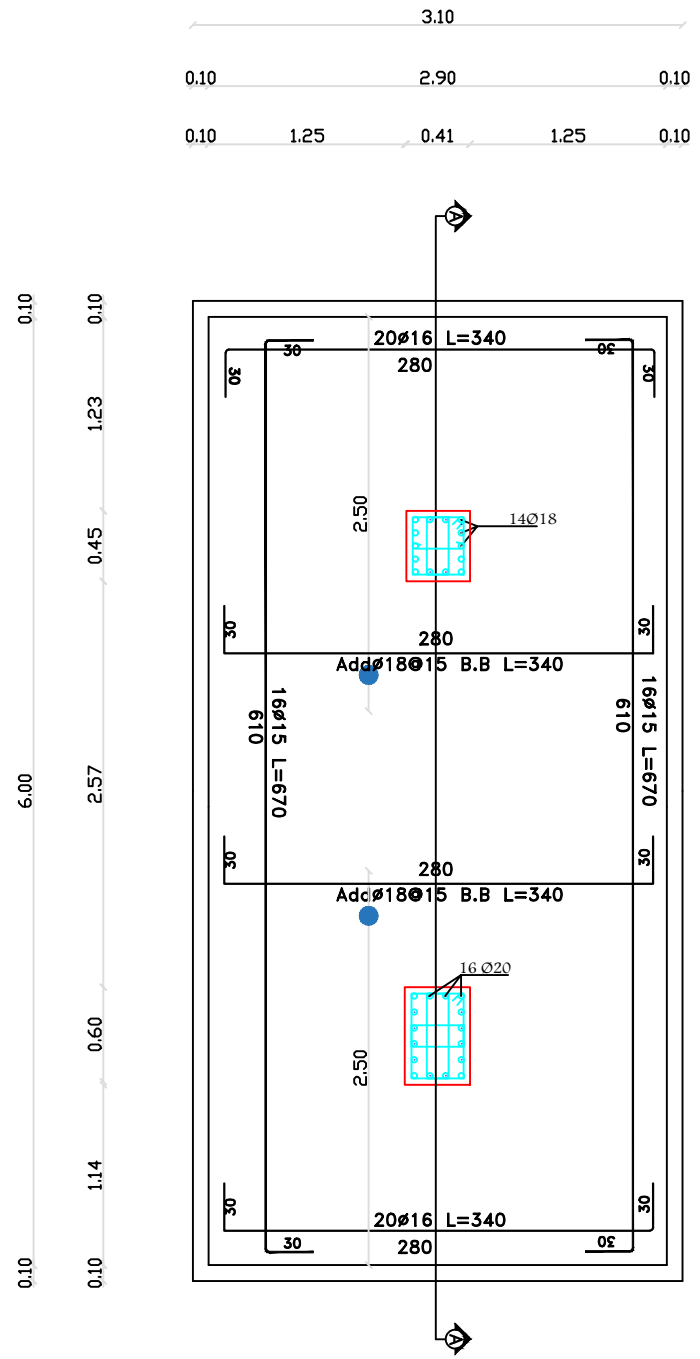



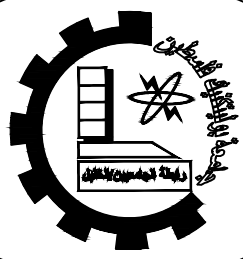

Palestine Polytechnic University

Department of Civil Engineering

College of Engineering

Civil Engineering

Design V

Project I

Eye-specialist Hospital

supervisors:

Dr. Nasr Abboushi  
Design by Roa' Al-jondi

Hamza.haddad  
Mohammad abu lawi

Drawing Symbol

 
S07

Drawing Tittle



FOOTINGS  
DETAILING

scale



1:25  
1:10



Mat Foundation1  
SCALE 1:25

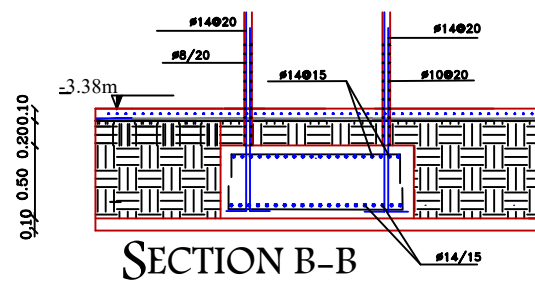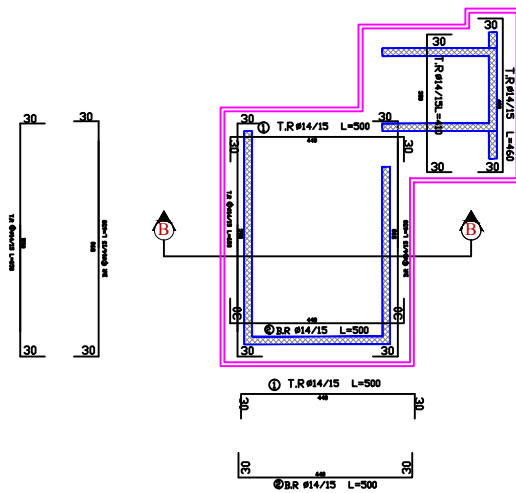



Mat Foundation2  
SCALE 1:25

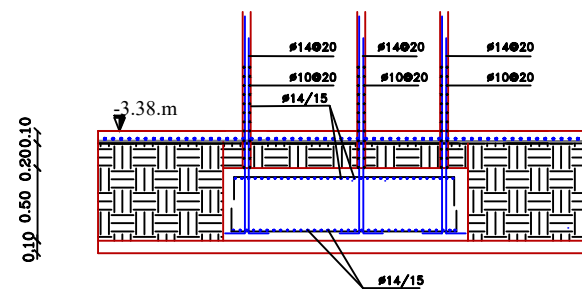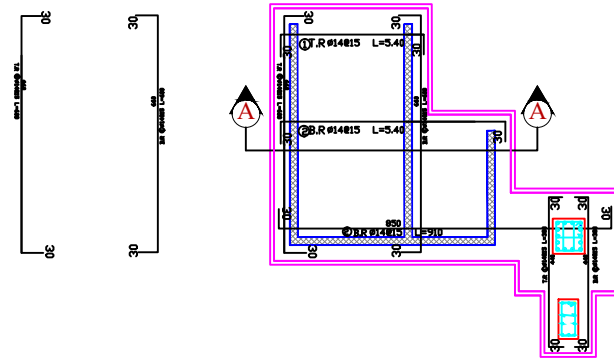

SECTION A-A

Strip FOOTING  
SCALE 1:10

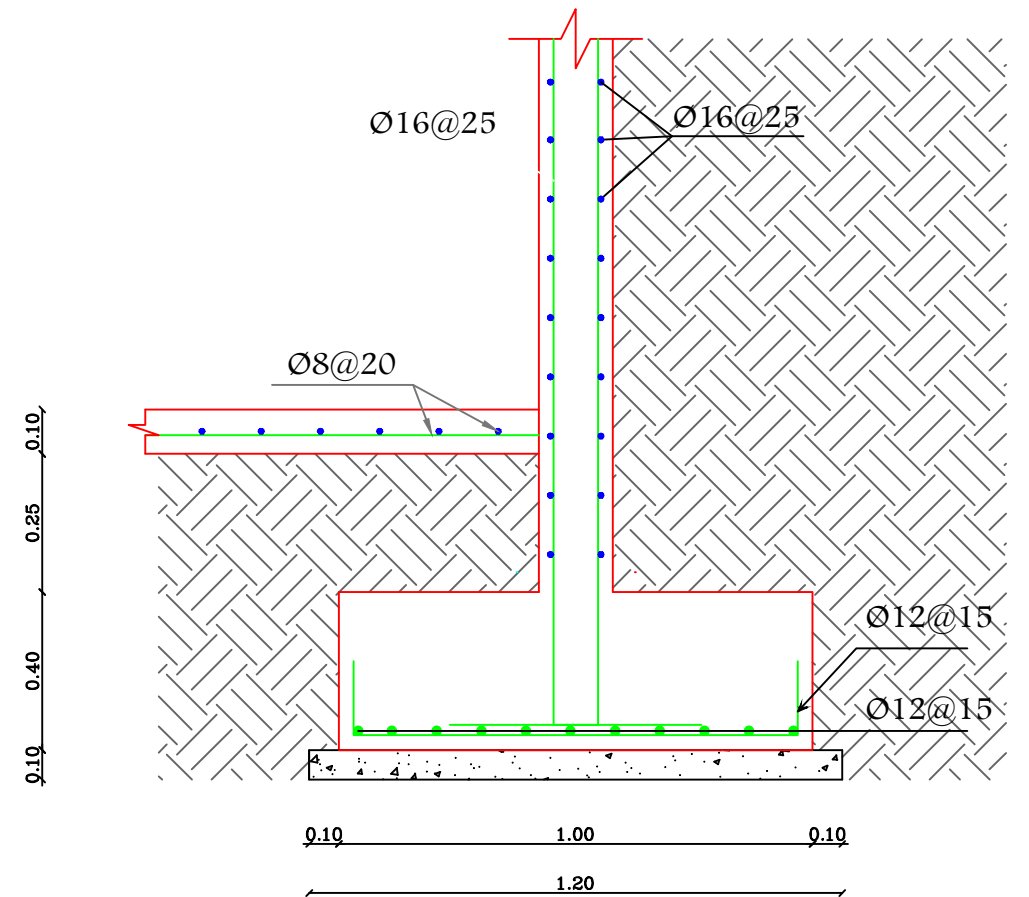

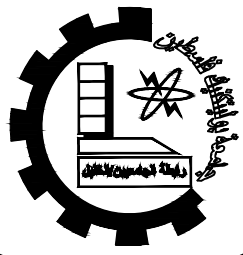

Palestine Polytechnic University

Department of Civil Engineering

College of Engineering

Civil Engineering

Design V

Project I

Eye-specialist Hospital

supervisors:

Dr. Nasr Abboushi  
Design by Roa' Al-jondi

Hamza.haddad  
Mohammad abu lawi

Drawing Symbol

 
S08

Drawing Tittle

Columns  
Groups










scale


1:50



# Column's Design Sections

         SCALE 1:50

Floor	Groups		
	G 1	G 2	G 3
	C 1	C 2	C 3
BF	 10Ø14	 14Ø18	 16Ø20
GF	 14Ø16	 16Ø18	
1 <sup>st</sup> F	 14Ø14	 16Ø16	
2 <sup>nd</sup> F	 14Ø14	 16Ø14	

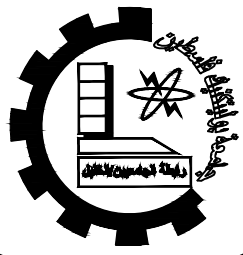

Palestine Polytechnic University

Department of Civil Engineering

College of Engineering

Civil Engineering

Design V

Project I

Eye-specialist Hospital

supervisors:

Dr. Nasr Abboushi  
Design by Roa' Al-jondi

Hamza.haddad  
Mohammad abu lawi

Drawing Symbol

 
S09

Drawing Title


Columns  
Detailing

scale



1:50





Columns detailing's (G1)  
SCALE 1:50

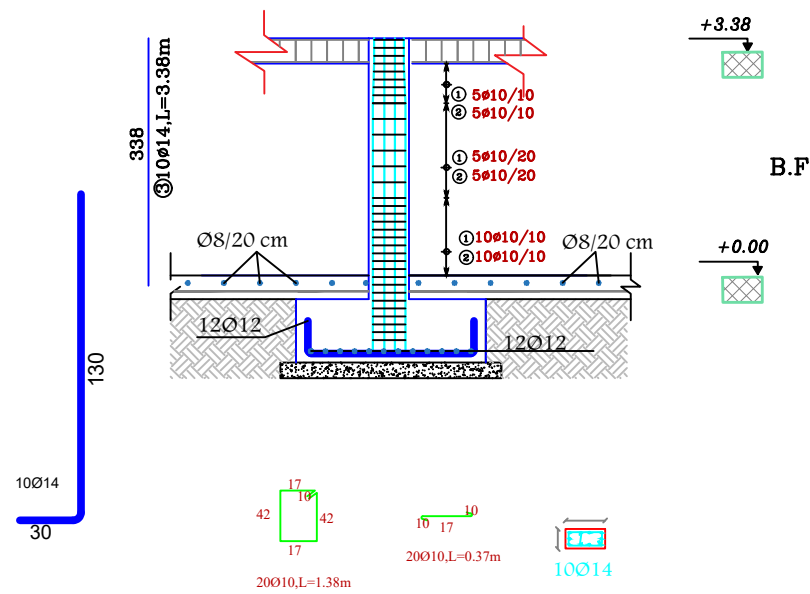


Columns detailing's (G2)  
SCALE 1:50

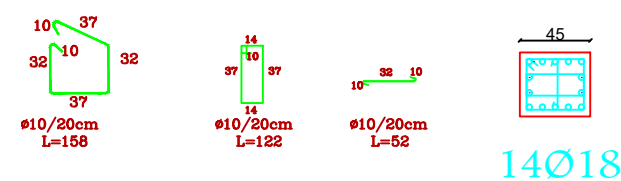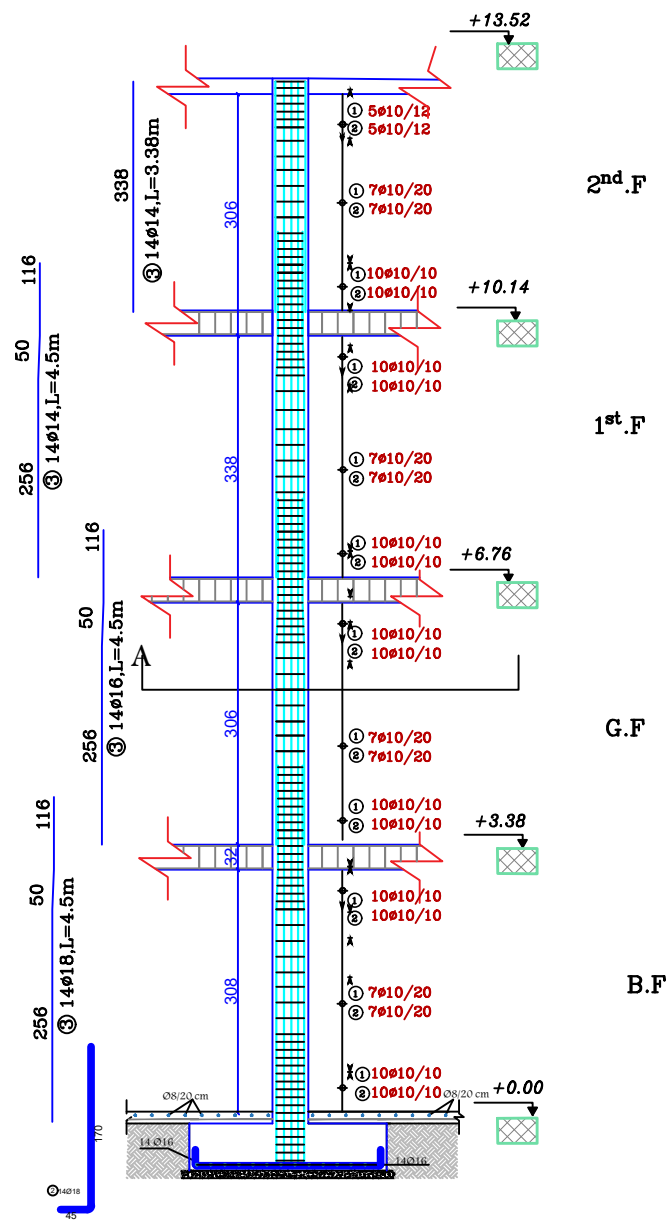

Columns detailing's (G3)  
SCALE 1:50

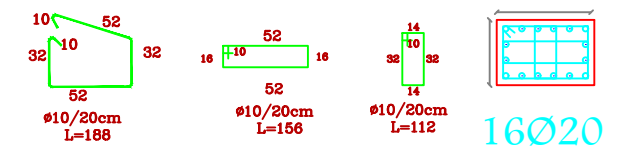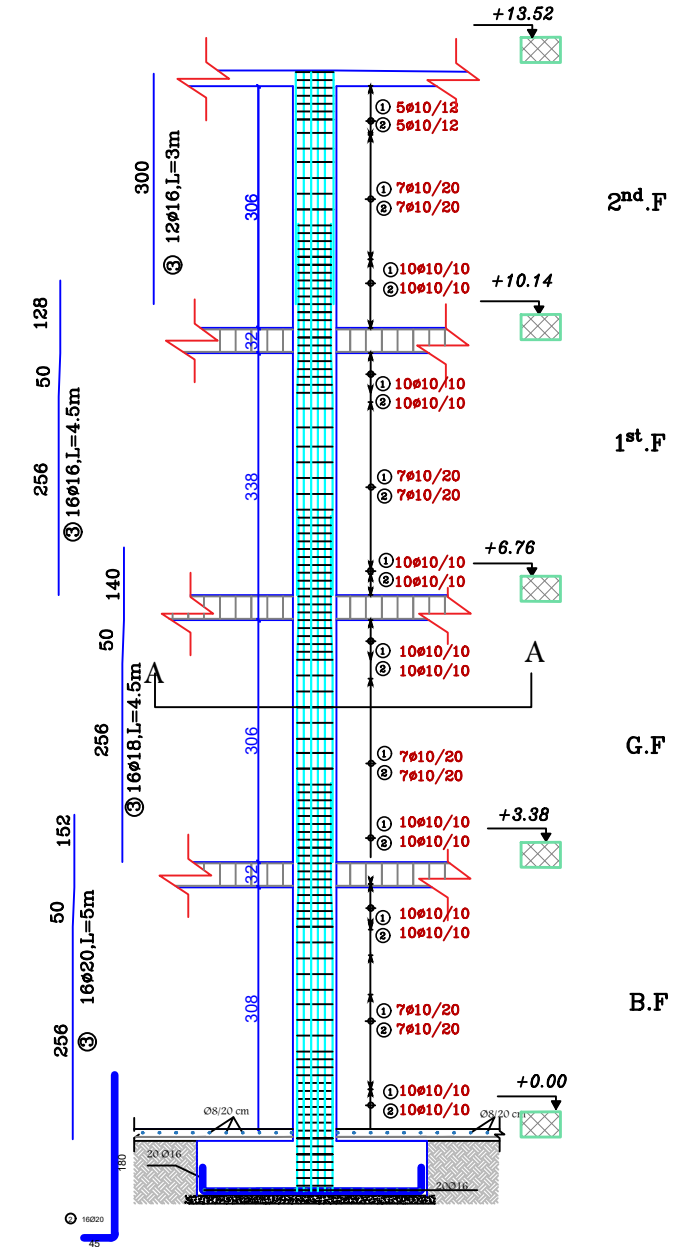

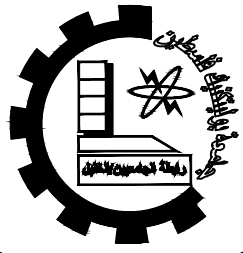

Palestine Polytechnic University

Department of Civil Engineering

College of Engineering

Civil Engineering

Design V

Project I

Eye-specialist Hospital

supervisors:

Dr. Nasr Abboushi  
Design by Roa' Al-jondi

Hamza.haddad  
Mohammad abu lawi

Drawing Symbol


 
S10


Drawing Tittle

BASEMENT SLAB PLAN

scale

1:100

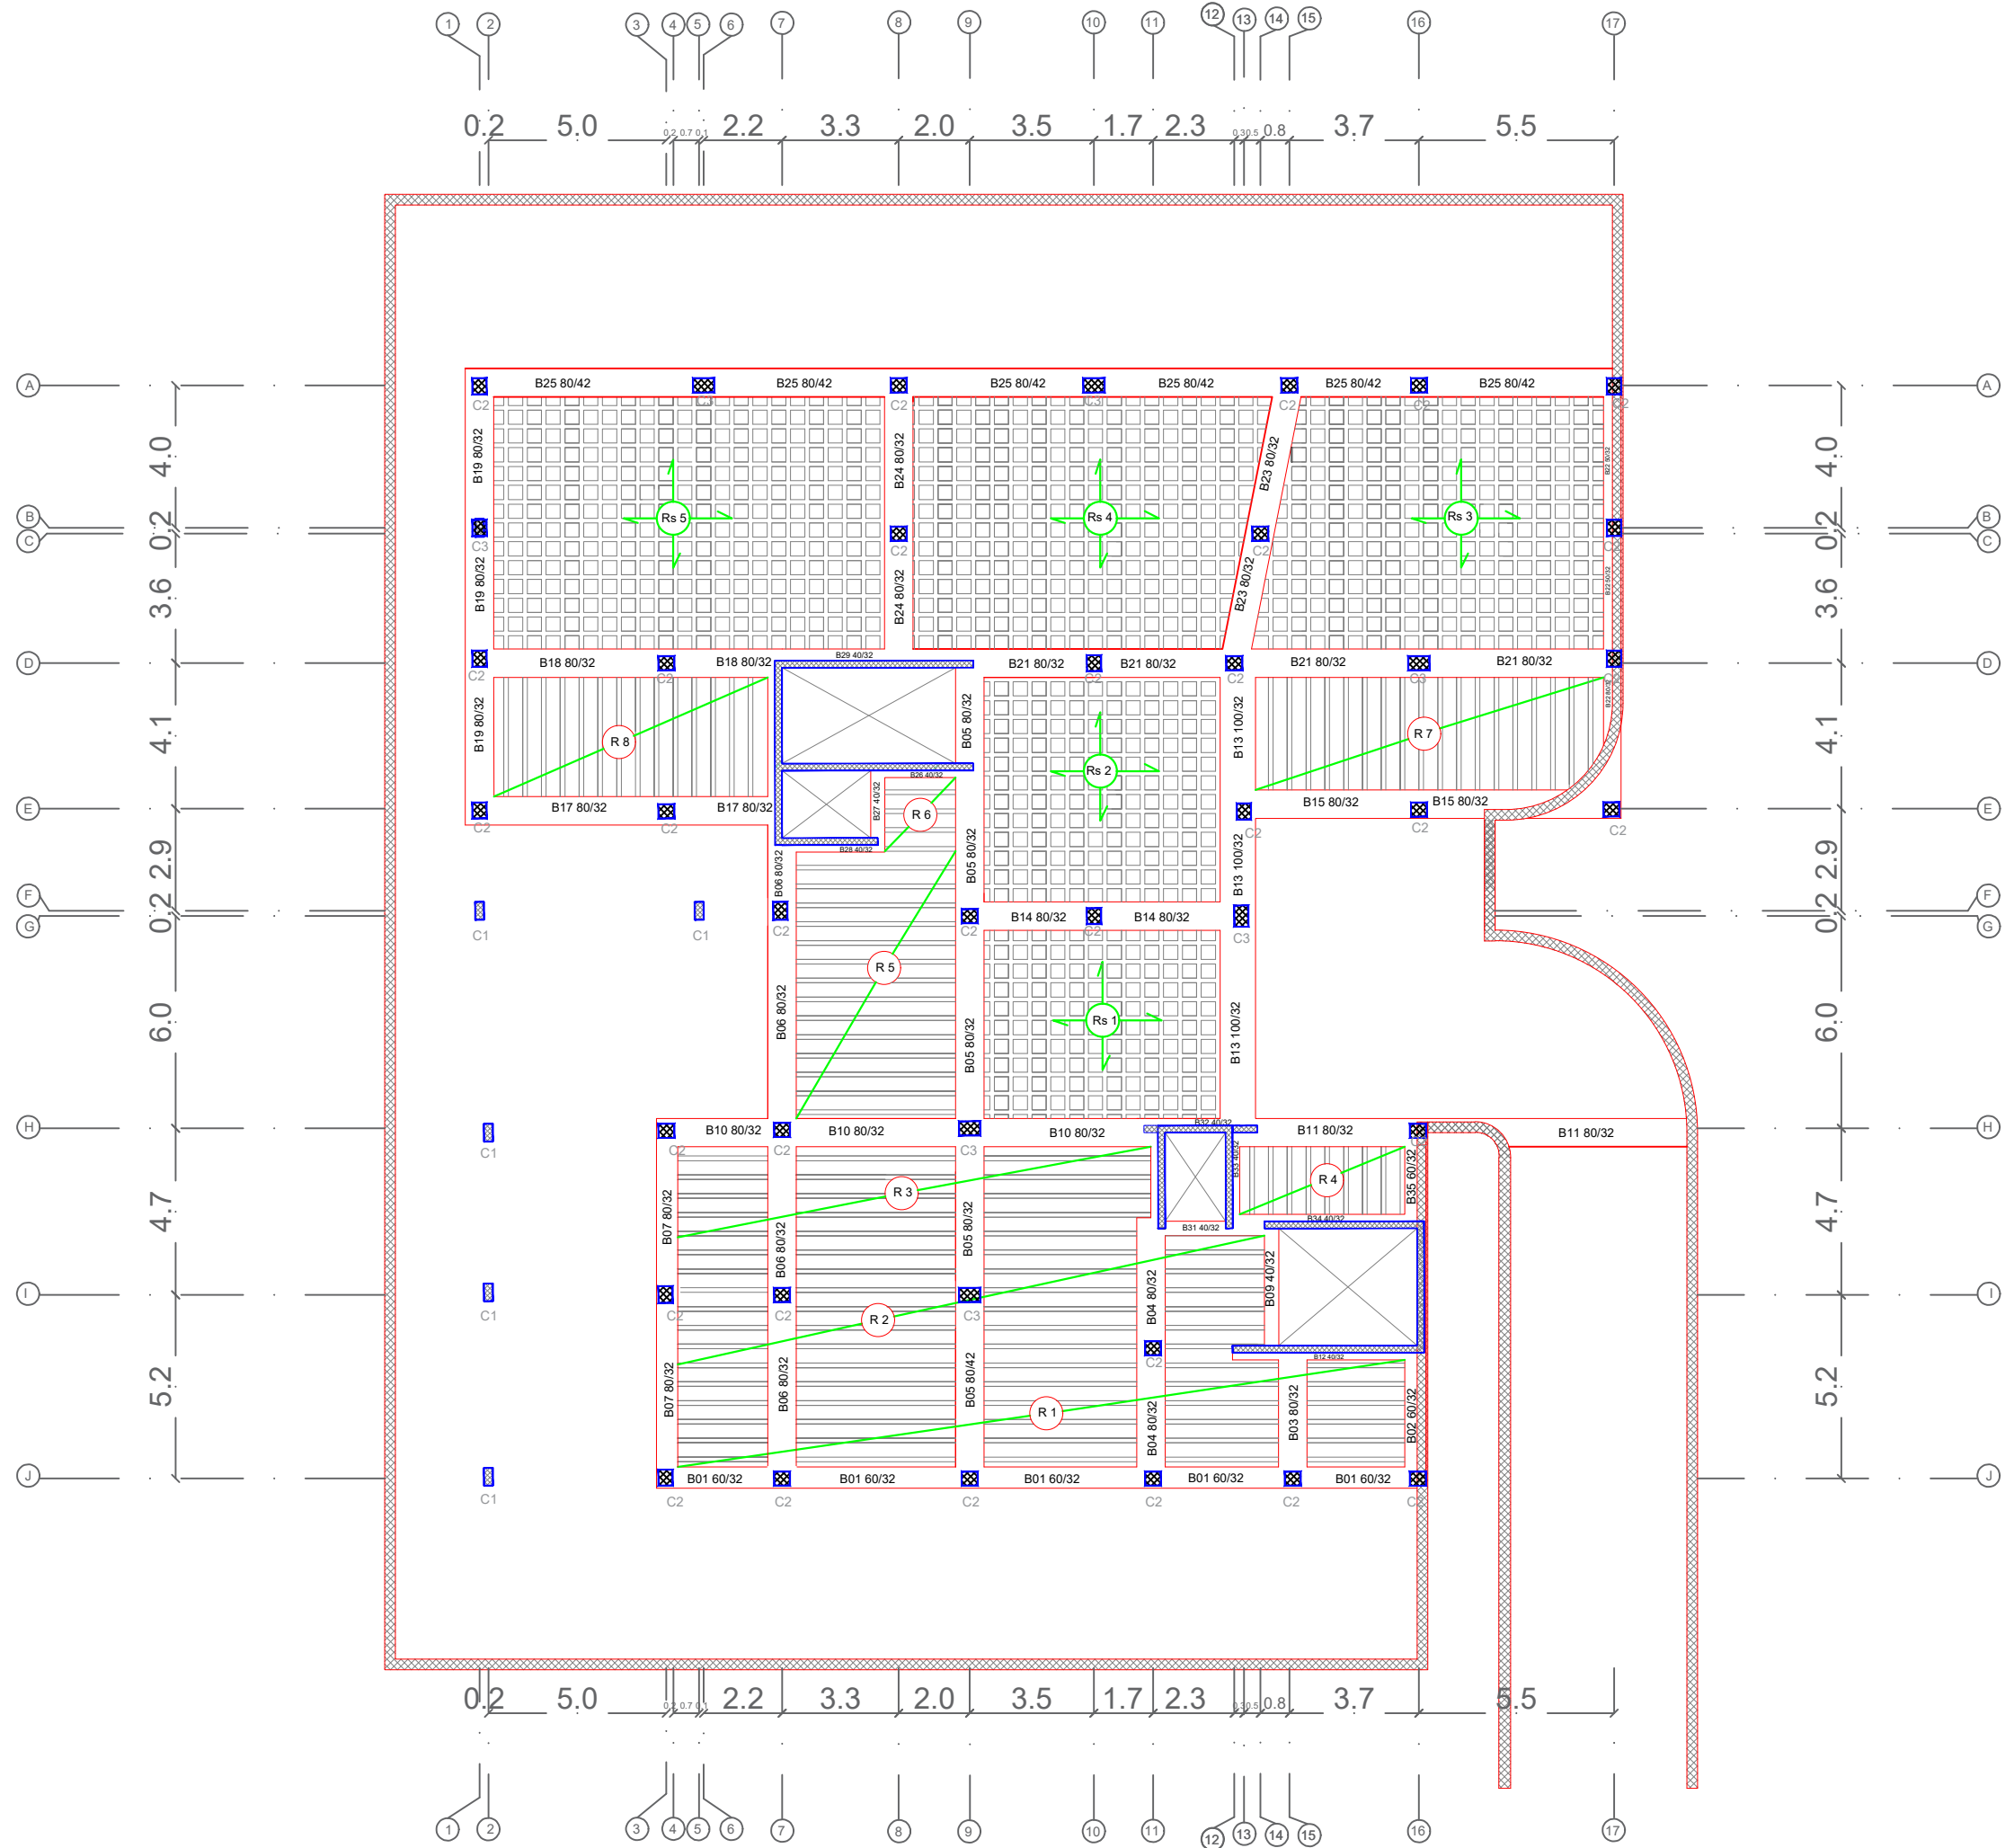

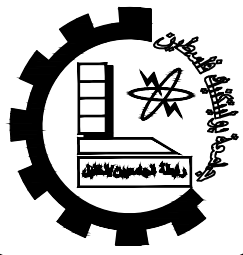

Palestine Polytechnic University

Department of Civil Engineering

College of Engineering

Civil Engineering

Design V

Project I

Eye-specialist Hospital

supervisors:

Dr. Nasr Abboushi  
Design by Roa' Al-jondi

Hamza.haddad  
Mohammad abu lawi

Drawing Symbol


 
S11


Drawing Tittle

GROUND SLAB PLAN

scale

1:100

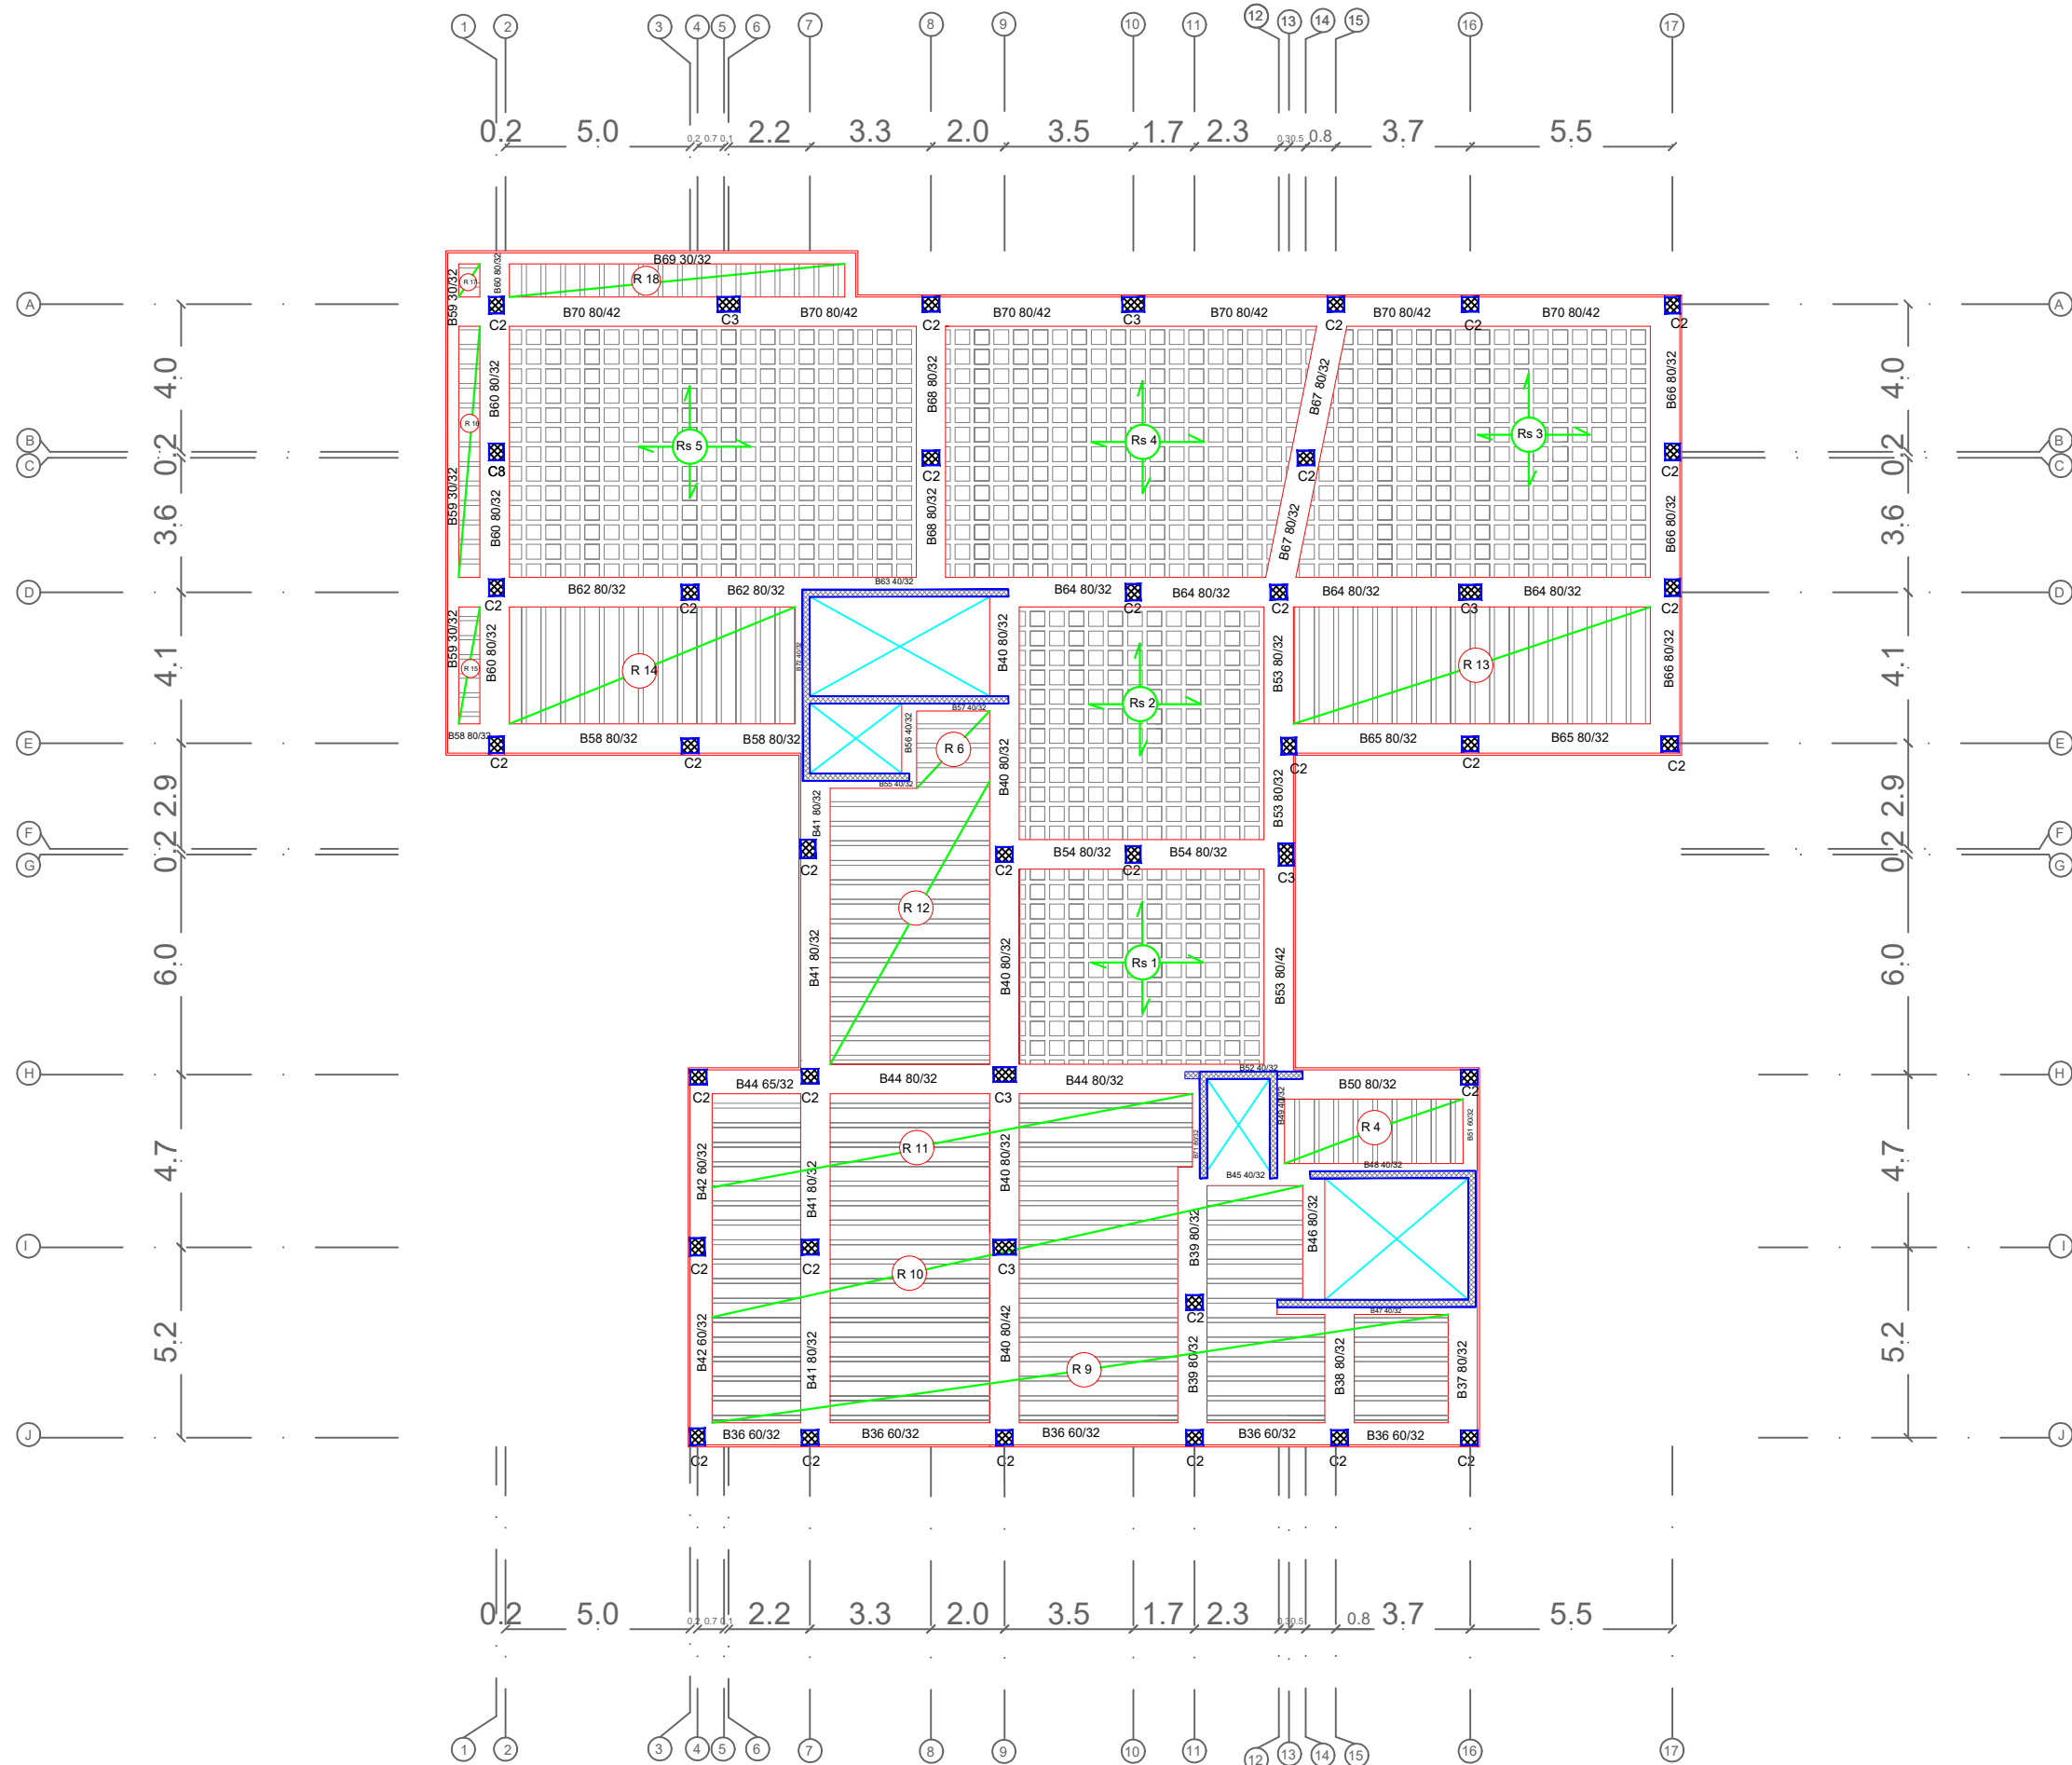

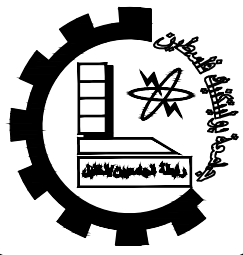

Palestine Polytechnic University

Department of Civil Engineering

College of Engineering

Civil Engineering

Design V

Project I

Eye-specialist Hospital

supervisors:

Dr. Nasr Abboushi  
Design by Roa' Al-jondi

Hamza.haddad  
Mohammad abu lawi

Drawing Symbol


 
S12

Drawing Tittle


FIRST SLAB PLAN

scale

1:100

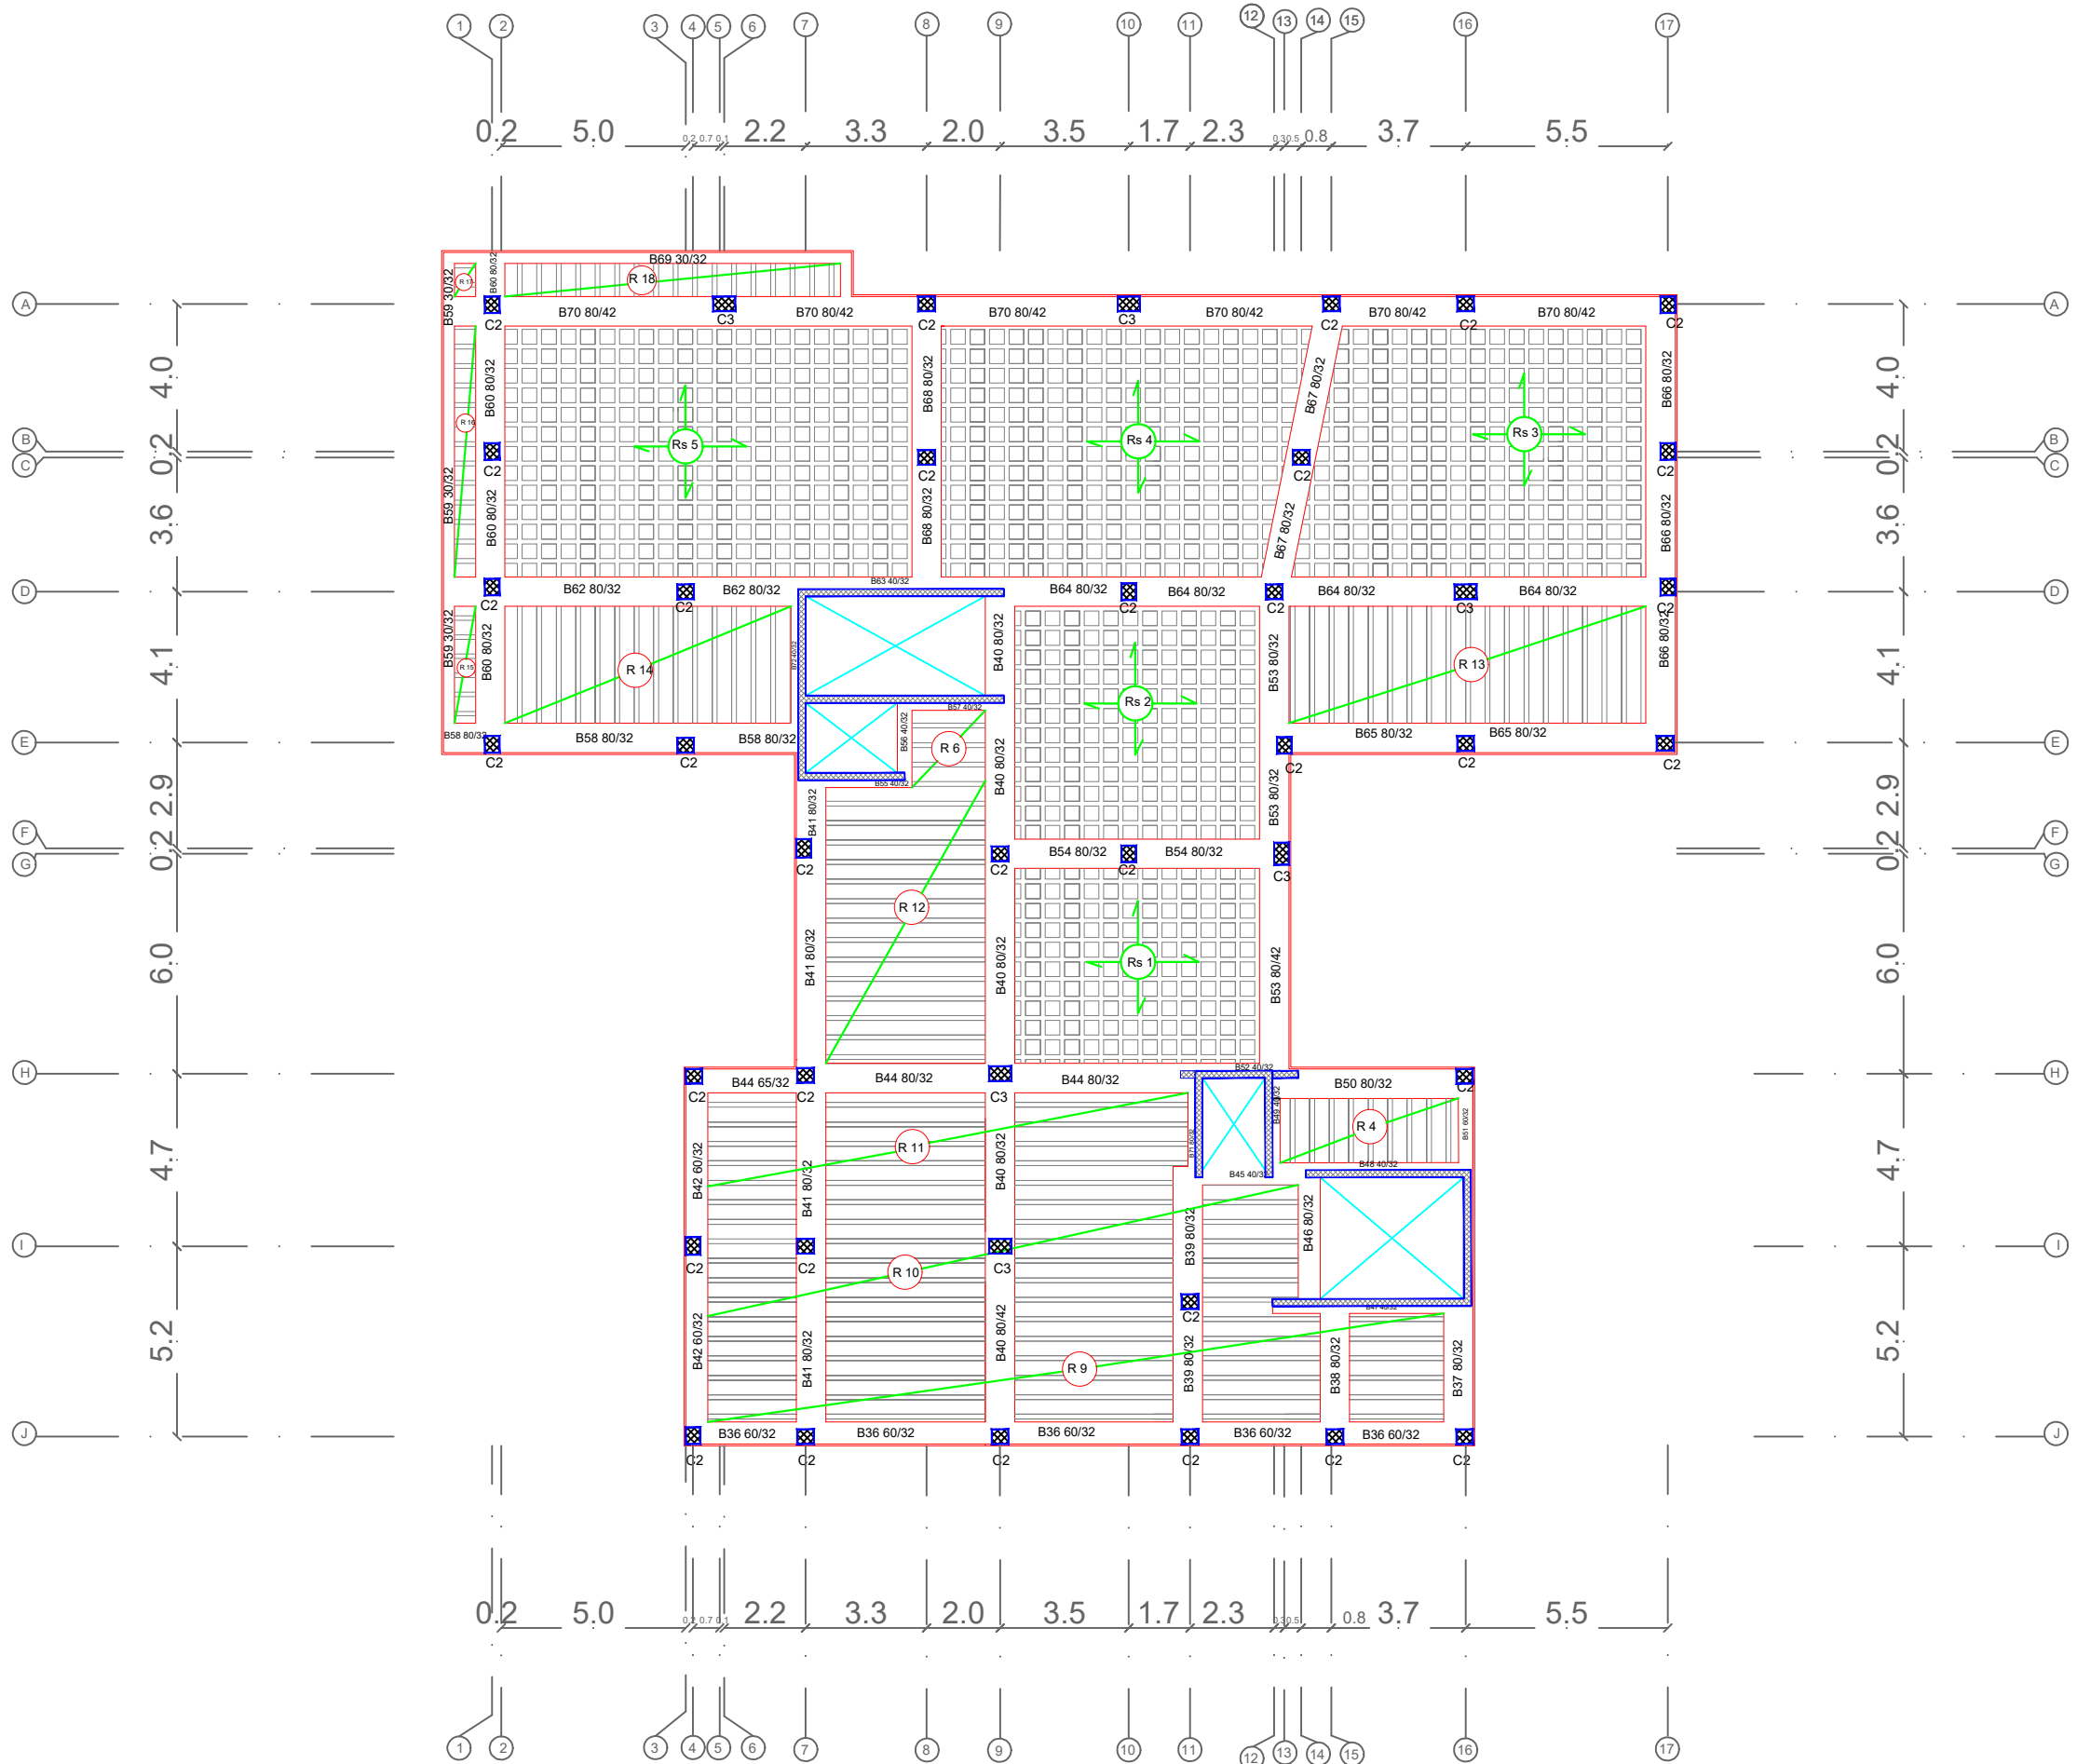



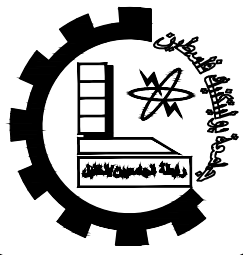

Palestine Polytechnic University

Department of Civil Engineering

College of Engineering

Civil Engineering

Design V

Project I

Eye-specialist Hospital

supervisors:

Dr. Nasr Abboushi  
Design by Roa' Al-jondi

Hamza.haddad  
Mohammad abu lawi

Drawing Symbol


 
S13


Drawing Tittle

Second SLAB PLAN

scale

1:100

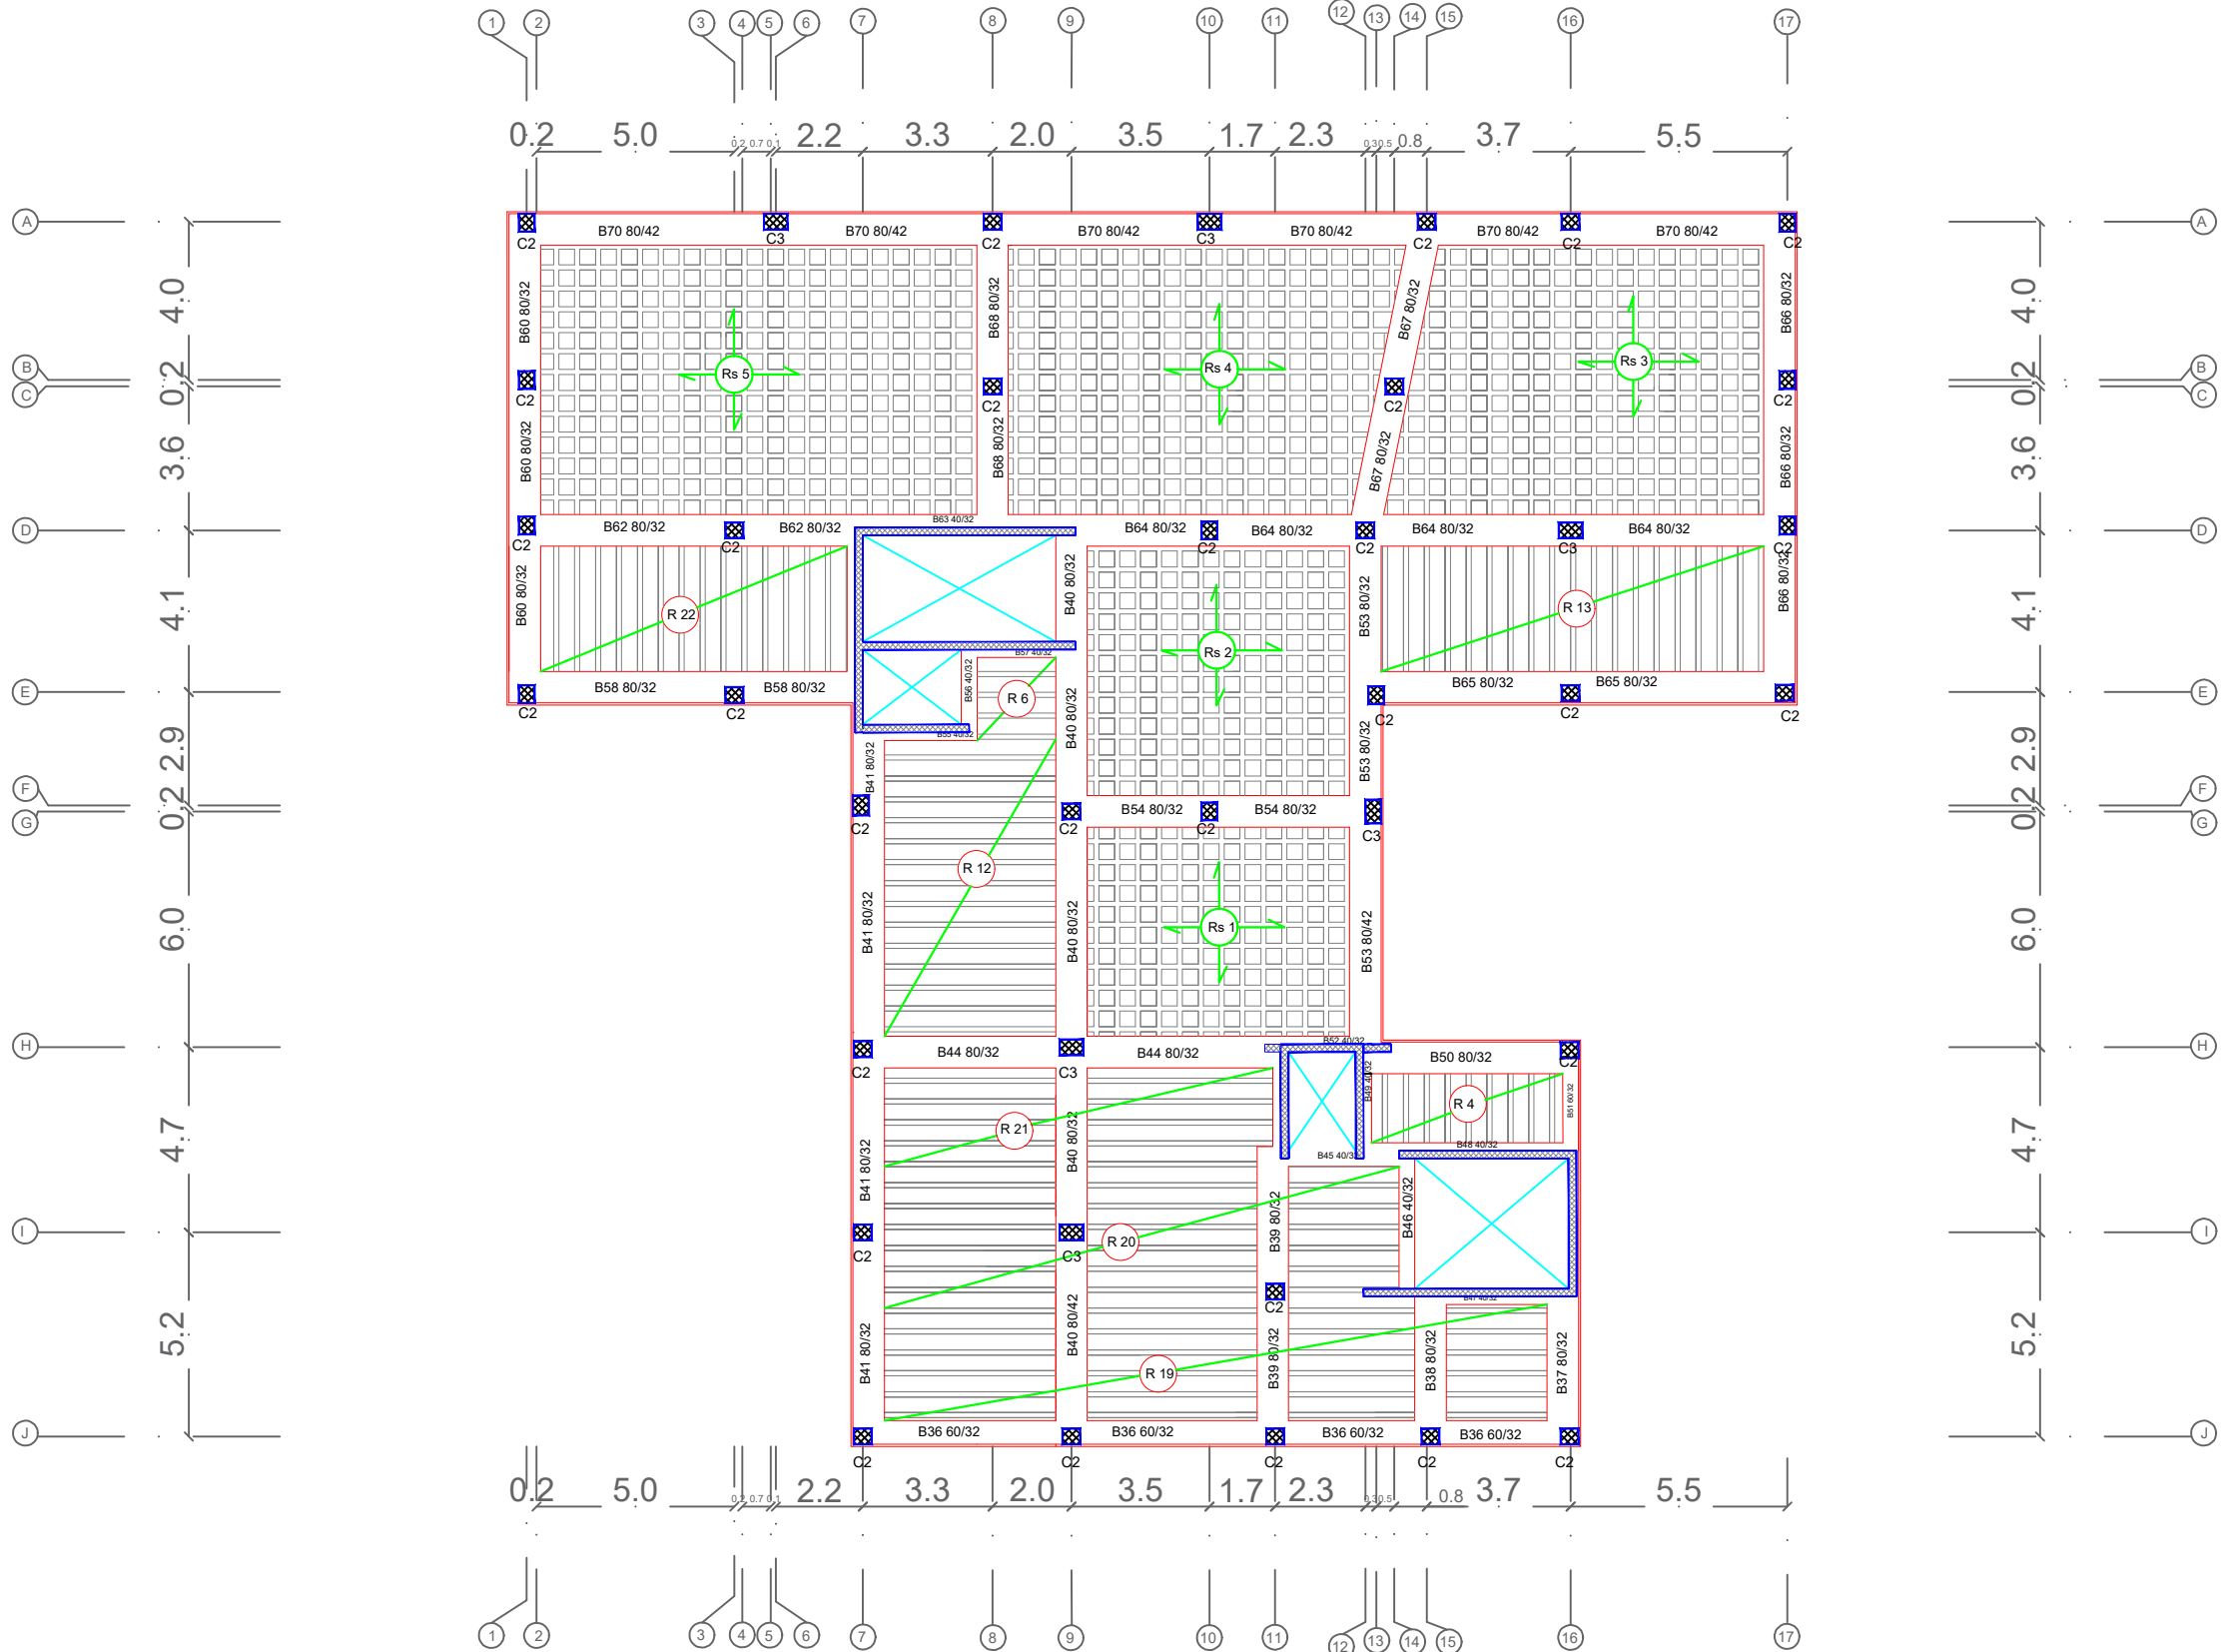

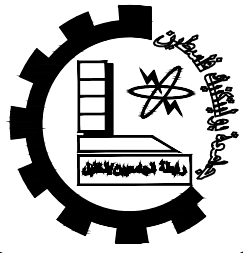

Palestine Polytechnic University

Department of Civil Engineering

College of Engineering

Civil Engineering

Design V

Project I

Eye-specialist Hospital

supervisors:

Dr. Nasr Abboushi  
Design by Roa' Al-jondi

Hamza.haddad  
Mohammad abu lawi

Drawing Symbol


 
S14


Drawing Tittle

SLABS DETAILING

scale

1:100

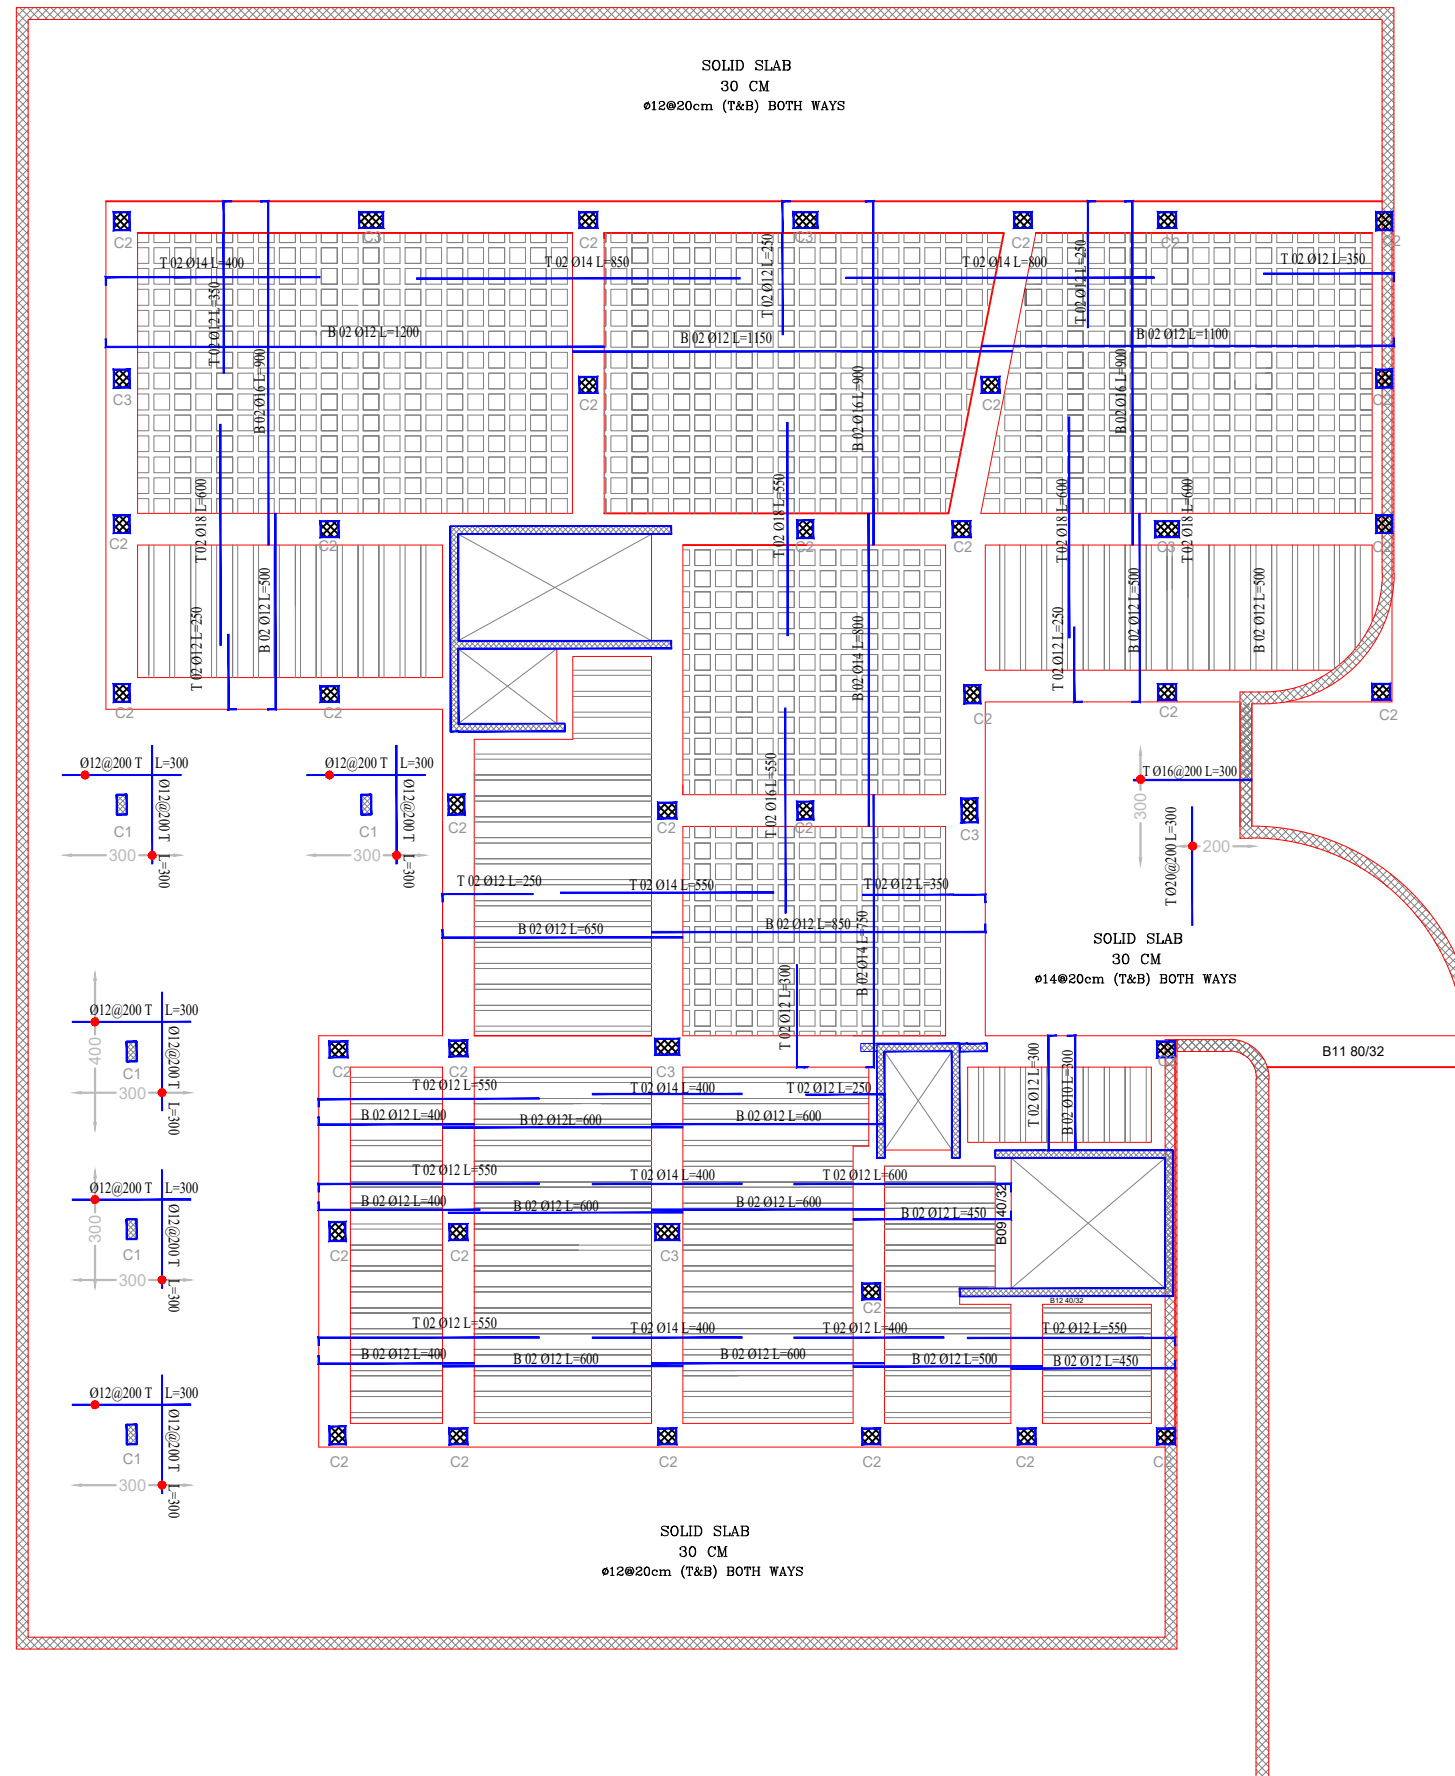

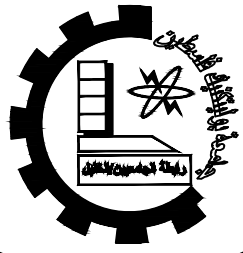

Palestine Polytechnic University

Department of Civil Engineering

College of Engineering

Civil Engineering

Design V

Project I

Eye-specialist Hospital

supervisors:

Dr. Nasr Abboushi  
Design by Roa' Al-jondi

Hamza.haddad  
Mohammad abu lawi

Drawing Symbol


 
S15


Drawing Tittle

SLABS DETAILING

scale

1:100

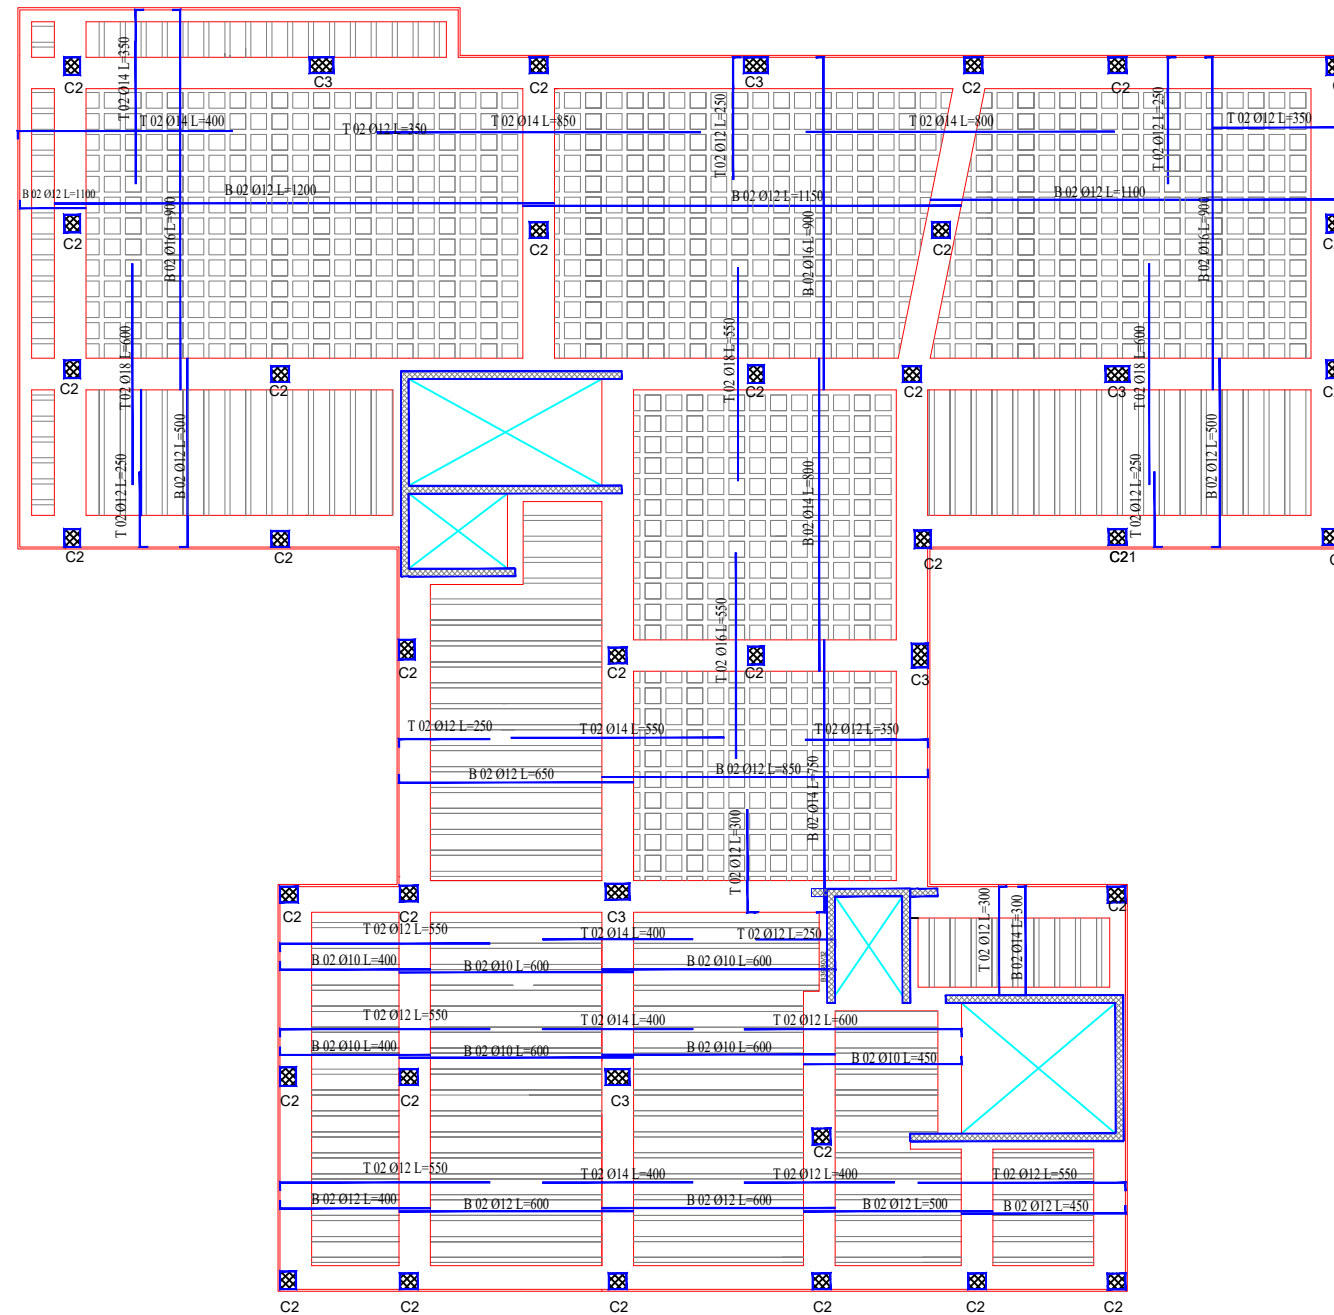

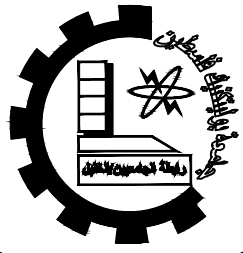

Palestine Polytechnic University

Department of Civil Engineering

College of Engineering

Civil Engineering

Design V

Project I

Eye-specialist Hospital

supervisors:

Dr. Nasr Abboushi  
Design by Roa' Al-jondi

Hamza.haddad  
Mohammad abu lawi

Drawing Symbol


 
S16


Drawing Tittle

SLABS DETAILING

scale

1:100

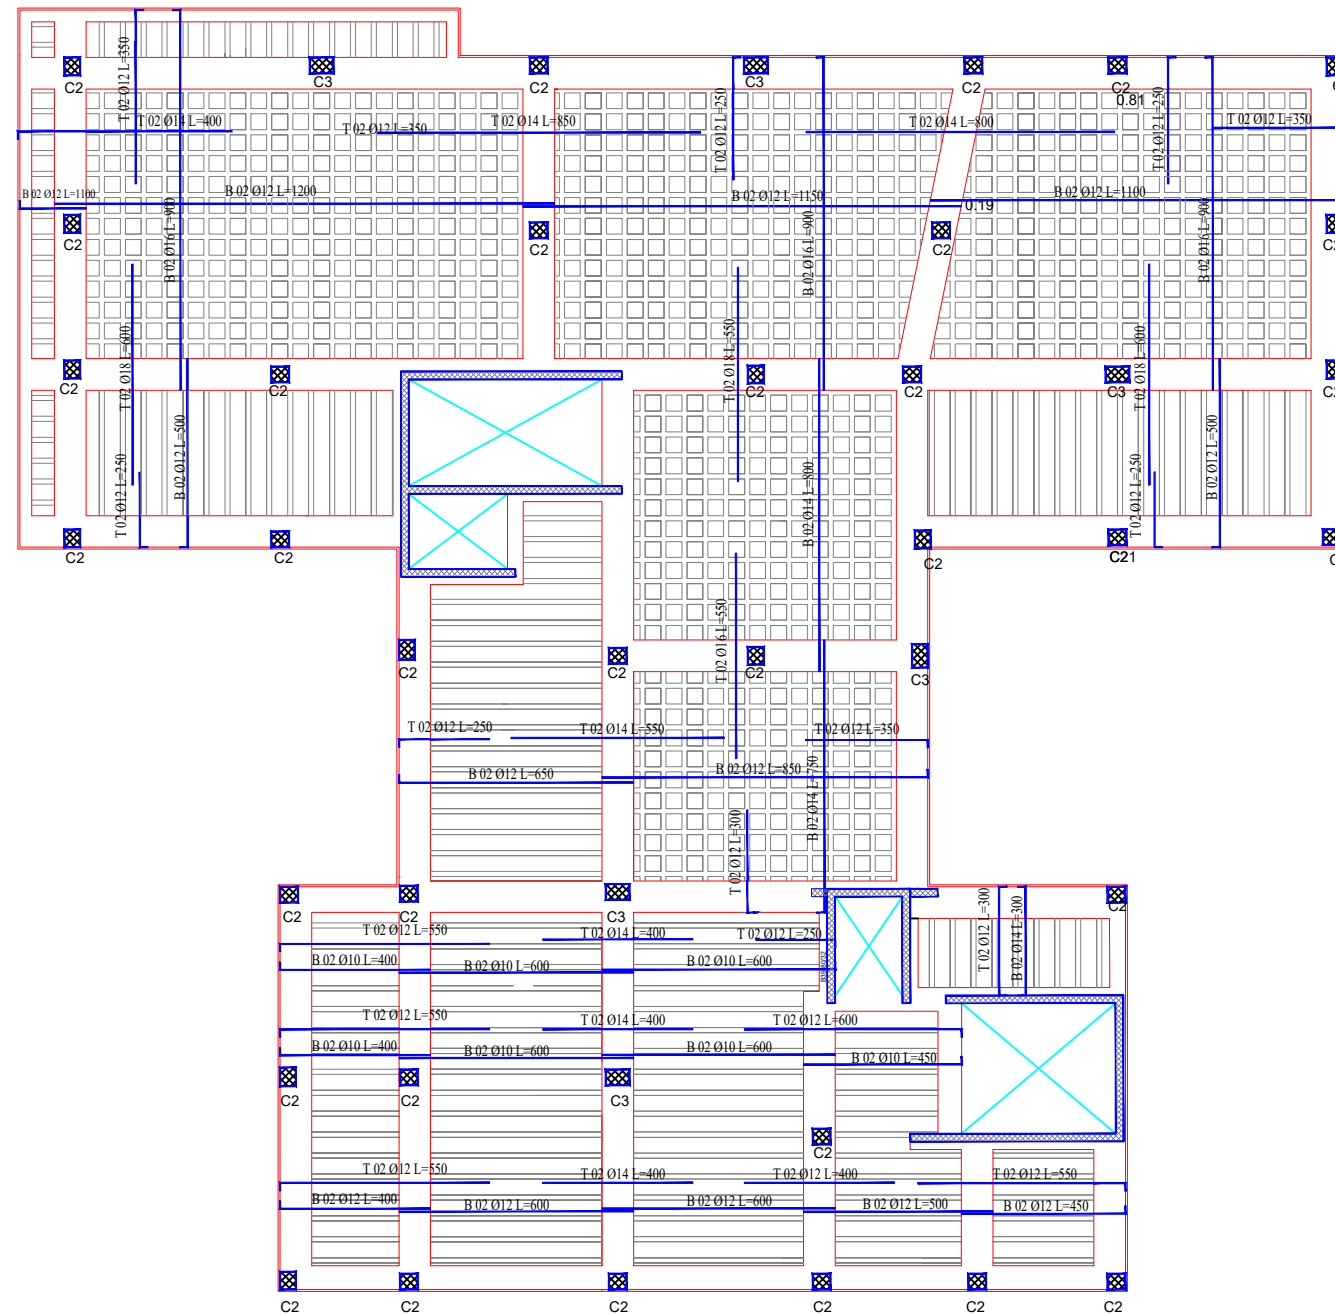

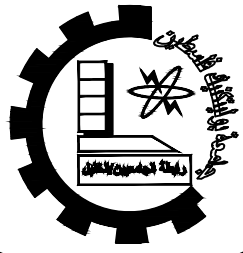

Palestine Polytechnic University

Department of Civil Engineering

College of Engineering

Civil Engineering

Design V

Project I

Eye-specialist Hospital

supervisors:

Dr. Nasr Abboushi  
Design by Roa' Al-jondi

Hamza.haddad  
Mohammad abu lawi

Drawing Symbol


 
S17


Drawing Tittle

SLABS DETAILING

scale

1:100

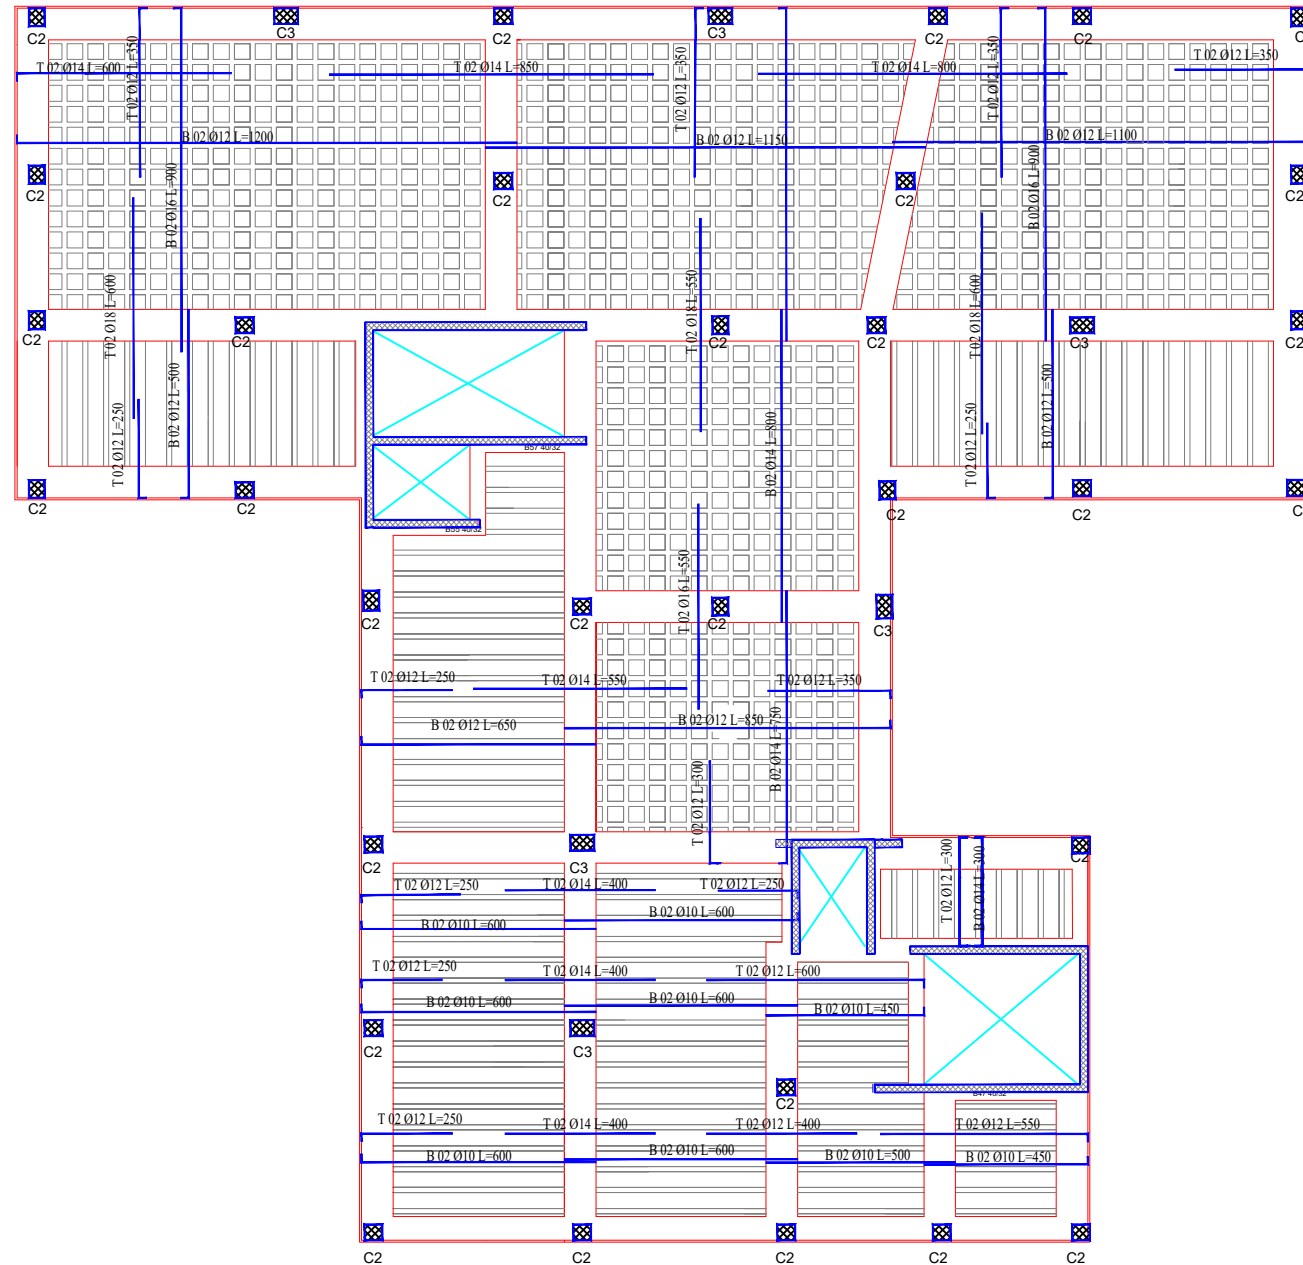

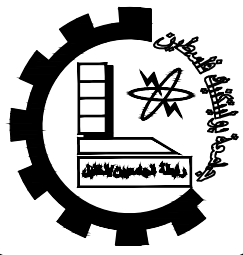

Palestine Polytechnic University

Department of Civil Engineering

College of Engineering

Civil Engineering

Design V

Project I

Eye-specialist Hospital

supervisors:

Dr. Nasr Abboushi  
Design by Roa' Al-jondi

Hamza.haddad  
Mohammad abu lawi

Drawing Symbol


 
S18

Drawing Tittle



BASEMENT  
BEAMS DETAILING

scale



1:50

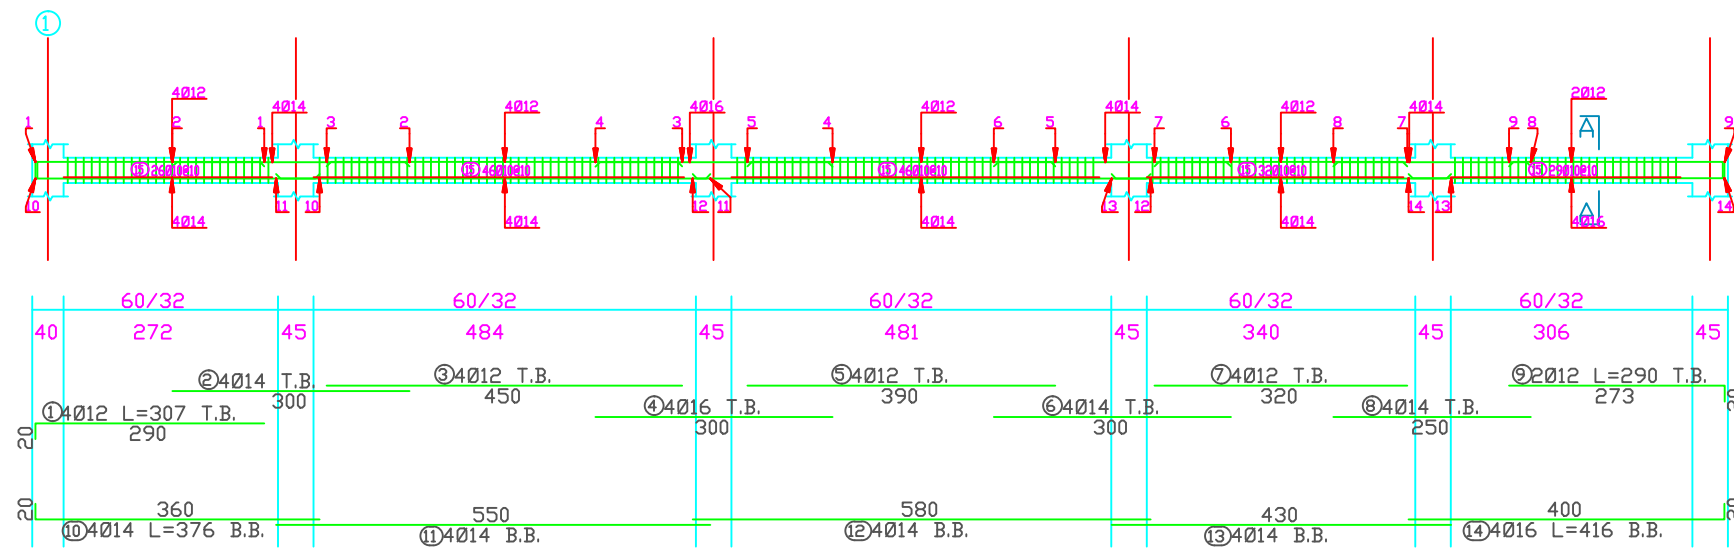


Beam:01

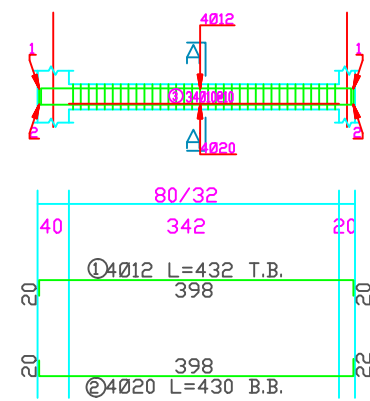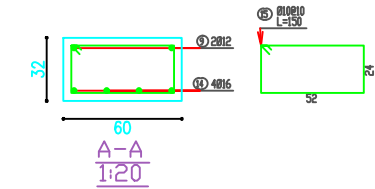


Beam:2

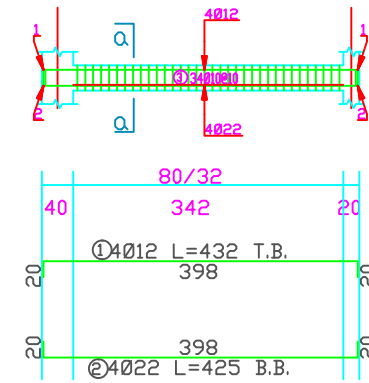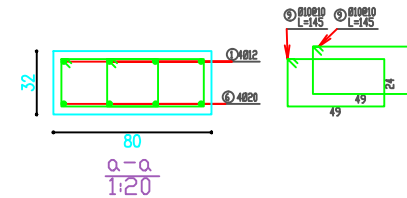

Beam: 3

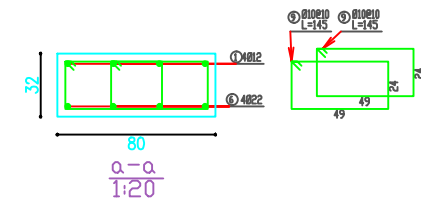



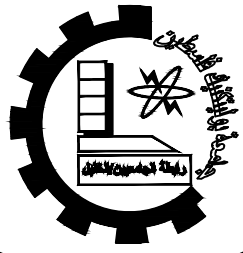

Palestine Polytechnic University

Department of Civil Engineering

College of Engineering

Civil Engineering

Design V

Project I

Eye-specialist Hospital

supervisors:

Dr. Nasr Abboushi  
Design by Roa' Al-jondi

Hamza.haddad  
Mohammad abu lawi

Drawing Symbol






 
S19


Drawing Tittle

BASEMENT  
BEAMS DETAILING

scale

1:50

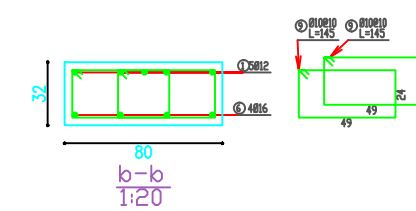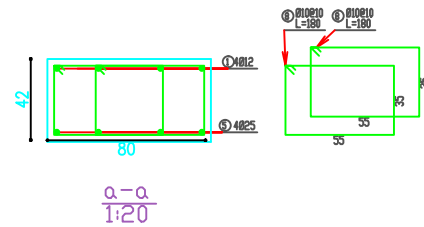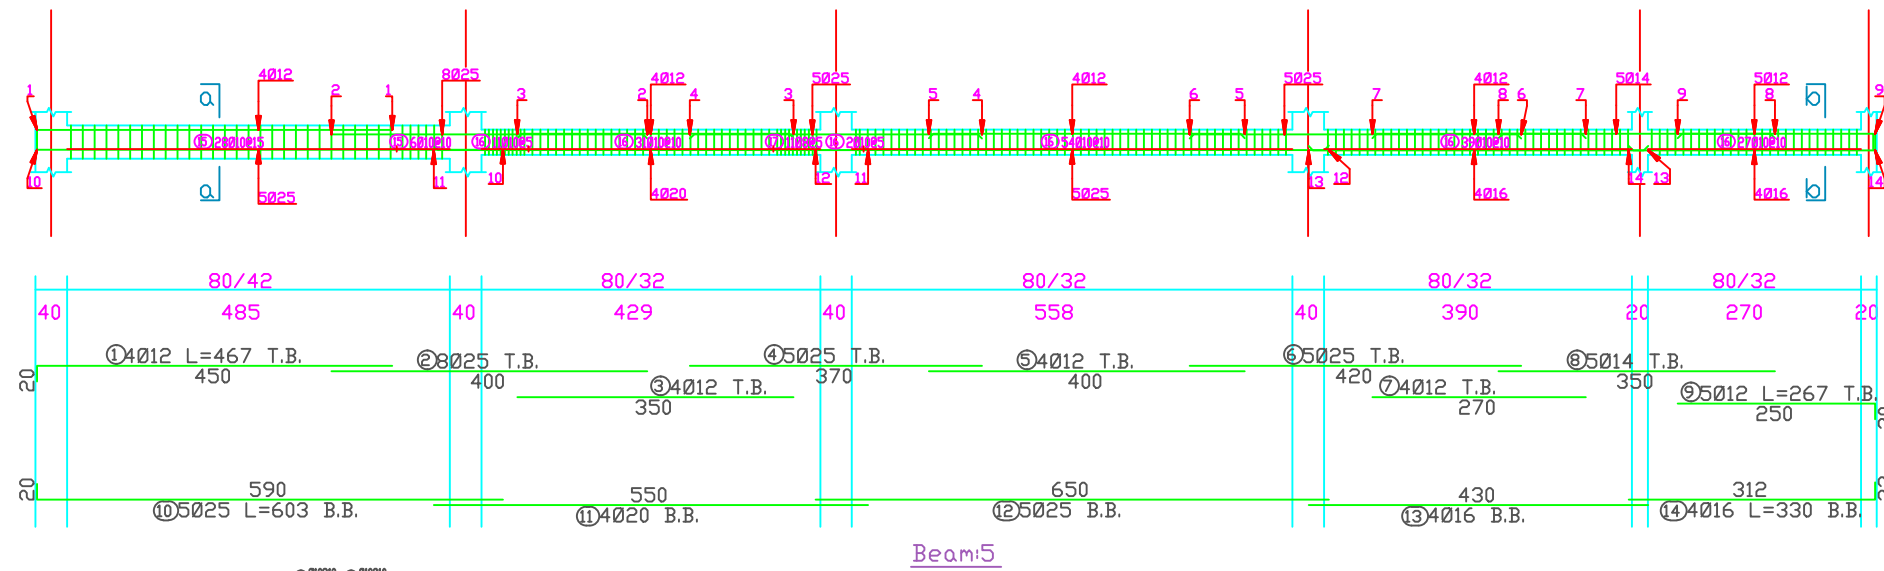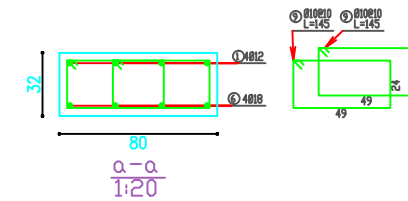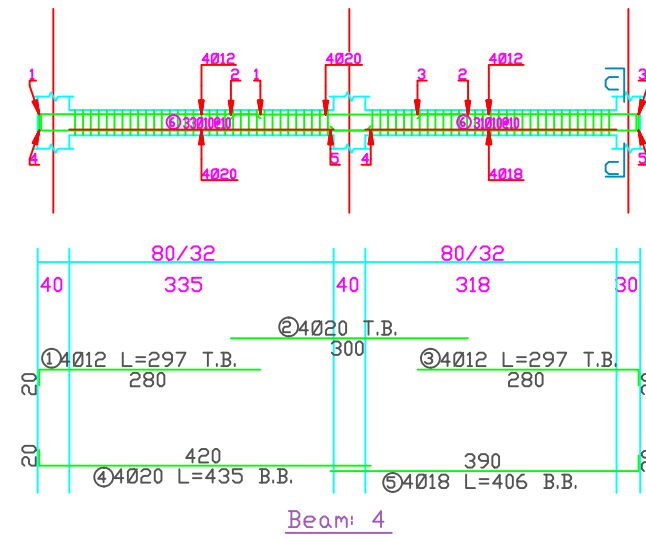

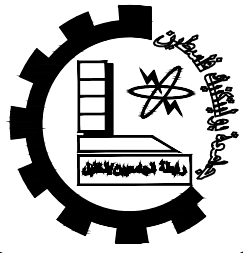

Palestine Polytechnic University

Department of Civil Engineering

College of Engineering

Civil Engineering

Design V

Project I

Eye-specialist Hospital

supervisors:

Dr. Nasr Abboushi  
Design by Roa' Al-jondi

Hamza.haddad  
Mohammad abu lawi

Drawing Symbol




 
S20


Drawing Tittle

BASEMENT  
BEAMS DETAILING

scale

1:50

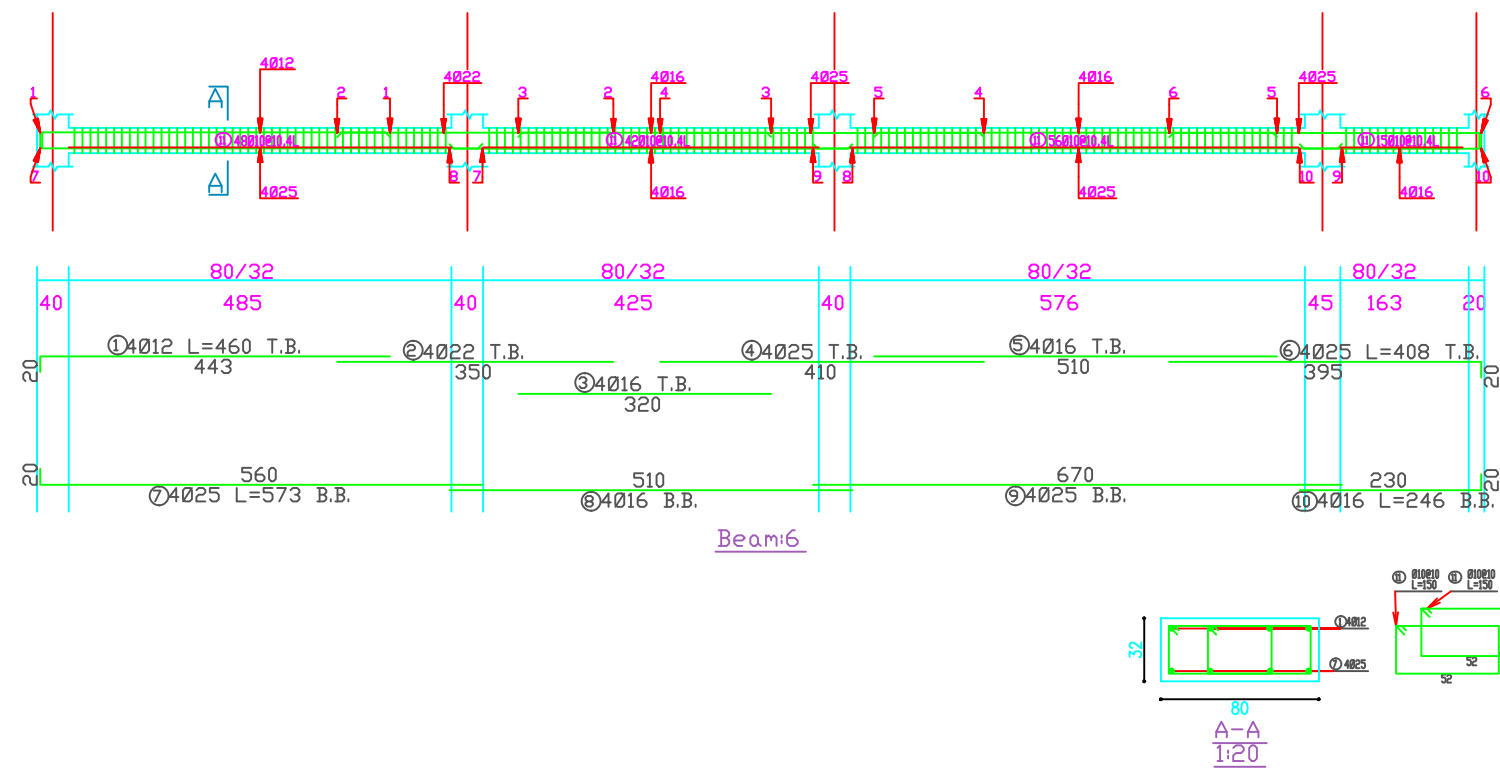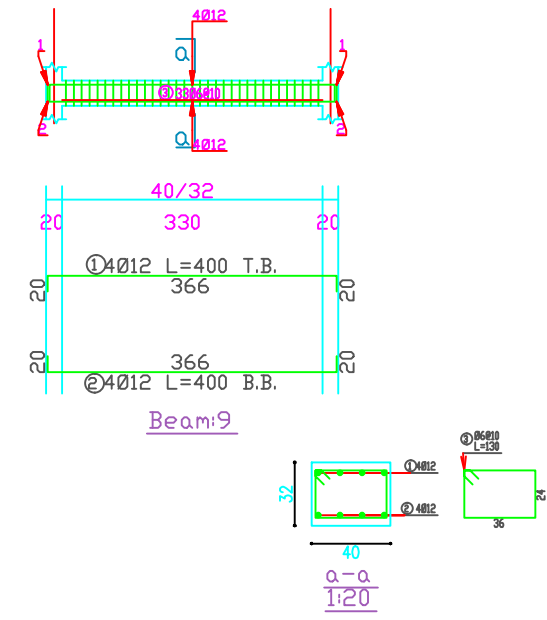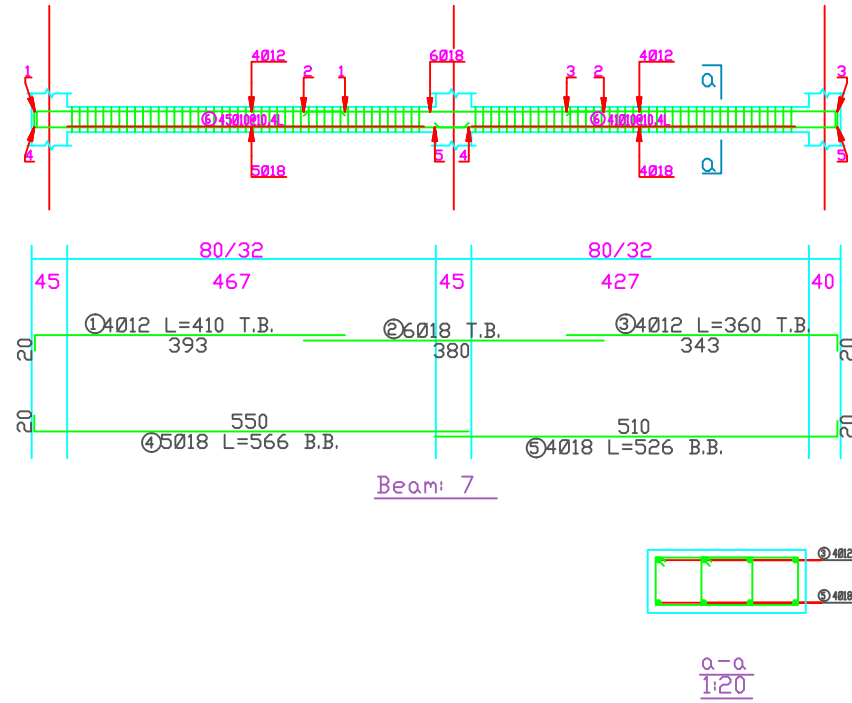

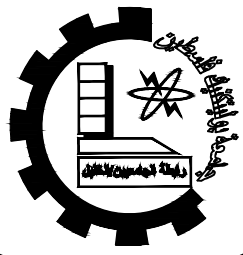

Palestine Polytechnic University

Department of Civil Engineering

College of Engineering

Civil Engineering

Design V

Project I

Eye-specialist Hospital

supervisors:

Dr. Nasr Abboushi  
Design by Roa' Al-jondi

Hamza.haddad  
Mohammad abu lawi

Drawing Symbol


 
S21

Drawing Title


BASEMENT  
BEAMS DETAILING

scale


1:50

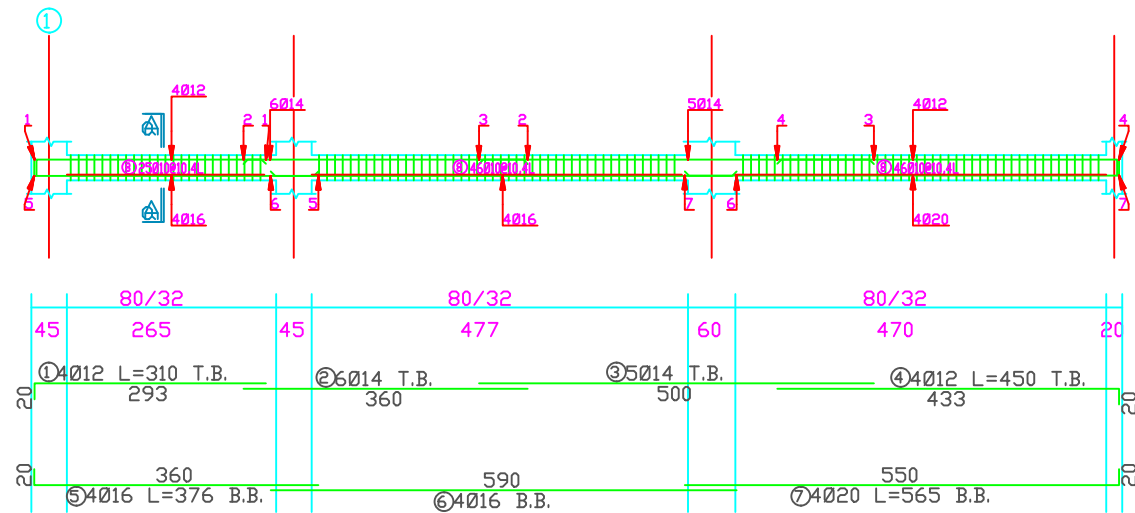

Beam10

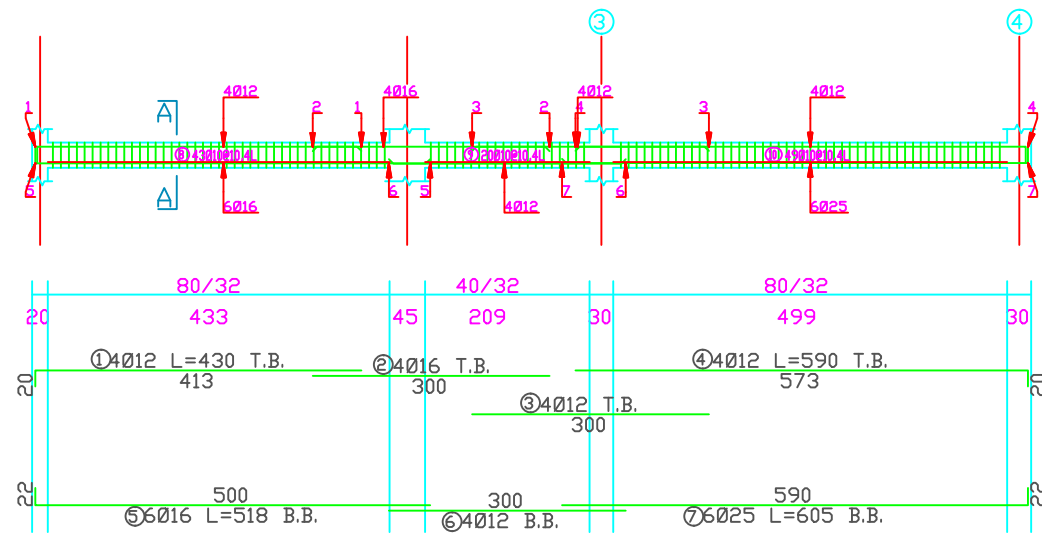

Beam11

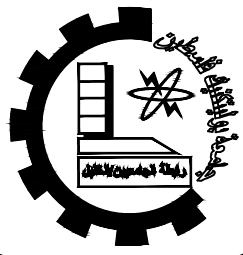

Palestine Polytechnic University

Department of Civil Engineering

College of Engineering

Civil Engineering

Design V

Project I

Eye-specialist Hospital

supervisors:

Dr. Nasr Abboushi  
Design by Roa' Al-jondi

Hamza.haddad  
Mohammad abu lawi

Drawing Symbol


 
S22

Drawing Title



BASEMENT  
BEAMS DETAILING

scale



1:50

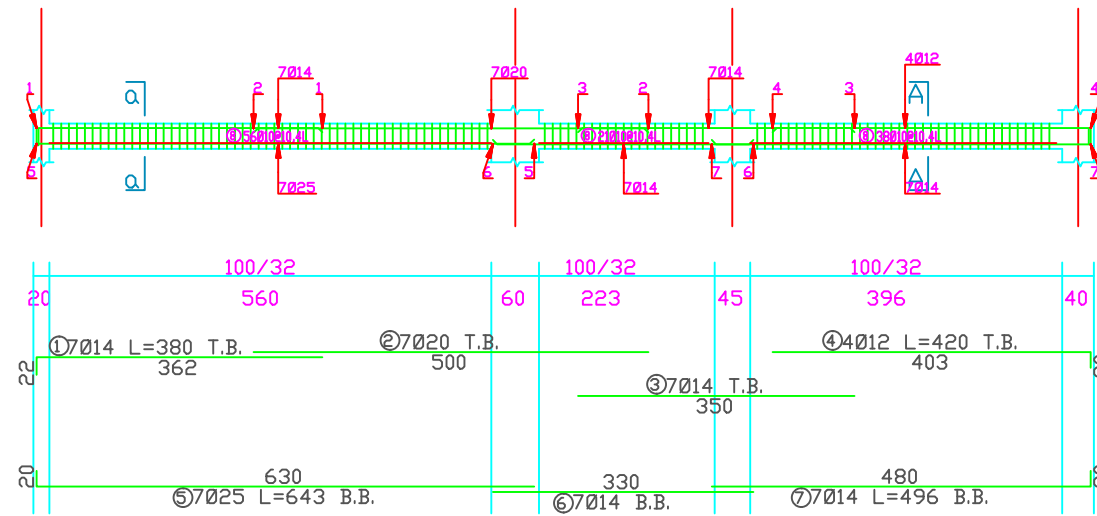


Beam: 13

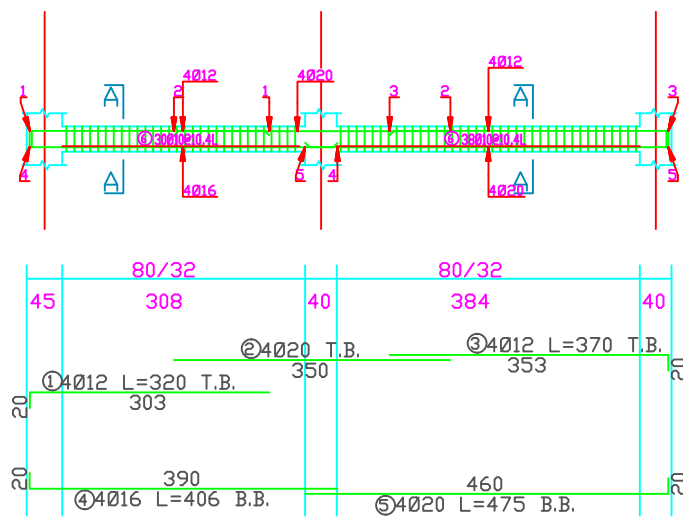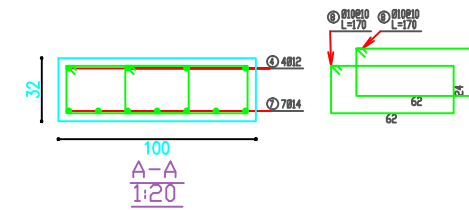


Beam:14

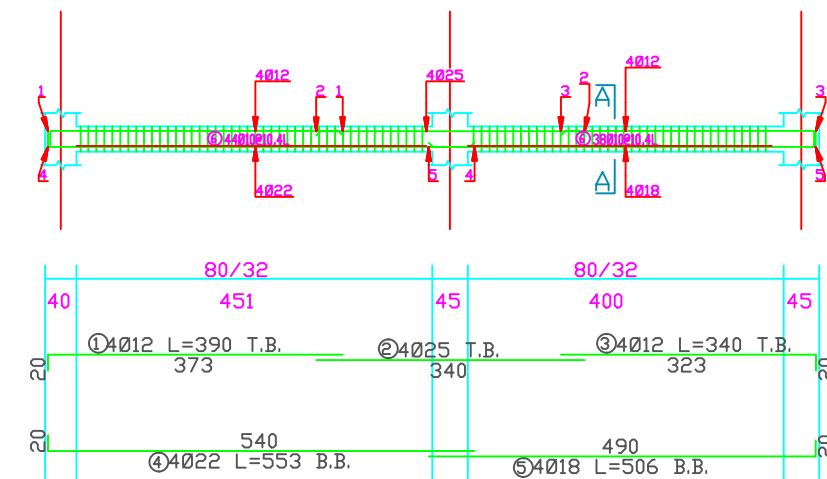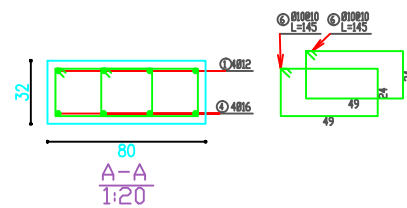

Beam:15

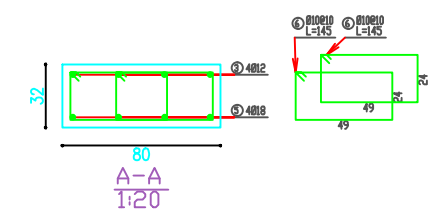

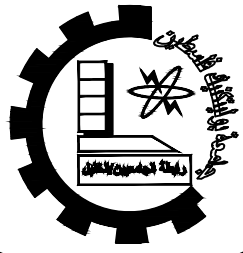

Palestine Polytechnic University

Department of Civil Engineering

College of Engineering

Civil Engineering

Design V

Project I

Eye-specialist Hospital

supervisors:

Dr. Nasr Abboushi  
Design by Roa' Al-jondi

Hamza.haddad  
Mohammad abu lawi

Drawing Symbol


 
S23

Drawing Tittle



BASEMENT  
BEAMS DETAILING

scale



1:50

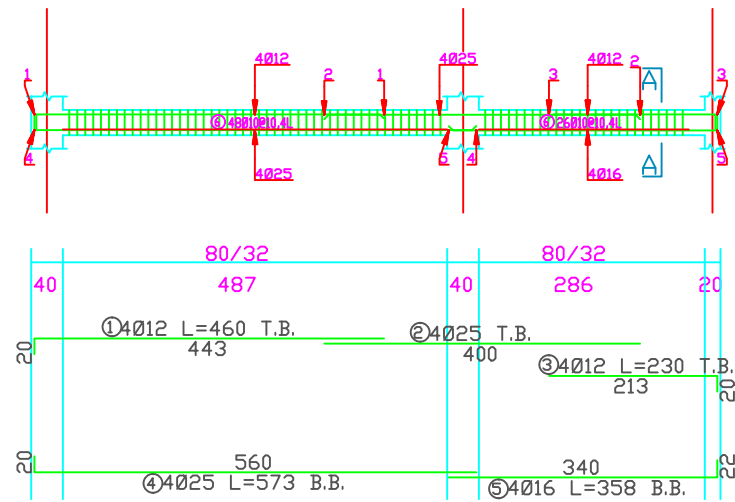


Beam17

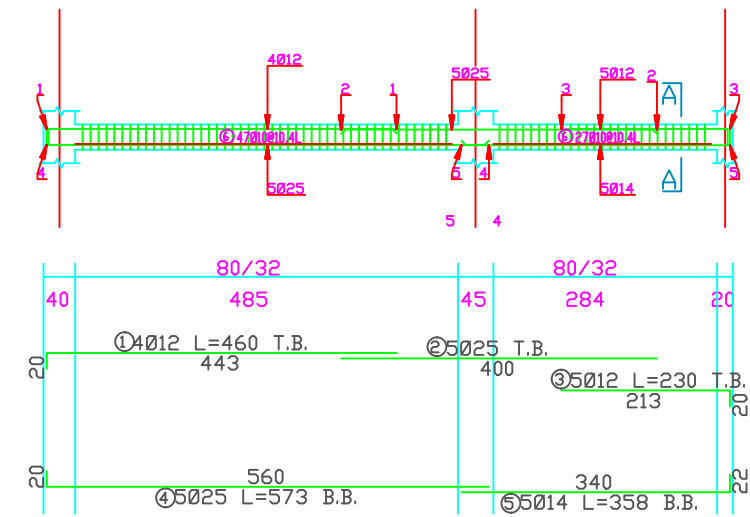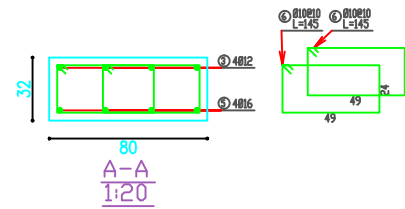


Beam18

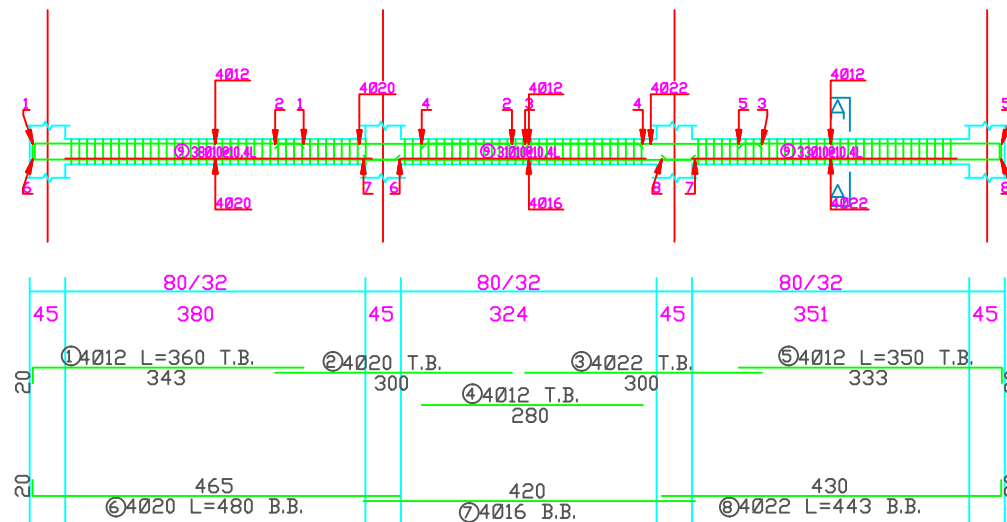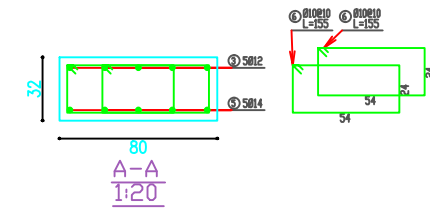

Beam19

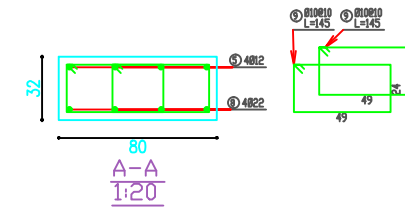

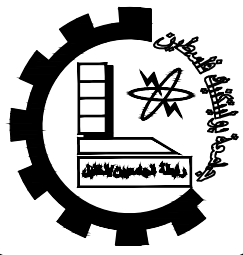

Palestine Polytechnic University

Department of Civil Engineering

College of Engineering

Civil Engineering

Design V

Project I

Eye-specialist Hospital

supervisors:

Dr. Nasr Abboushi  
Design by Roa' Al-jondi

Hamza.haddad  
Mohammad abu lawi

Drawing Symbol



 
S24

Drawing Title

BASEMENT  
BEAMS DETAILING

scale


1:50

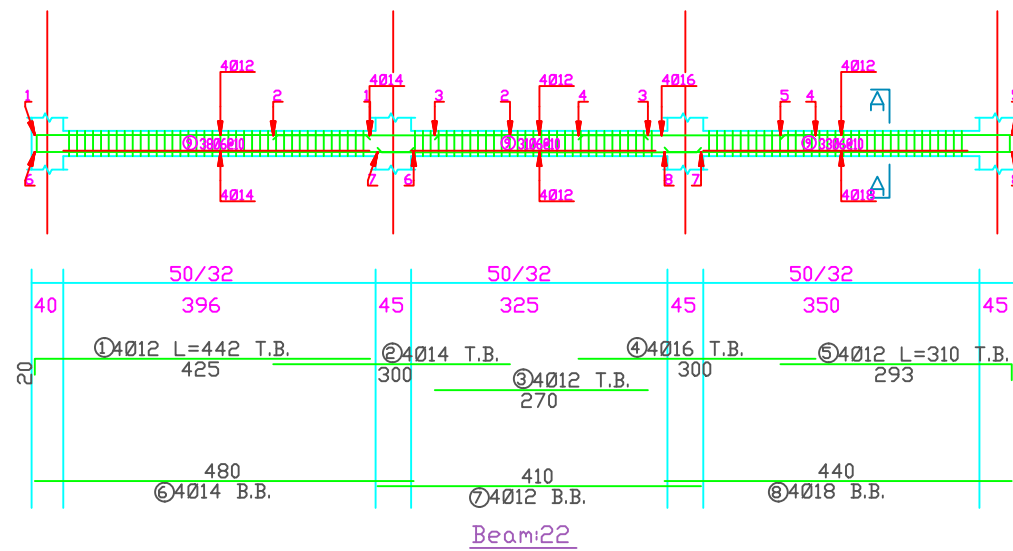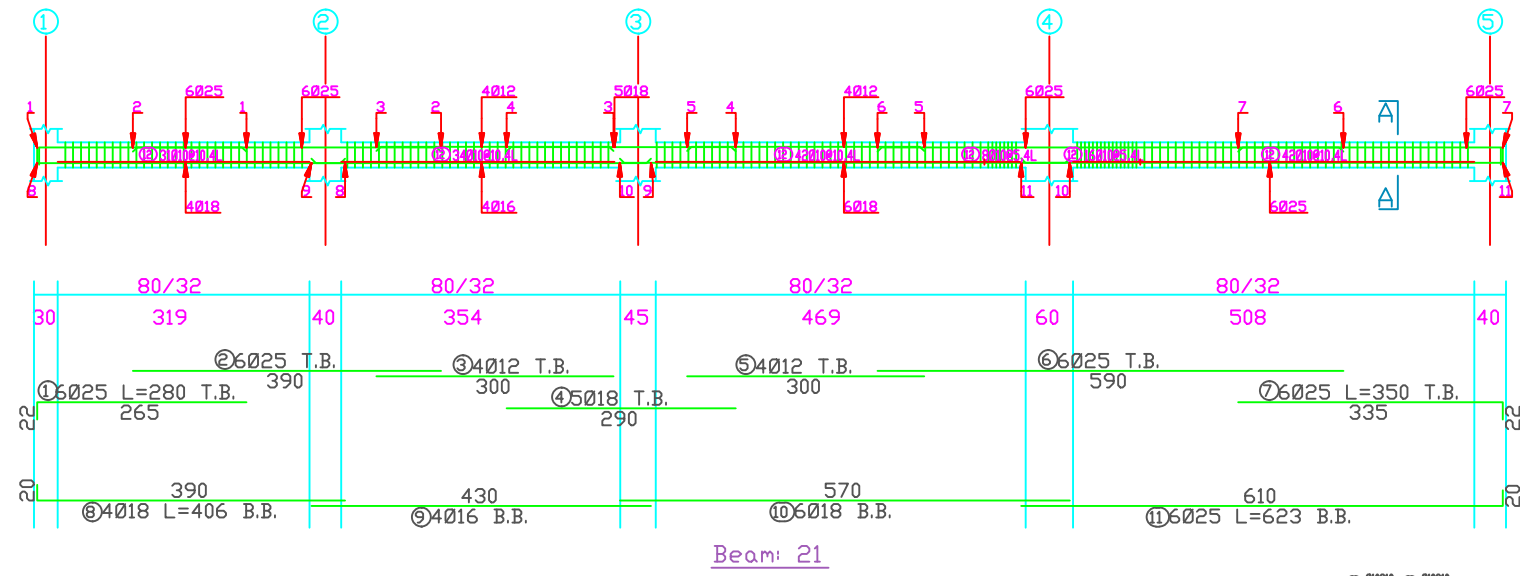







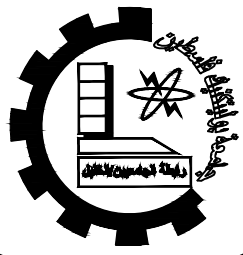

Palestine Polytechnic University

Department of Civil Engineering

College of Engineering

Civil Engineering

Design V

Project I

Eye-specialist Hospital

supervisors:

Dr. Nasr Abboushi  
Design by Roa' Al-jondi

Hamza.haddad  
Mohammad abu lawi

Drawing Symbol





 
S27


Drawing Tittle

BASEMENT  
BEAMS DETAILING

scale

1:50

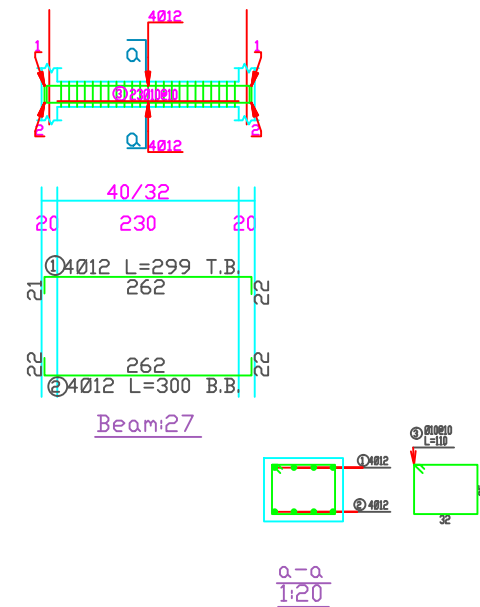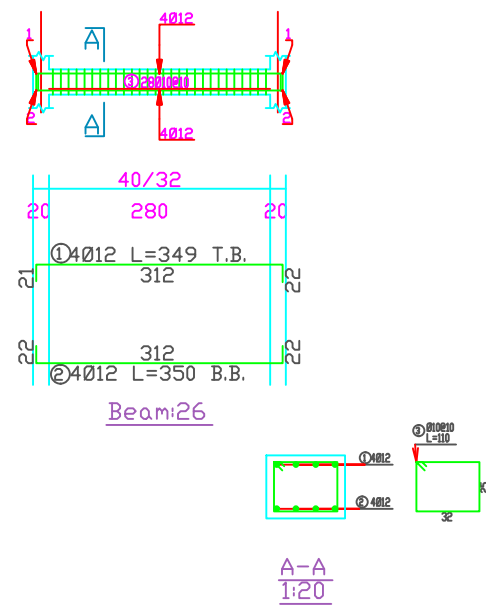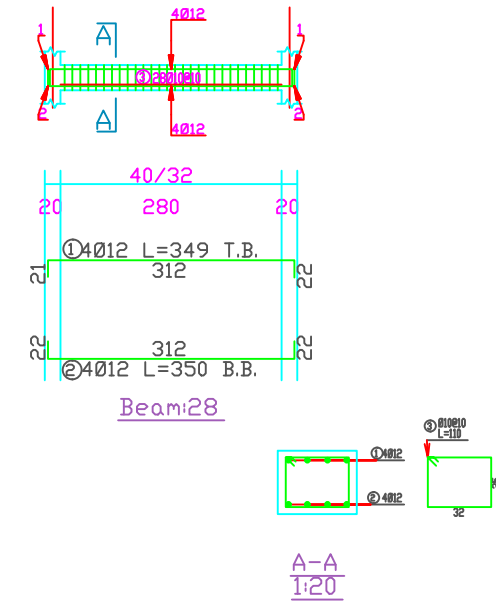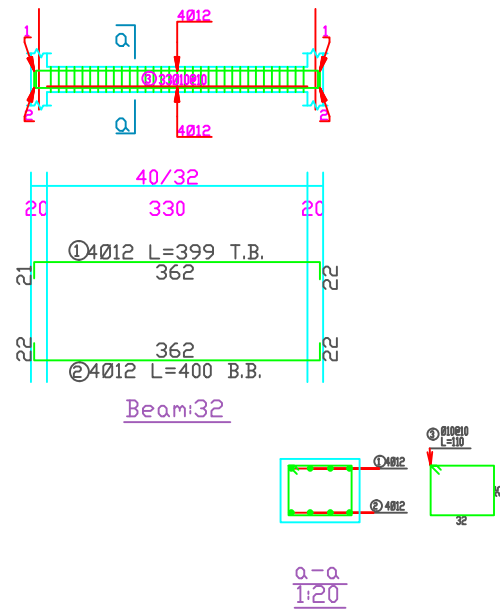

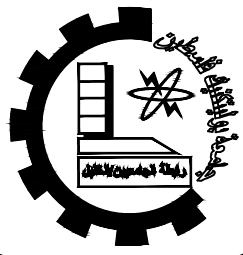

Palestine Polytechnic University

Department of Civil Engineering

College of Engineering

Civil Engineering

Design V

Project I

Eye-specialist Hospital

supervisors:

Dr. Nasr Abboushi  
Design by Roa' Al-jondi

Hamza.haddad  
Mohammad abu lawi

Drawing Symbol




 
S28


Drawing Tittle

BASEMENT  
BEAMS DETAILING

scale

1:50

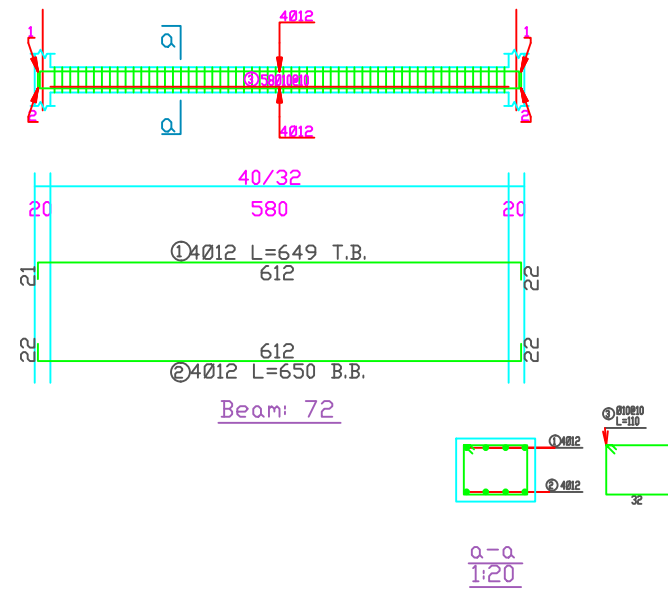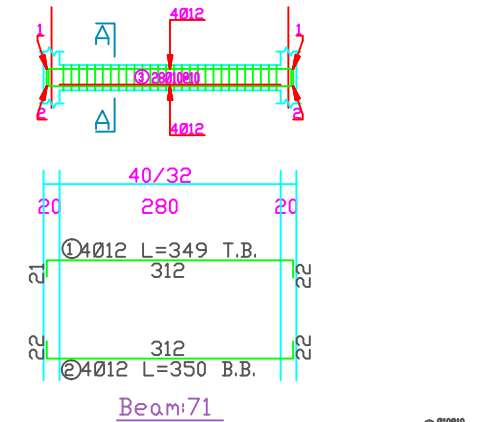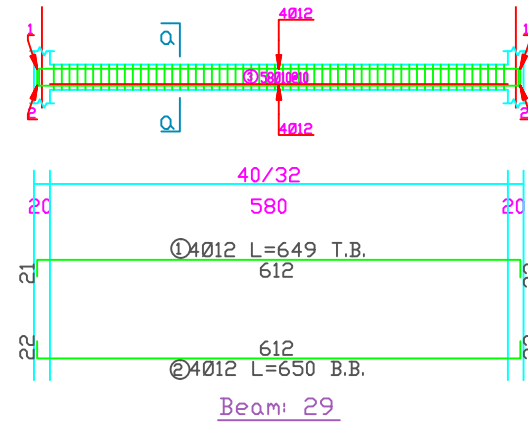

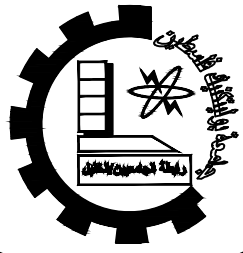

Palestine Polytechnic University

Department of Civil Engineering

College of Engineering

Civil Engineering

Design V

Project I

Eye-specialist Hospital

supervisors:

Dr. Nasr Abboushi  
Design by Roa' Al-jondi

Hamza.haddad  
Mohammad abu lawi

Drawing Symbol





 
S29


Drawing Tittle

BEAMS DETAILING  
GROUND & FIRST FLOOR

scale

1:50

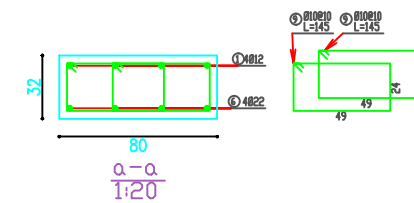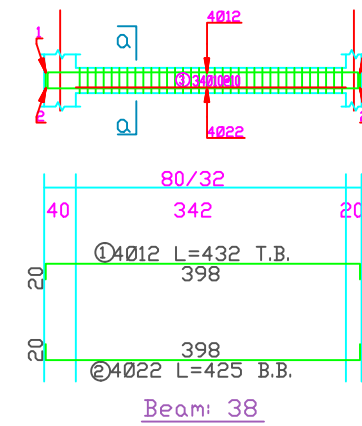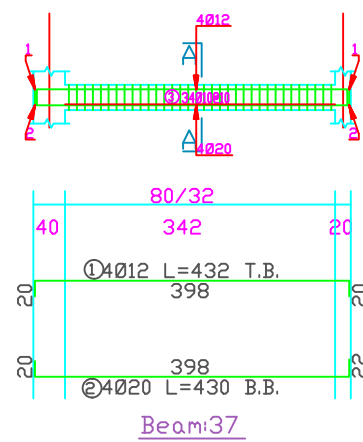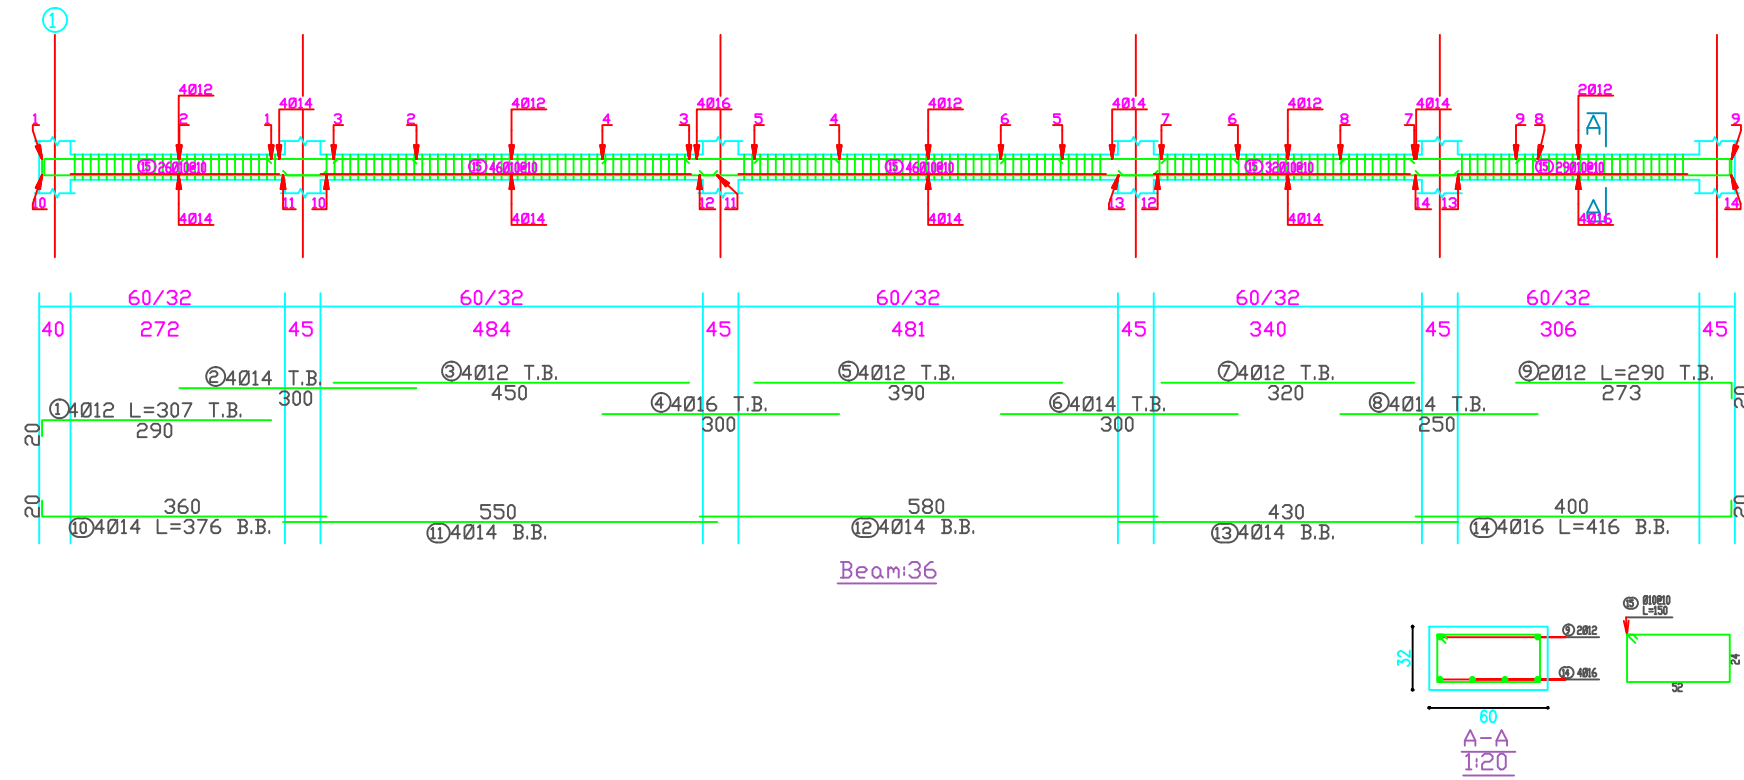

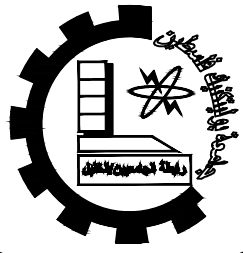

Palestine Polytechnic University

Department of Civil Engineering

College of Engineering

Civil Engineering

Design V

Project I

Eye-specialist Hospital

supervisors:

Dr. Nasr Abboushi  
Design by Roa' Al-jondi

Hamza.haddad  
Mohammad abu lawi

Drawing Symbol





 
S30

Drawing Tittle


BEAMS DETAILING  
GROUND & FIRST FLOOR

scale

1:50

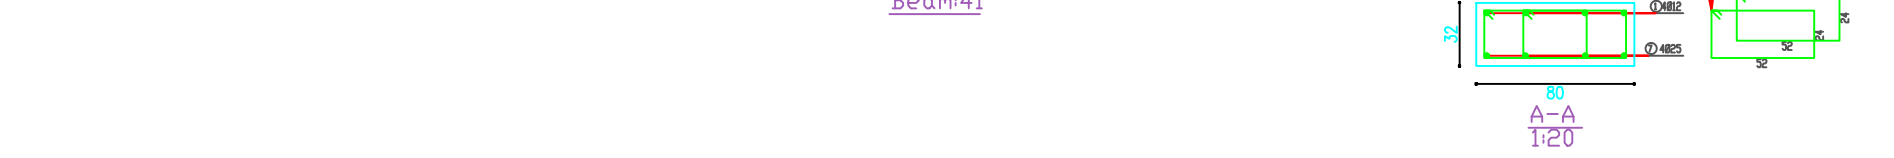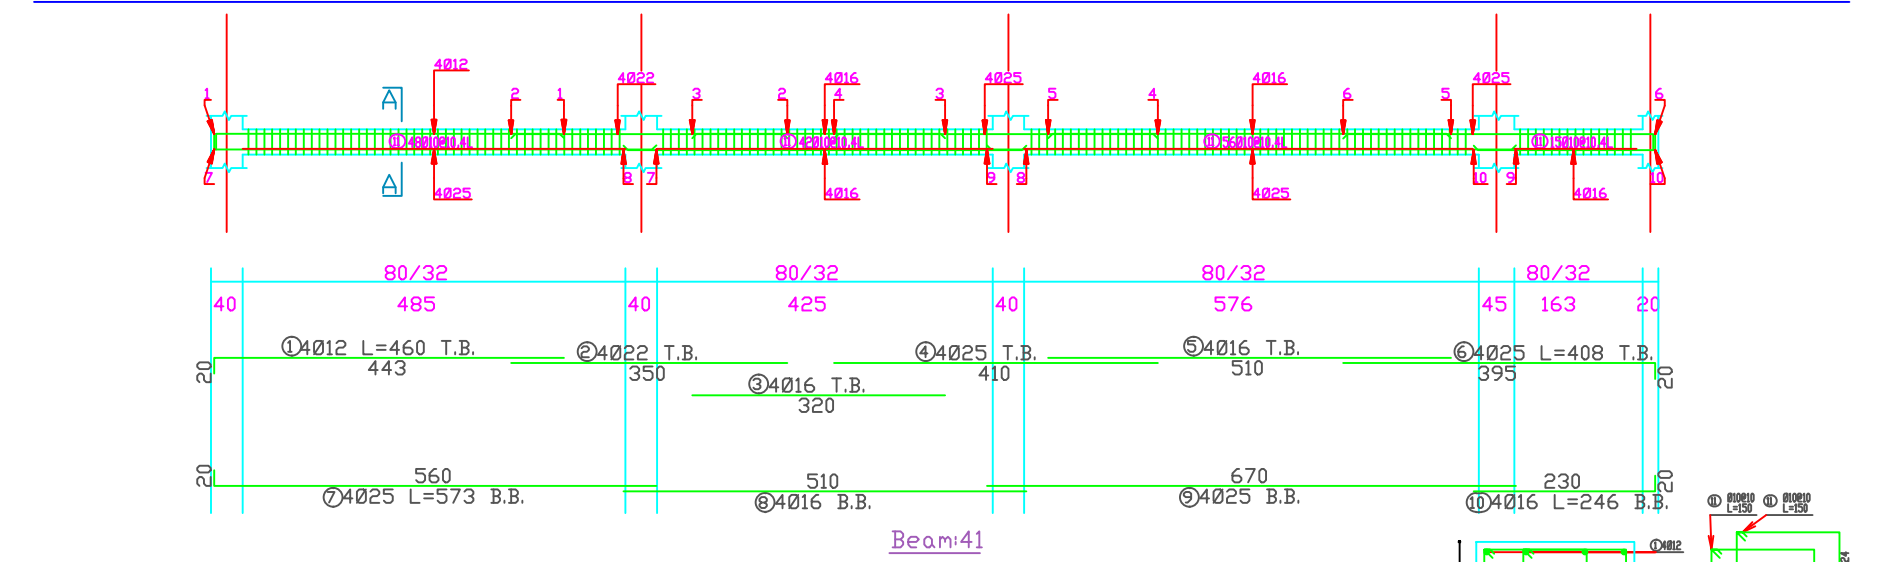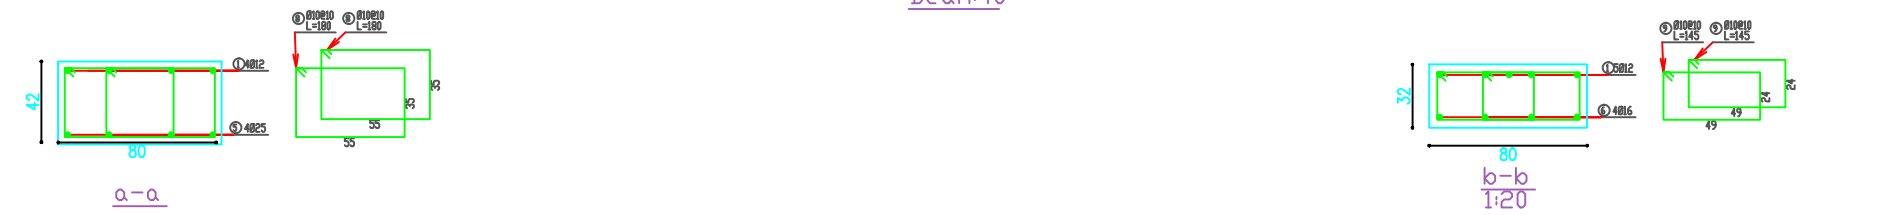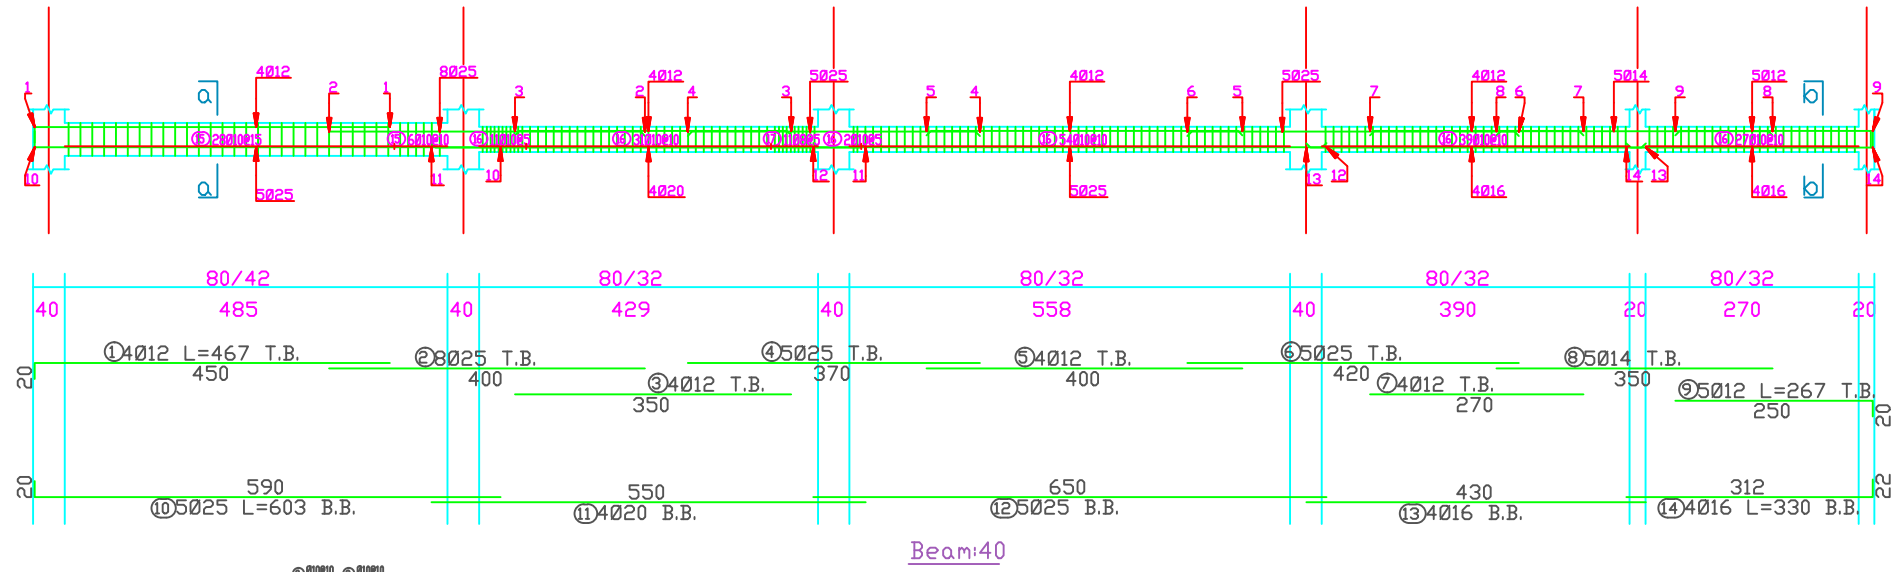



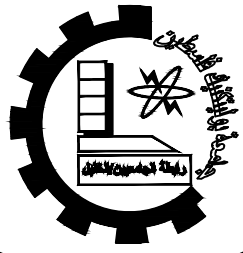

Palestine Polytechnic University

Department of Civil Engineering

College of Engineering

Civil Engineering

Design V

Project I

Eye-specialist Hospital

supervisors:

Dr. Nasr Abboushi  
Design by Roa' Al-jondi

Hamza.haddad  
Mohammad abu lawi

Drawing Symbol





 
S31


Drawing Tittle

BEAMS DETAILING  
GROUND & FIRST FLOOR

scale

1:50

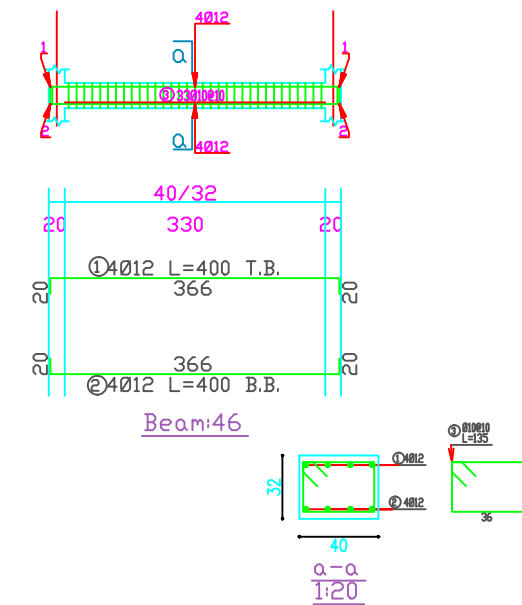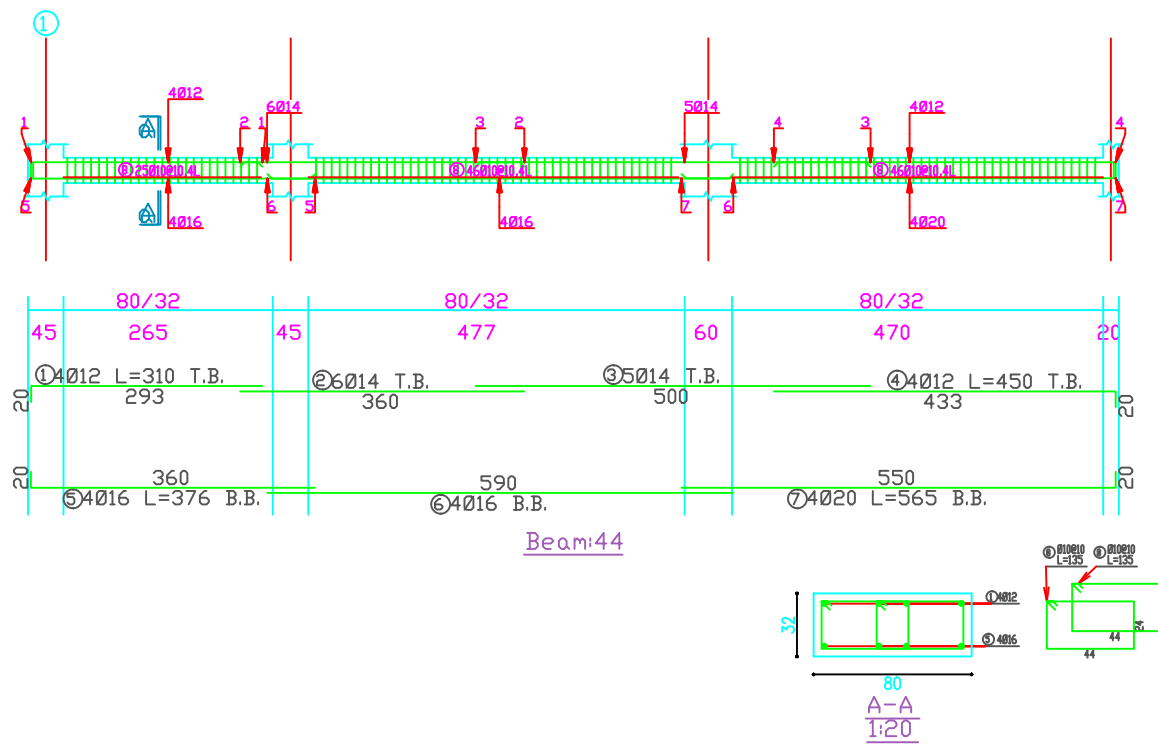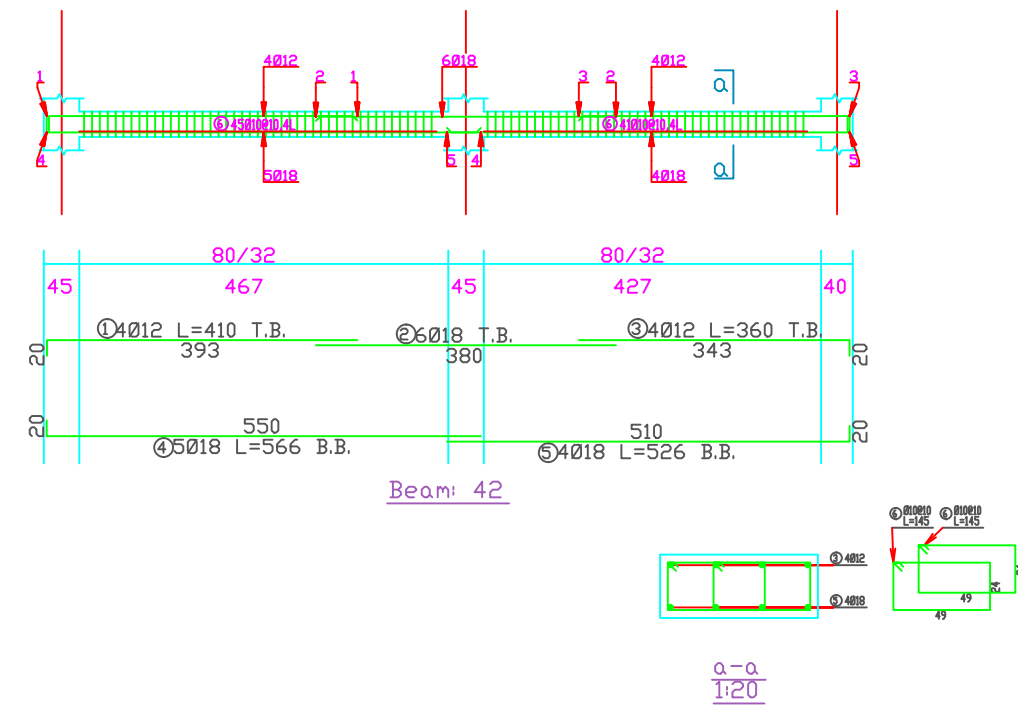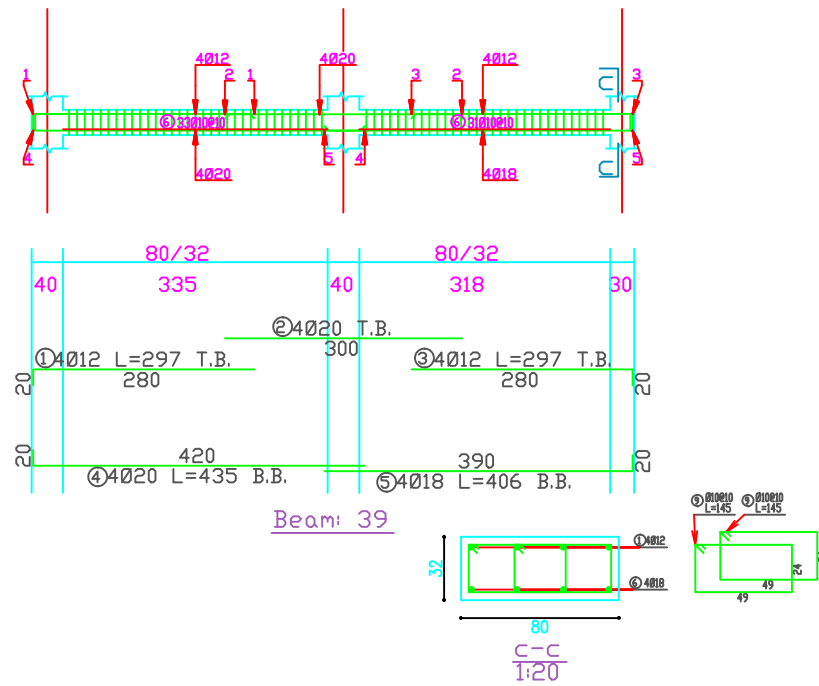

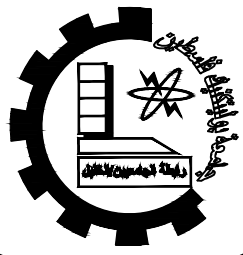

Palestine Polytechnic University

Department of Civil Engineering

College of Engineering

Civil Engineering

Design V

Project I

Eye-specialist Hospital

supervisors:

Dr. Nasr Abboushi  
Design by Roa' Al-jondi

Hamza.haddad  
Mohammad abu lawi

Drawing Symbol








 
S32


Drawing Title

BEAMS DETAILING  
GROUND & FIRST FLOOR

scale

1:50

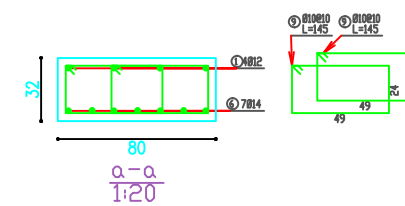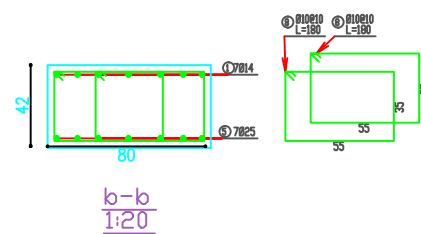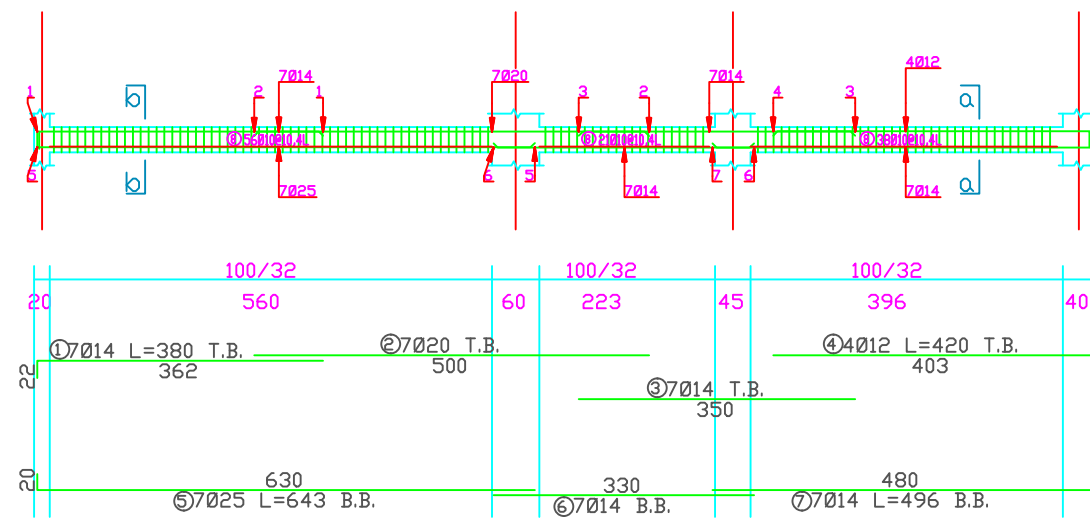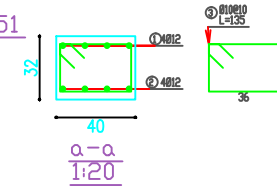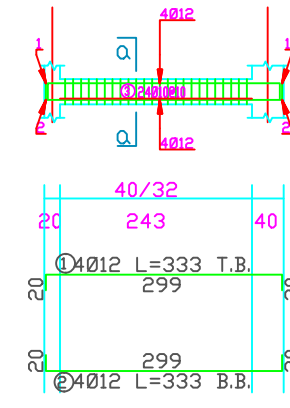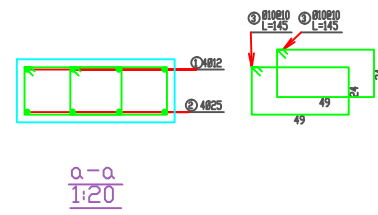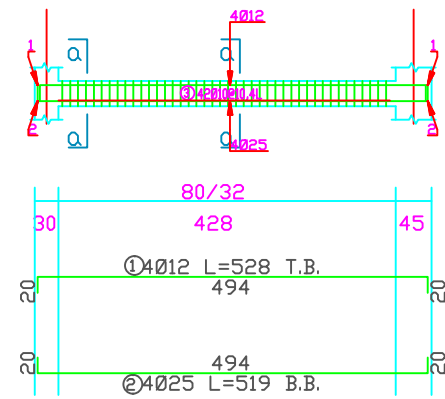

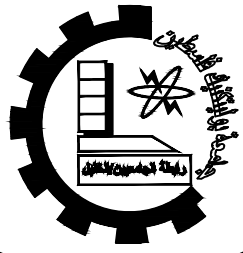

Palestine Polytechnic University

Department of Civil Engineering

College of Engineering

Civil Engineering

Design V

Project I

Eye-specialist Hospital

supervisors:

Dr. Nasr Abboushi  
Design by Roa' Al-jondi

Hamza.haddad  
Mohammad abu lawi

Drawing Symbol


 
S33

Drawing Tittle



BEAMS DETAILING  
GROUND & FIRST FLOOR

scale



1:50

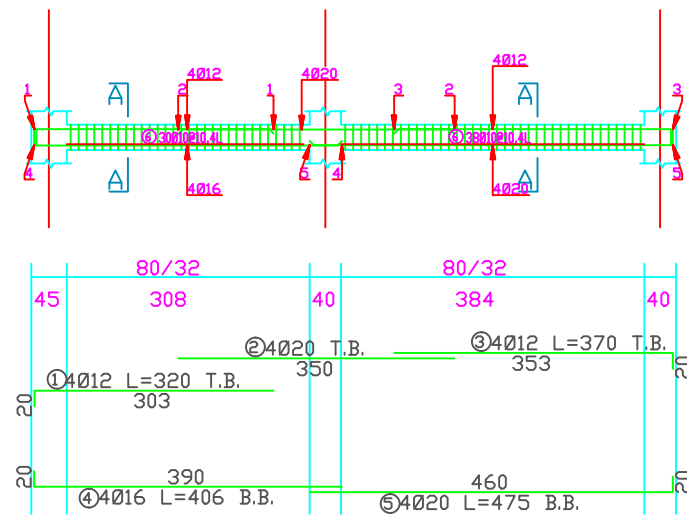


Beam:54

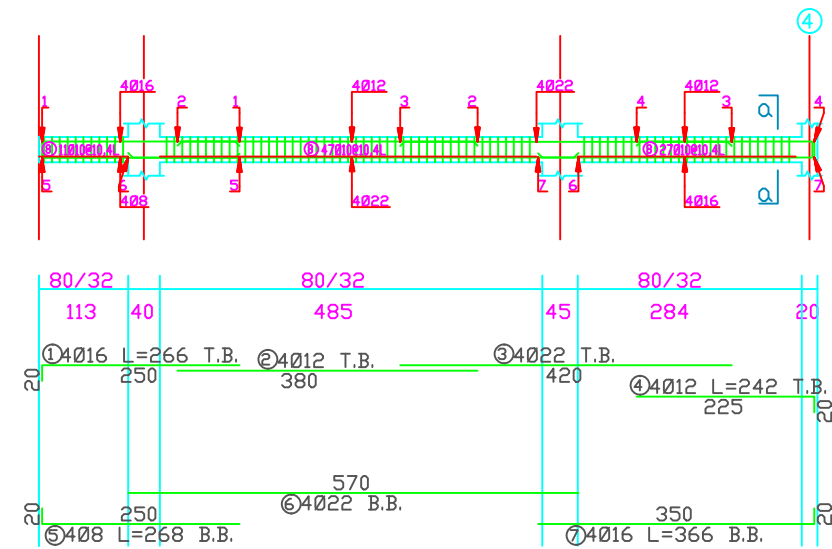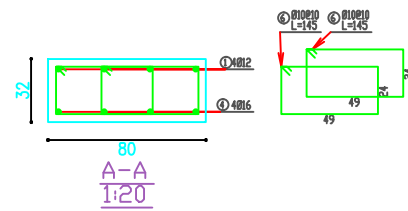


Beam:58

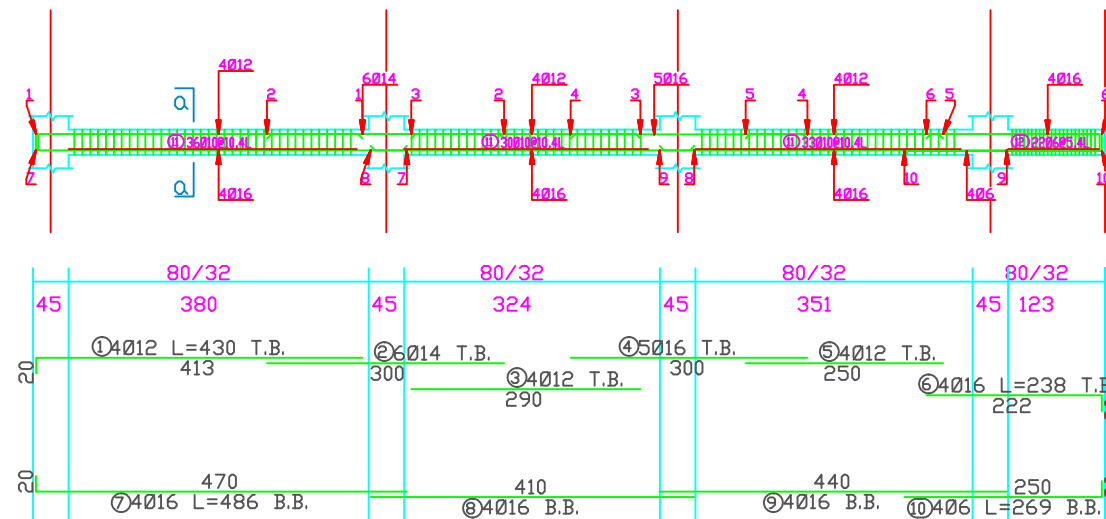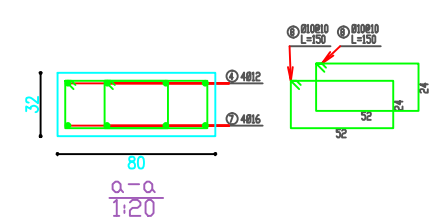

Beam:60

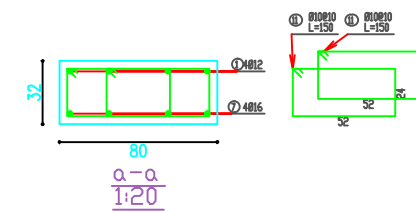

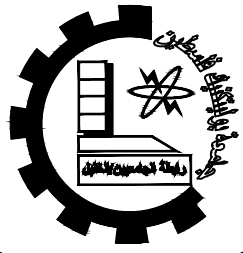

Palestine Polytechnic University

Department of Civil Engineering

College of Engineering

Civil Engineering

Design V

Project I

Eye-specialist Hospital

supervisors:

Dr. Nasr Abboushi  
Design by Roa' Al-jondi

Hamza.haddad  
Mohammad abu lawi

Drawing Symbol




 
S34


Drawing Title

BEAMS DETAILING  
GROUND & FIRST FLOOR

scale

1:50

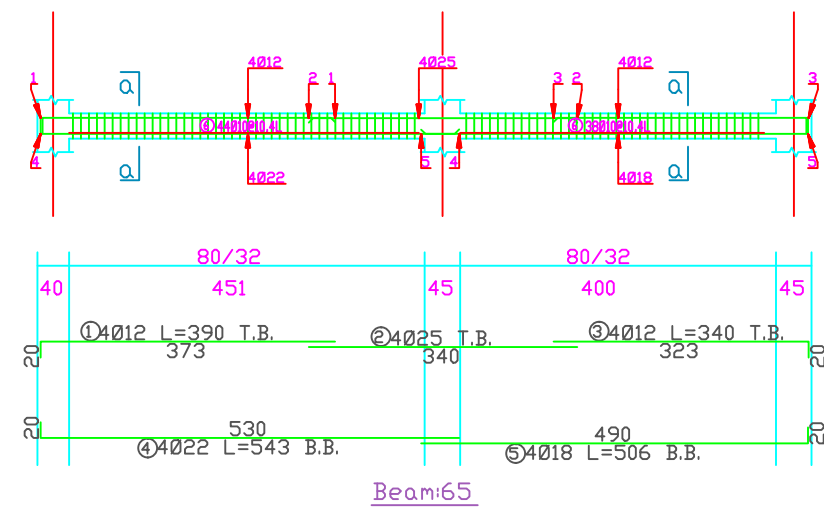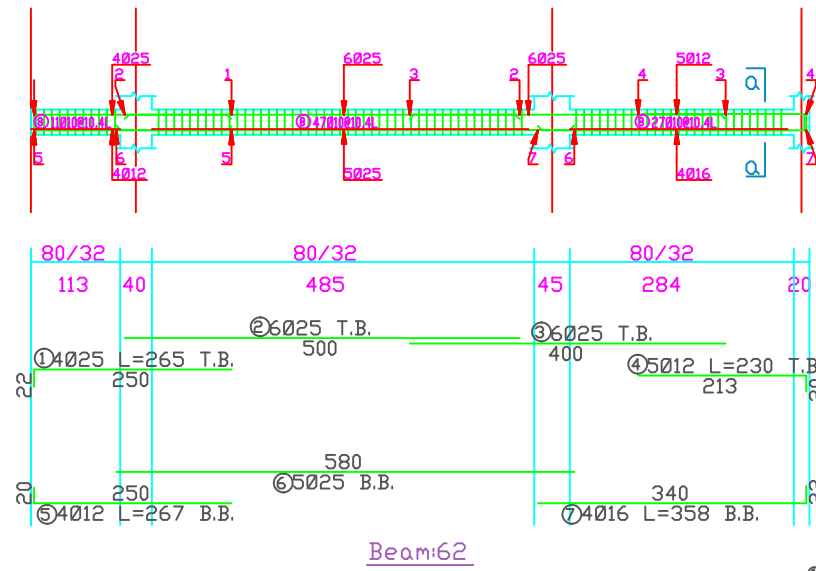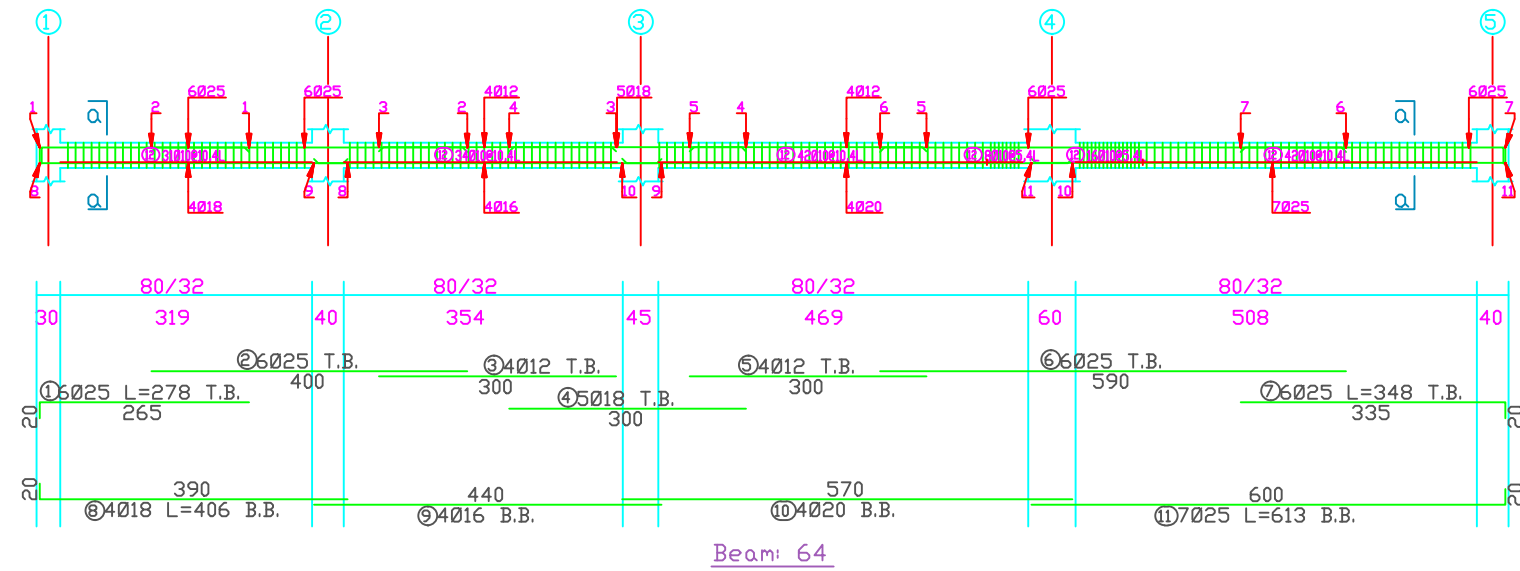

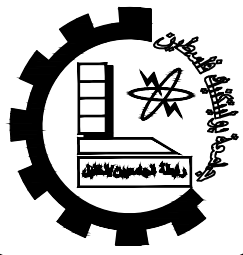

Palestine Polytechnic University

Department of Civil Engineering

College of Engineering

Civil Engineering

Design V

Project I

Eye-specialist Hospital

supervisors:

Dr. Nasr Abboushi  
Design by Roa' Al-jondi

Hamza.haddad  
Mohammad abu lawi

Drawing Symbol







 
S35

Drawing Tittle

BEAMS DETAILING  
GROUND & FIRST FLOOR


scale

1:50

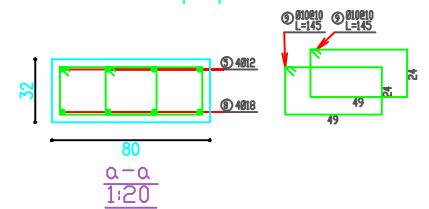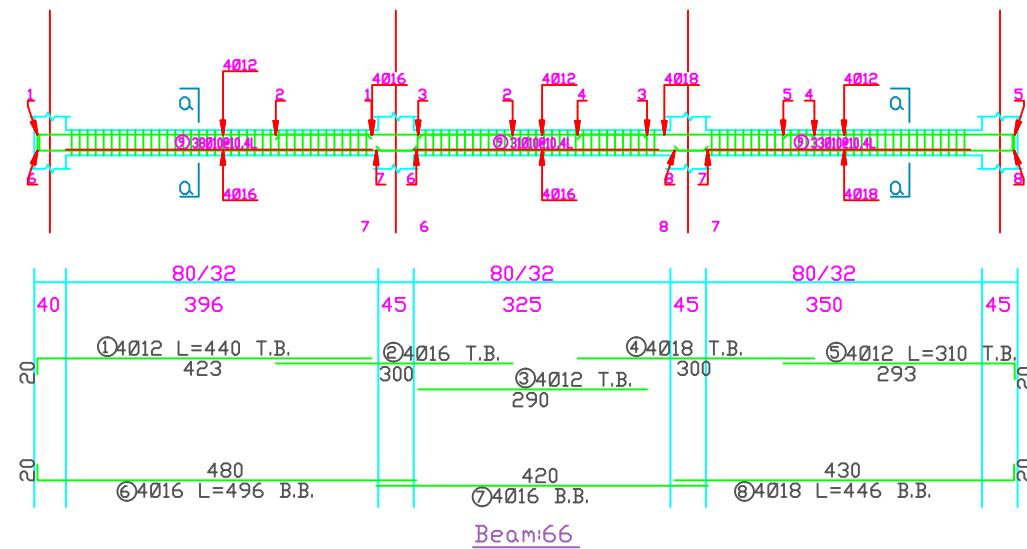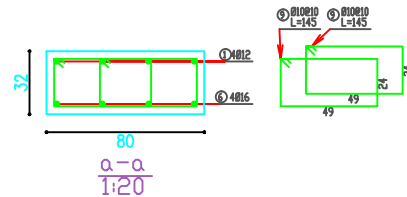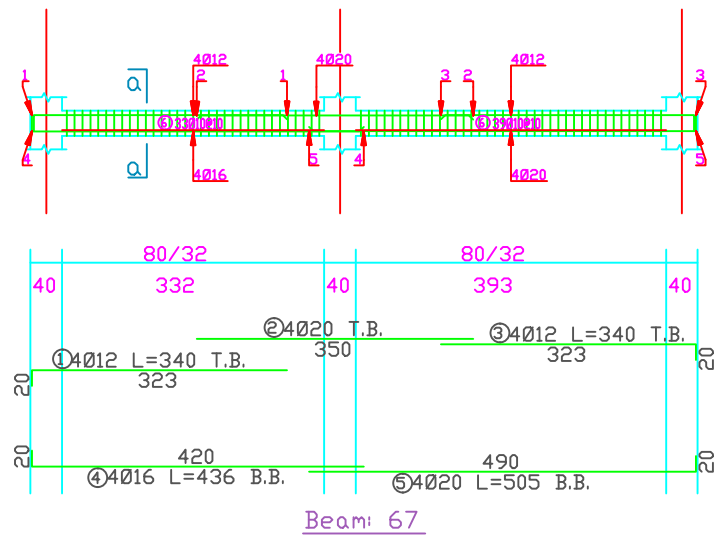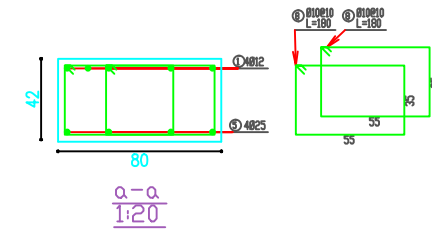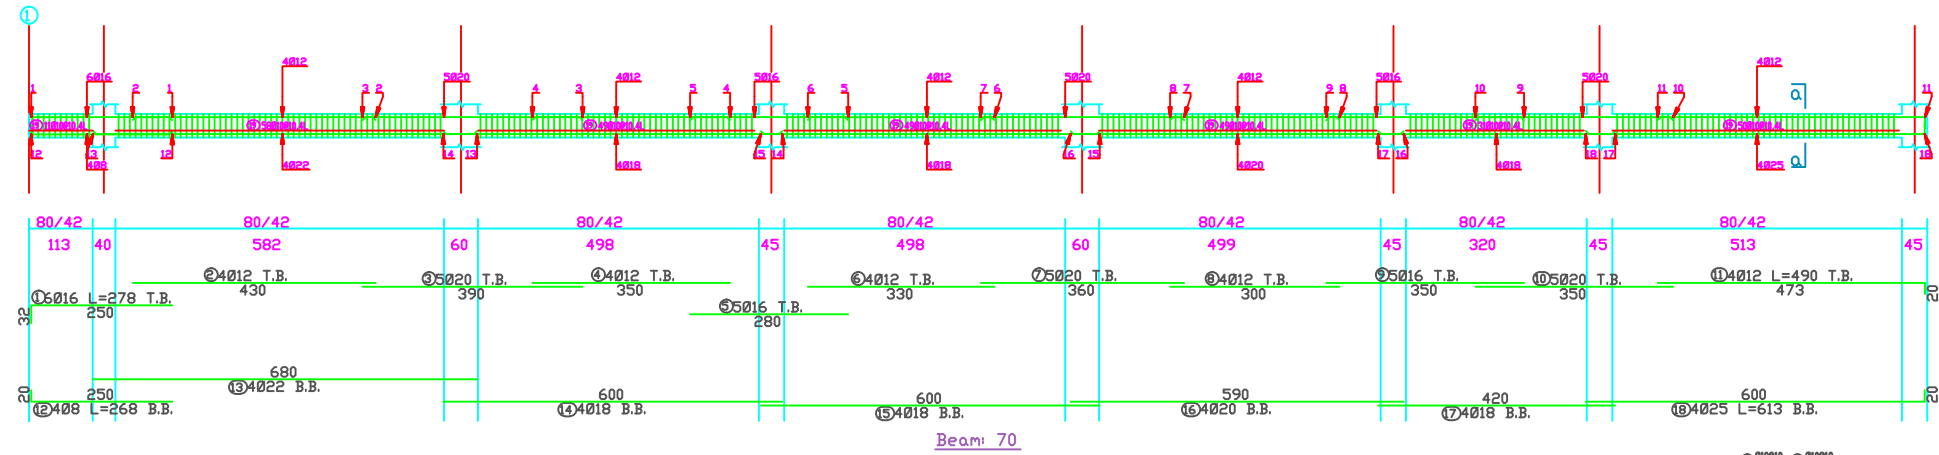





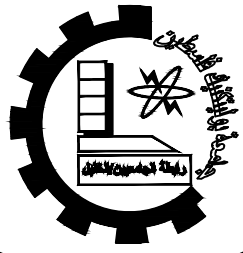

Palestine Polytechnic University

Department of Civil Engineering

College of Engineering

Civil Engineering

Design V

Project I

Eye-specialist Hospital

supervisors:

Dr. Nasr Abboushi  
Design by Roa' Al-jondi

Hamza.haddad  
Mohammad abu lawi

Drawing Symbol





 
S37

Drawing Tittle


BEAMS DETAILING  
GROUND & FIRST FLOOR

scale

1:50

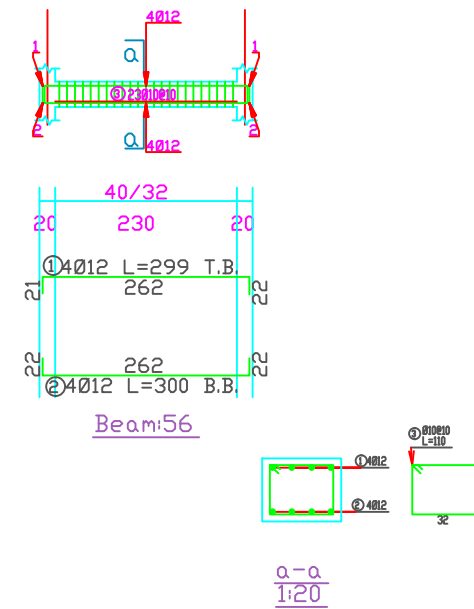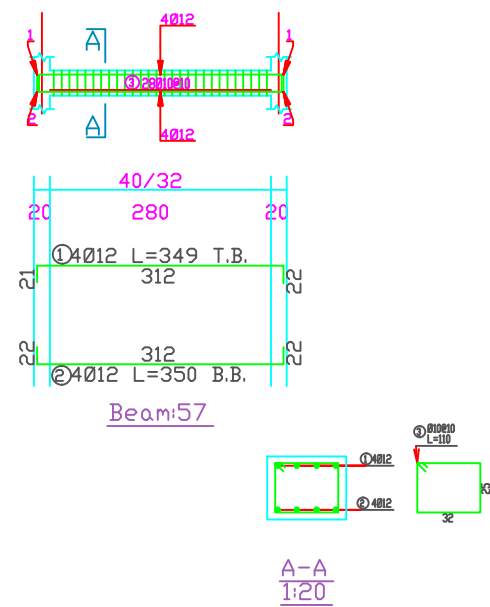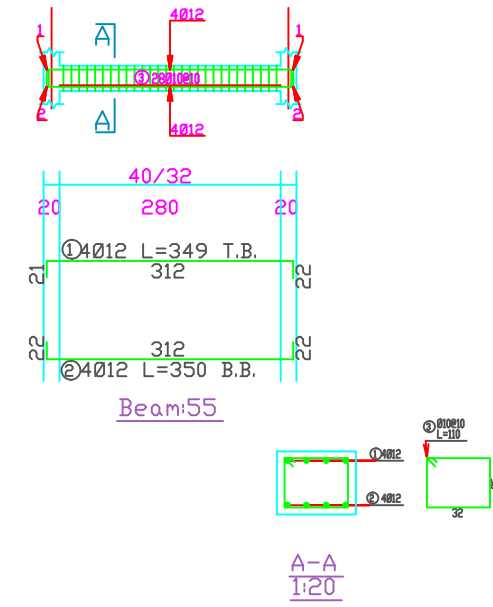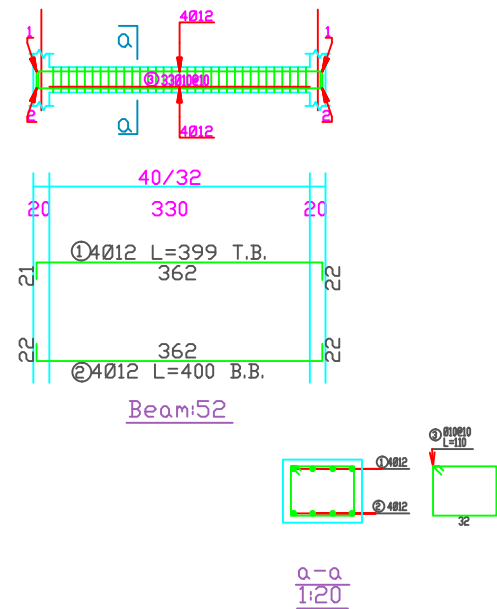



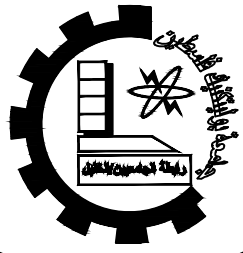

Palestine Polytechnic University

Department of Civil Engineering

College of Engineering

Civil Engineering

Design V

Project I

Eye-specialist Hospital

supervisors:

Dr. Nasr Abboushi  
Design by Roa' Al-jondi

Hamza.haddad  
Mohammad abu lawi

Drawing Symbol




 
S39


Drawing Tittle

BEAMS DETAILING  
SECOUND FLOOR

scale

1:50

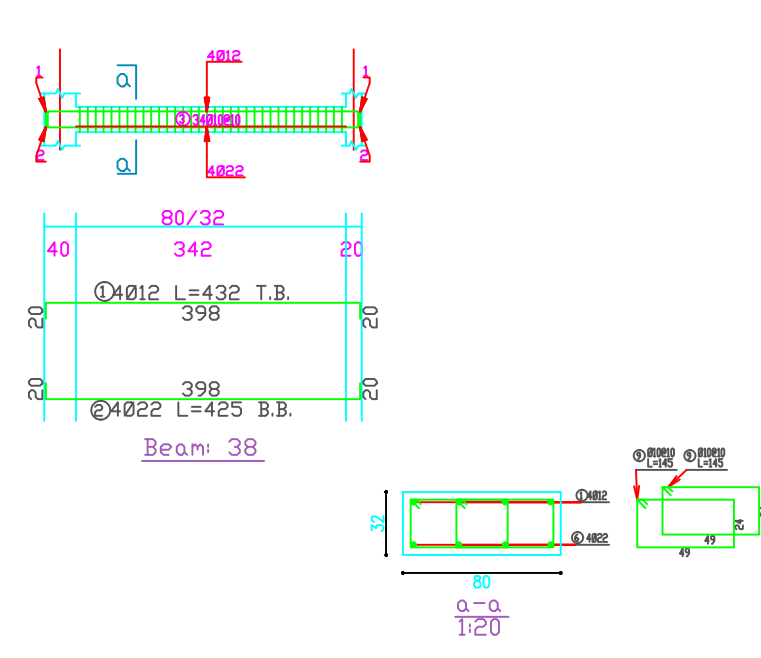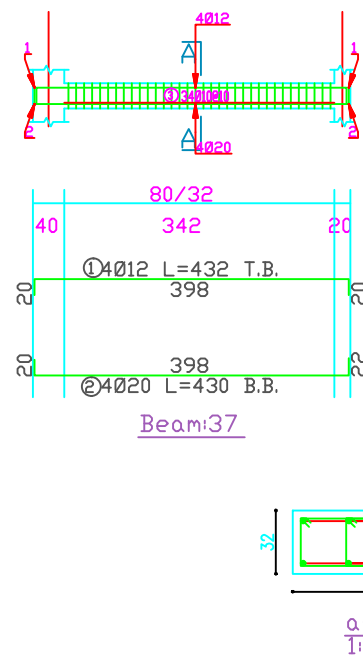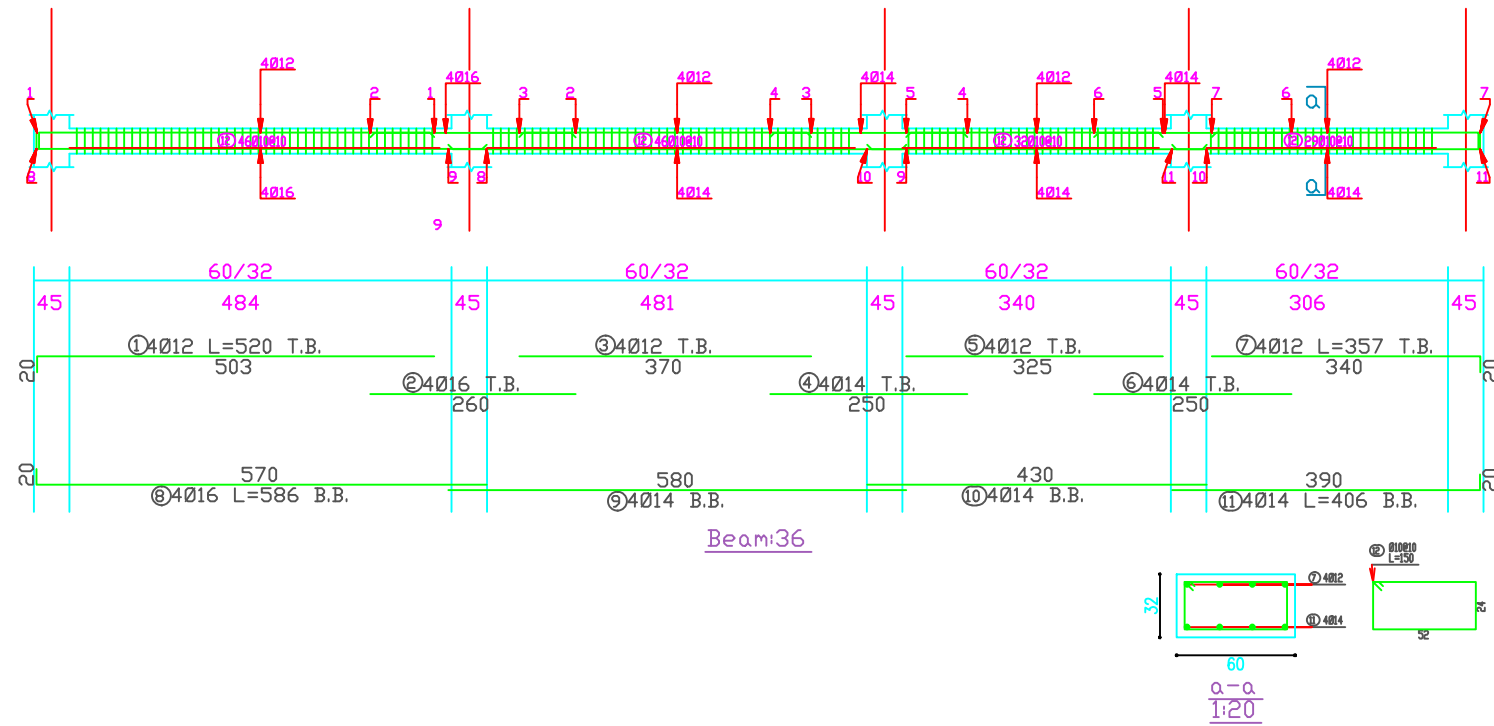

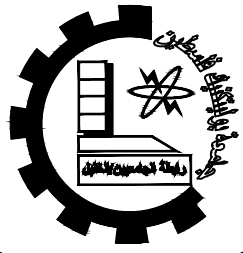

Palestine Polytechnic University

Department of Civil Engineering

College of Engineering

Civil Engineering

Design V

Project I

Eye-specialist Hospital

supervisors:

Dr. Nasr Abboushi  
Design by Roa' Al-jondi

Hamza.haddad  
Mohammad abu lawi

Drawing Symbol



 
S40


Drawing Tittle

BEAMS DETAILING  
SECOUND FLOOR

scale

1:50

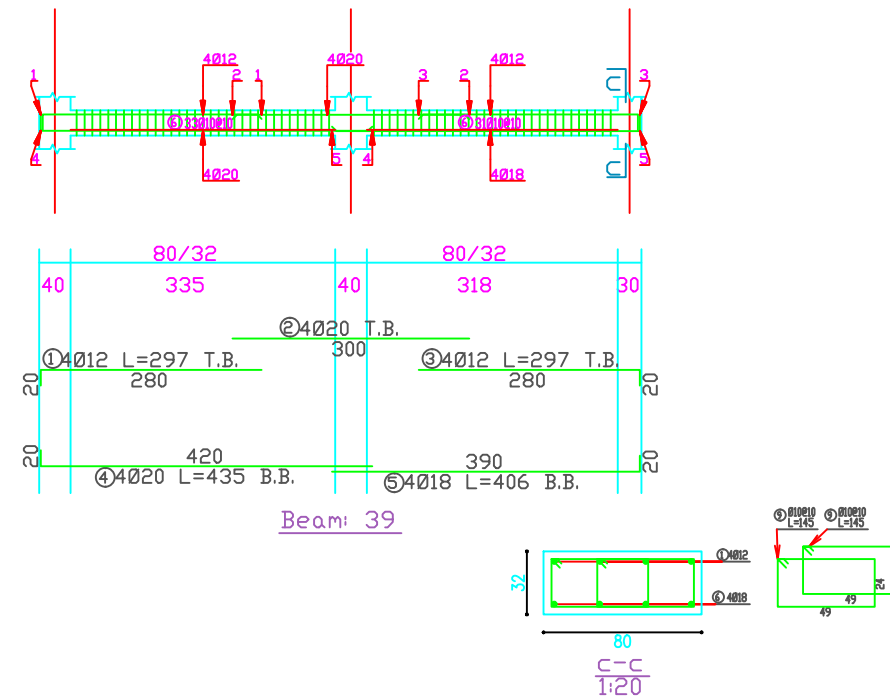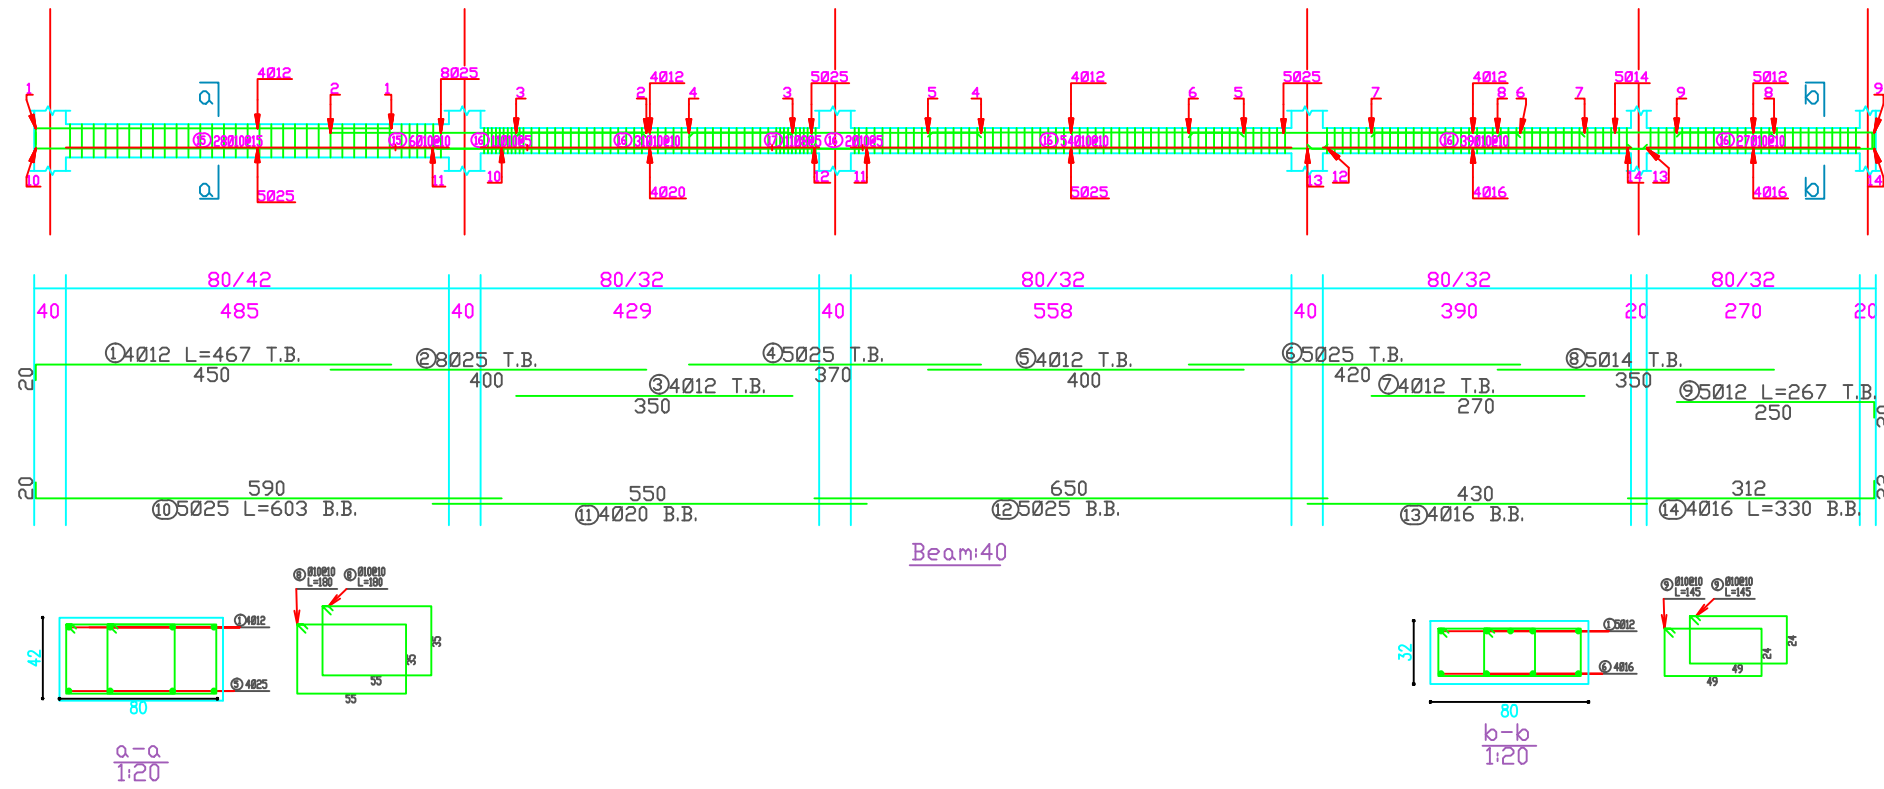

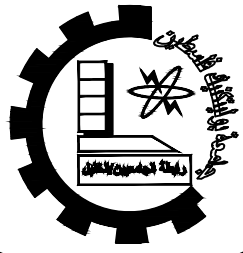

Palestine Polytechnic University

Department of Civil Engineering

College of Engineering

Civil Engineering

Design V

Project I

Eye-specialist Hospital

supervisors:

Dr. Nasr Abboushi  
Design by Roa' Al-jondi

Hamza.haddad  
Mohammad abu lawi

Drawing Symbol




 
S41


Drawing Tittle

BEAMS DETAILING  
SECOND FLOOR

scale

1:50

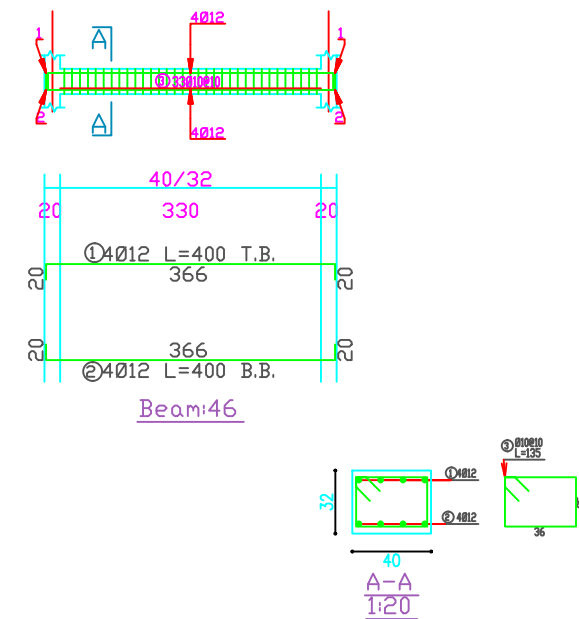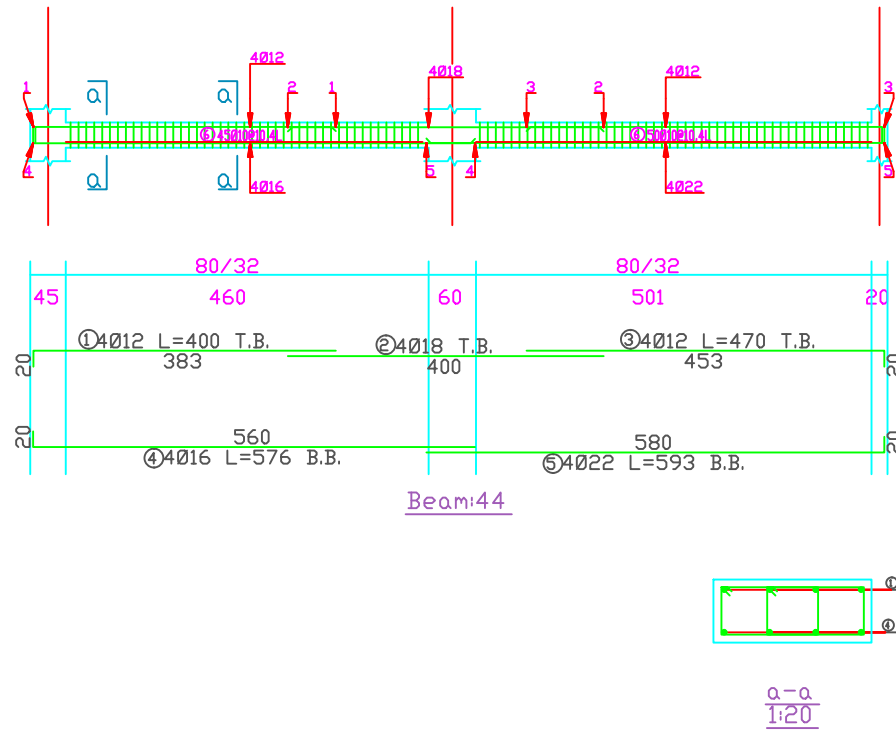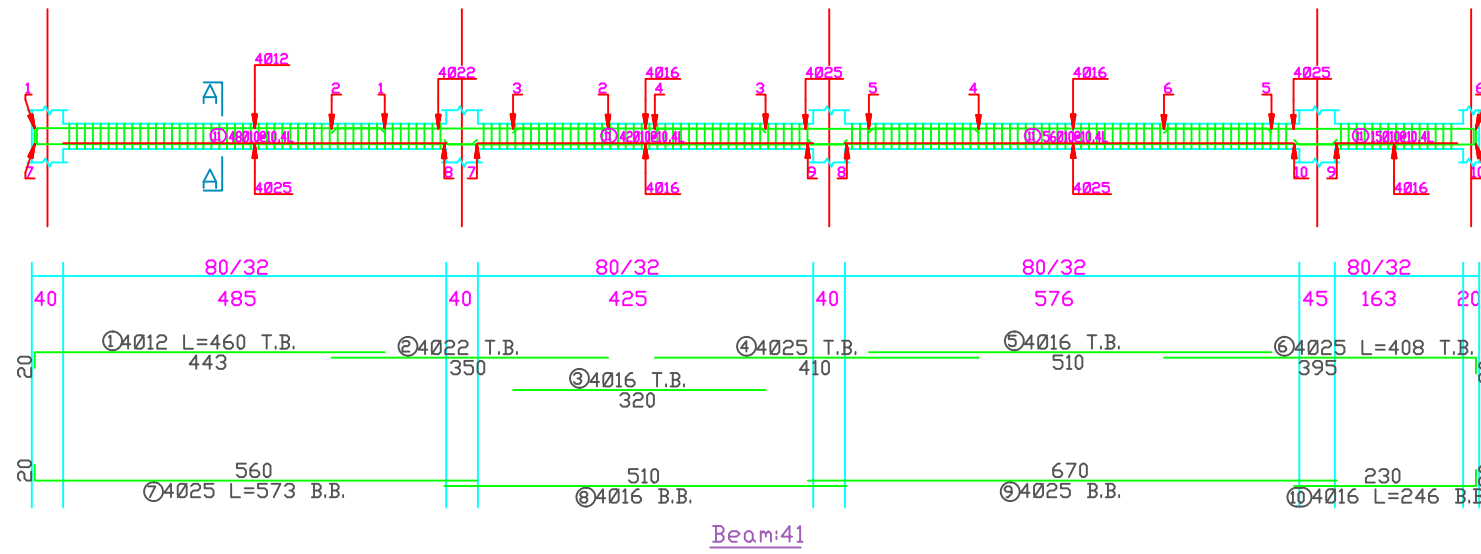

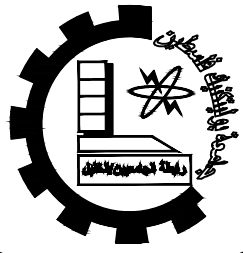

Palestine Polytechnic University

Department of Civil Engineering

College of Engineering

Civil Engineering

Design V

Project I

Eye-specialist Hospital

supervisors:

Dr. Nasr Abboushi  
Design by Roa' Al-jondi

Hamza.haddad  
Mohammad abu lawi

Drawing Symbol


 
S42

Drawing Tittle




BEAMS DETAILING  
SECOND FLOOR

scale



1:50

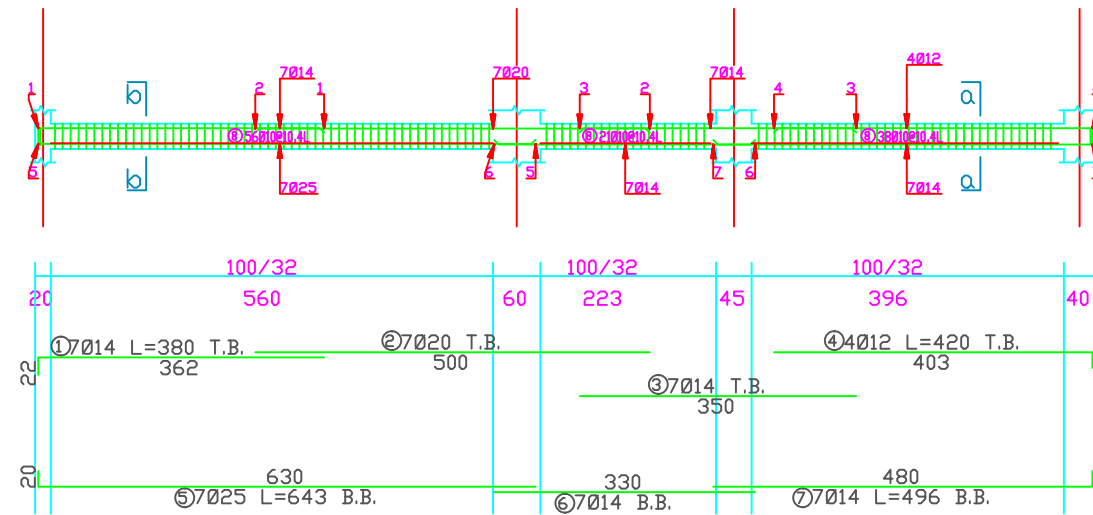


Beam: 53

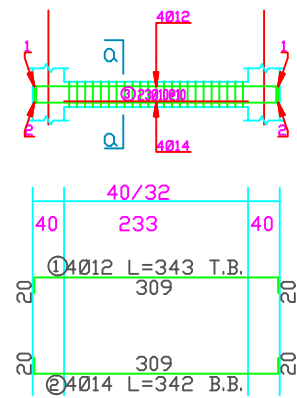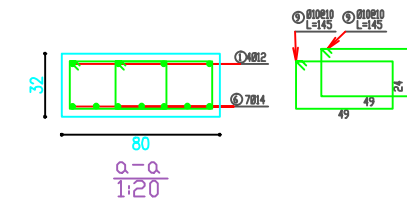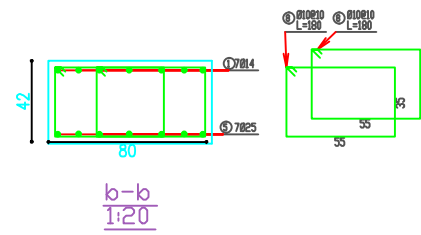


Beam: 51

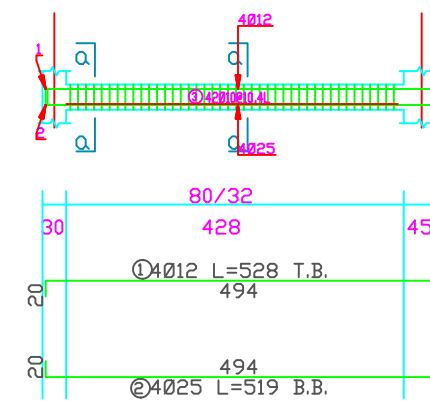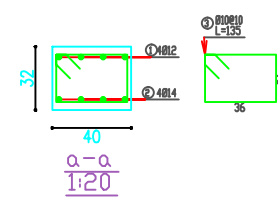

Beam: 50

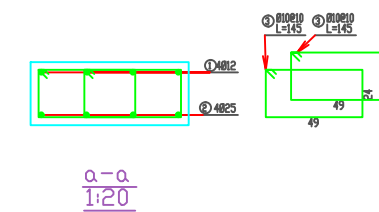



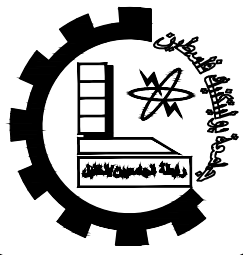

Palestine Polytechnic University

Department of Civil Engineering

College of Engineering

Civil Engineering

Design V

Project I

Eye-specialist Hospital

supervisors:

Dr. Nasr Abboushi  
Design by Roa' Al-jondi

Hamza.haddad  
Mohammad abu lawi

Drawing Symbol




 
S43


Drawing Tittle

BEAMS DETAILING  
SECOND FLOOR

scale

1:50

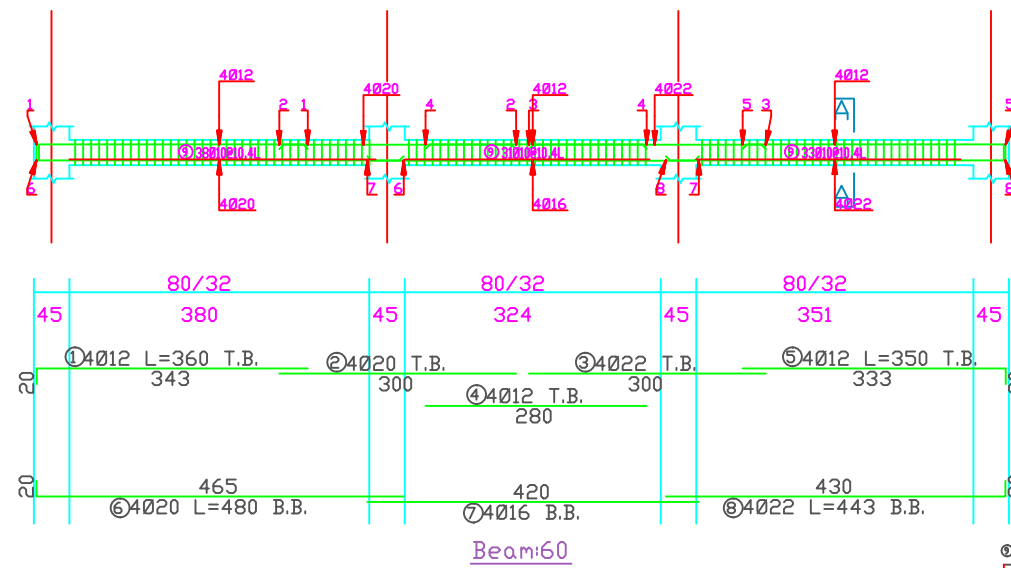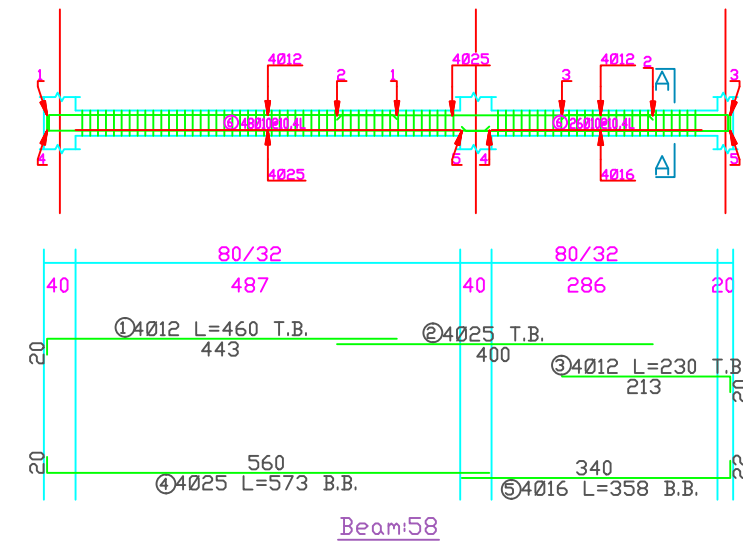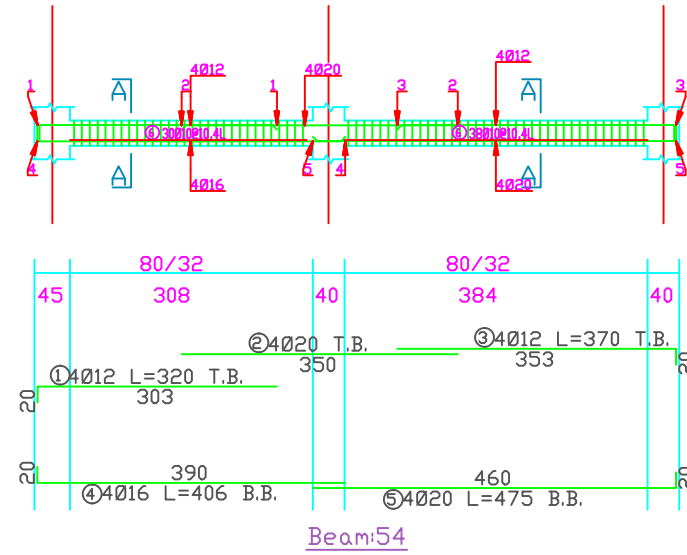

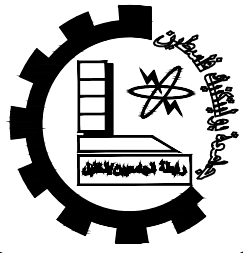

Palestine Polytechnic University

Department of Civil Engineering

College of Engineering

Civil Engineering

Design V

Project I

Eye-specialist Hospital

supervisors:

Dr. Nasr Abboushi  
Design by Roa' Al-jondi

Hamza.haddad  
Mohammad abu lawi

Drawing Symbol




 
S44


Drawing Tittle

BEAMS DETAILING  
SECOUND FLOOR

scale

1:50

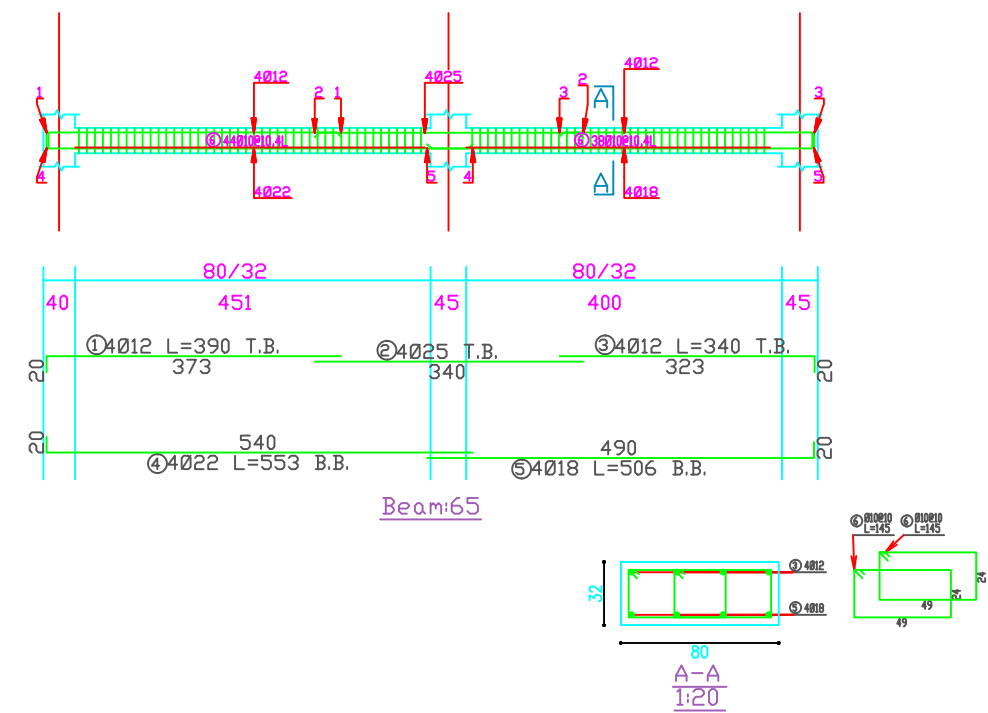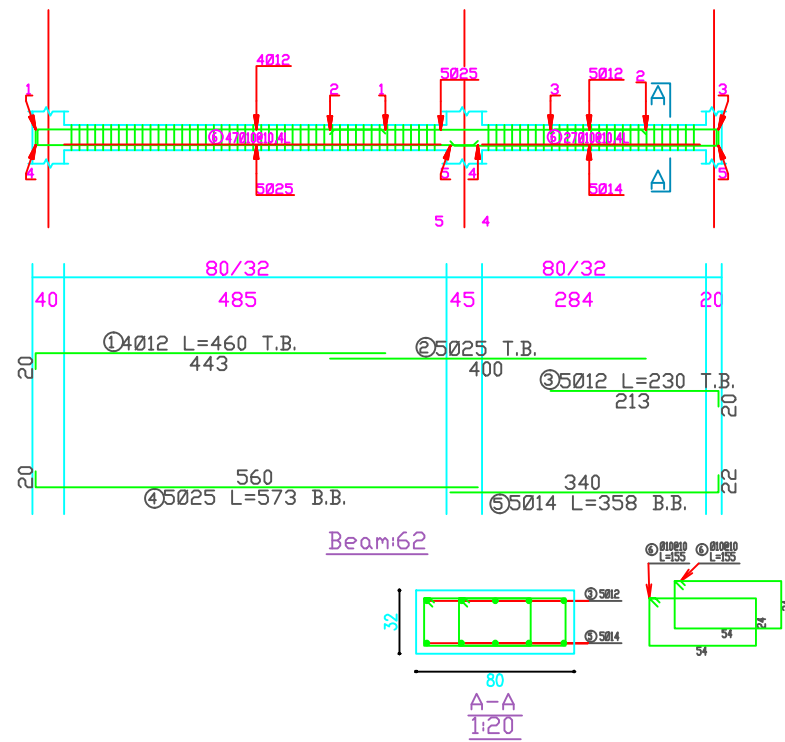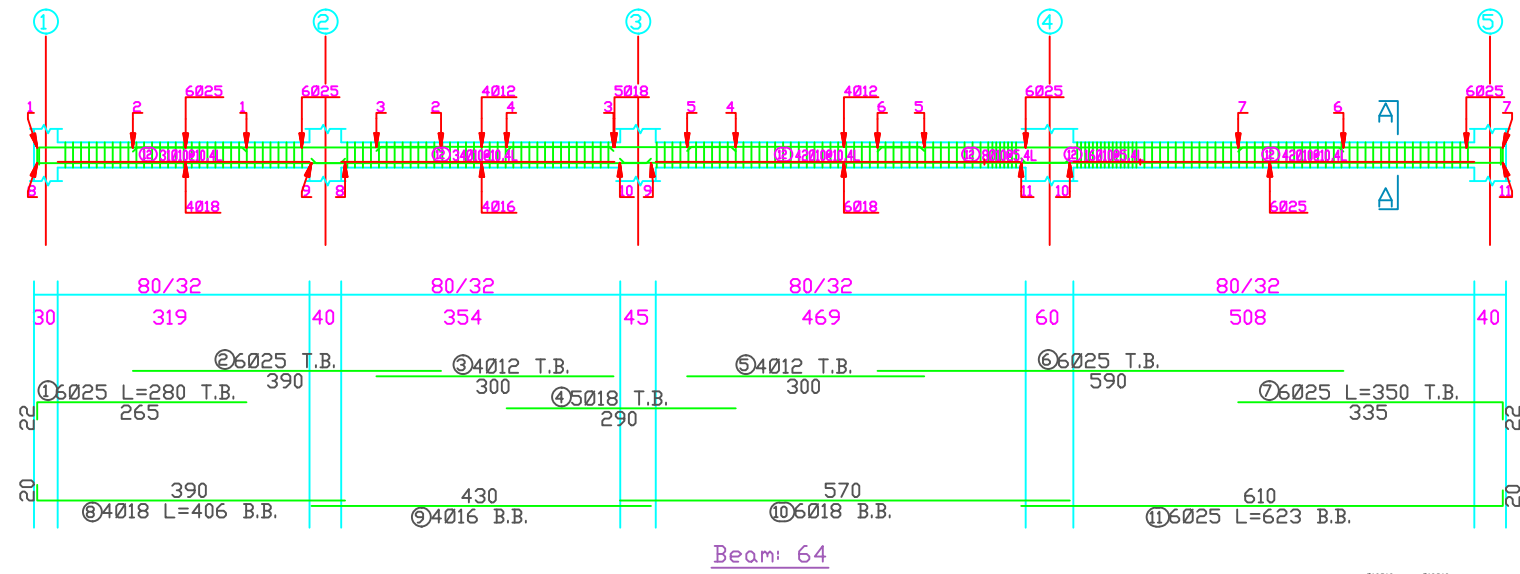

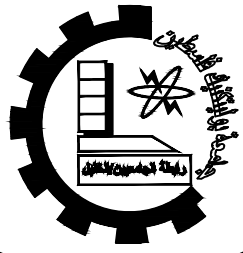

Palestine Polytechnic University

Department of Civil Engineering

College of Engineering

Civil Engineering

Design V

Project I

Eye-specialist Hospital

supervisors:

Dr. Nasr Abboushi  
Design by Roa' Al-jondi

Hamza.haddad  
Mohammad abu lawi

Drawing Symbol





 
S45


Drawing Tittle

BEAMS DETAILING  
SECOUND FLOOR

scale

1:50

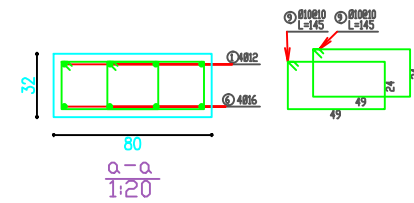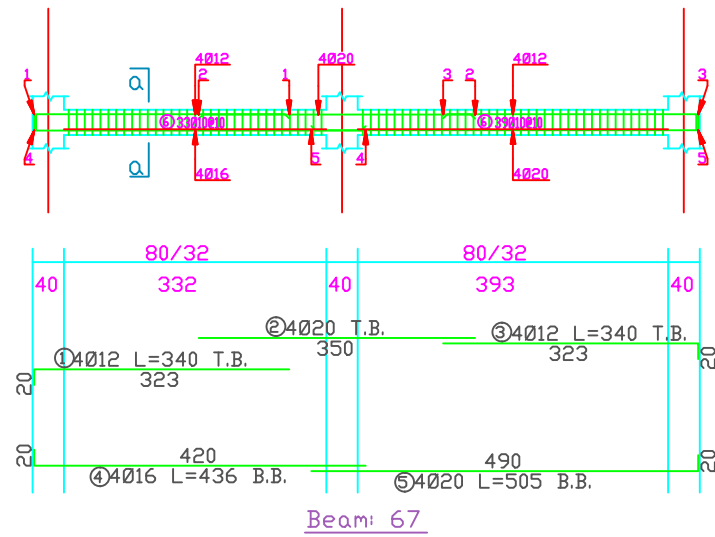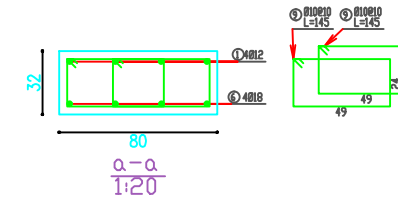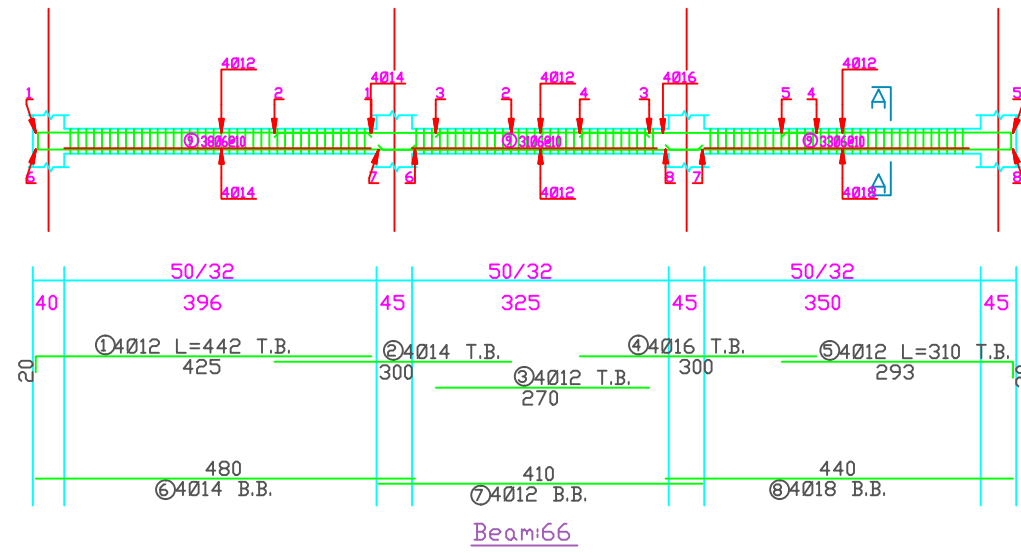

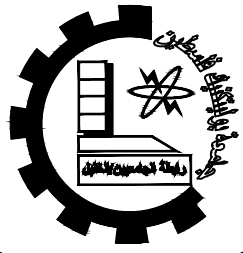

Palestine Polytechnic University

Department of Civil Engineering

College of Engineering

Civil Engineering

Design V

Project I

Eye-specialist Hospital

supervisors:

Dr. Nasr Abboushi  
Design by Roa' Al-jondi

Hamza.haddad  
Mohammad abu lawi

Drawing Symbol





 
S46


Drawing Tittle

BEAMS DETAILING  
SECOUND FLOOR

scale

1:50

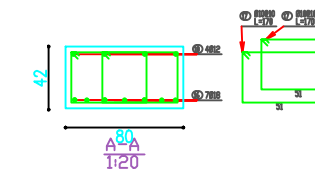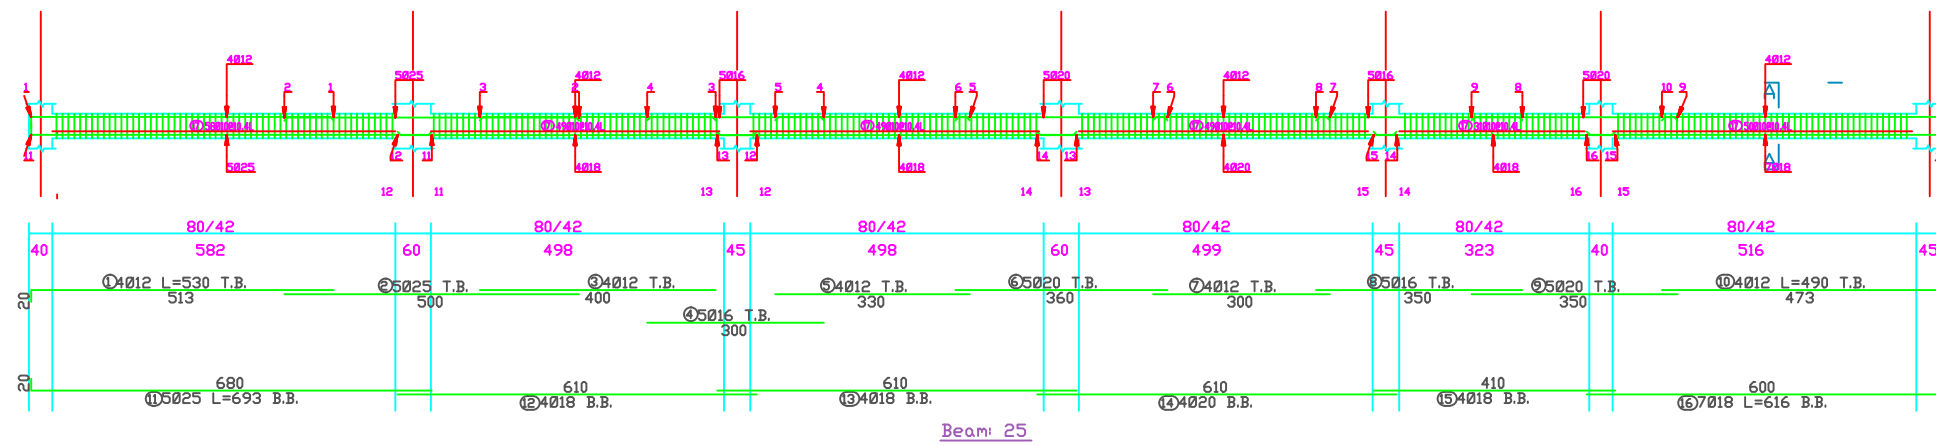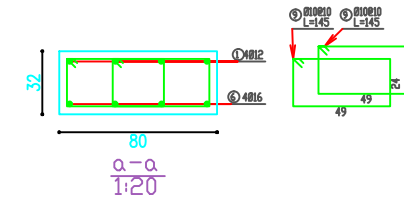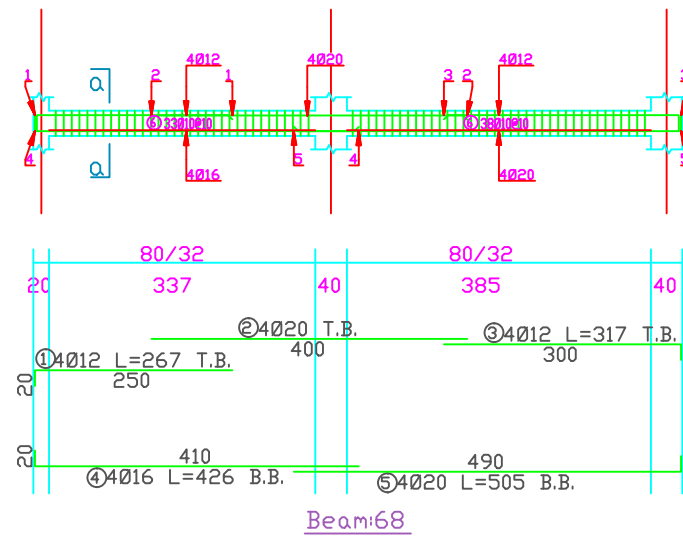

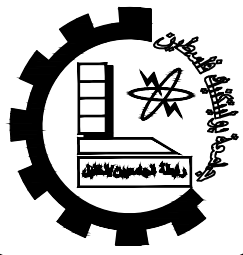

Palestine Polytechnic University

Department of Civil Engineering

College of Engineering

Civil Engineering

Design V

Project I

Eye-specialist Hospital

supervisors:

Dr. Nasr Abboushi  
Design by Roa' Al-jondi

Hamza.haddad  
Mohammad abu lawi

Drawing Symbol


 
S47

Drawing Tittle



BEAMS DETAILING  
SECOUND FLOOR

scale



1:50

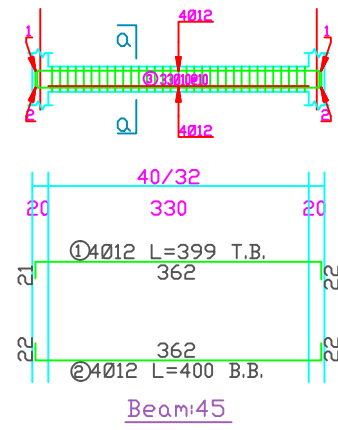



Beam:45

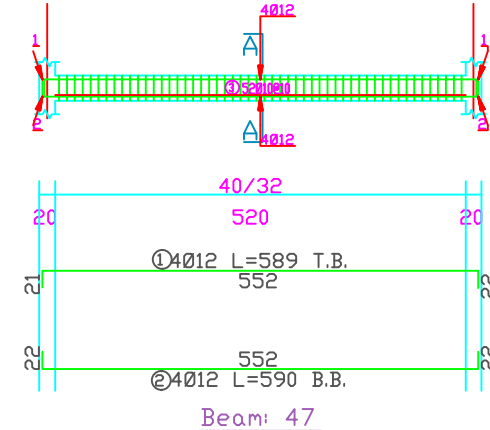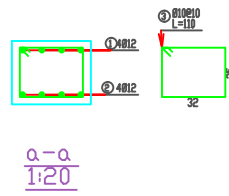



Beam: 47

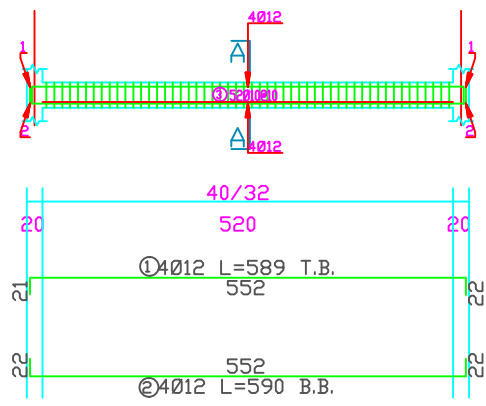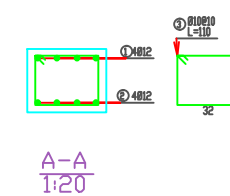


Beam: 48

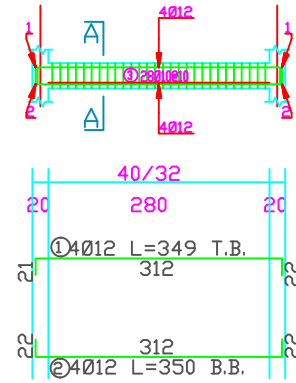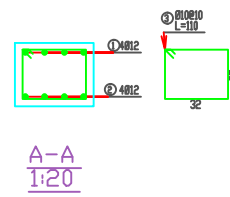


Beam:49

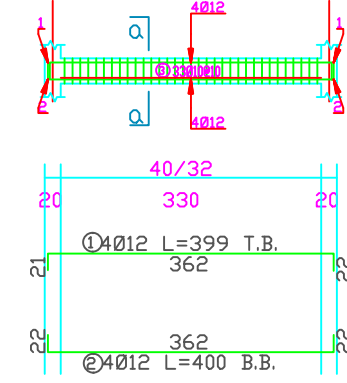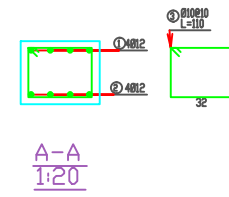

Beam:52

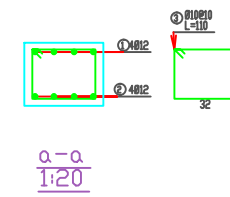

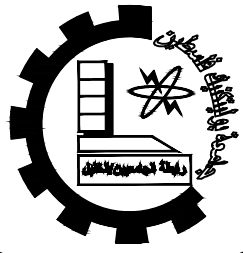

Palestine Polytechnic University

Department of Civil Engineering

College of Engineering

Civil Engineering

Design V

Project I

Eye-specialist Hospital

supervisors:

Dr. Nasr Abboushi  
Design by Roa' Al-jondi

Hamza.haddad  
Mohammad abu lawi

Drawing Symbol







 
S48

Drawing Tittle


BEAMS DETAILING  
SECOND FLOOR

scale

1:50

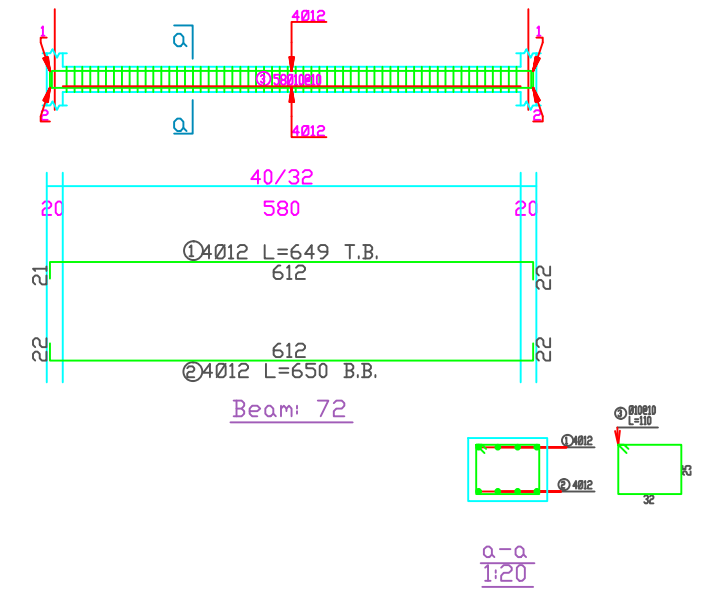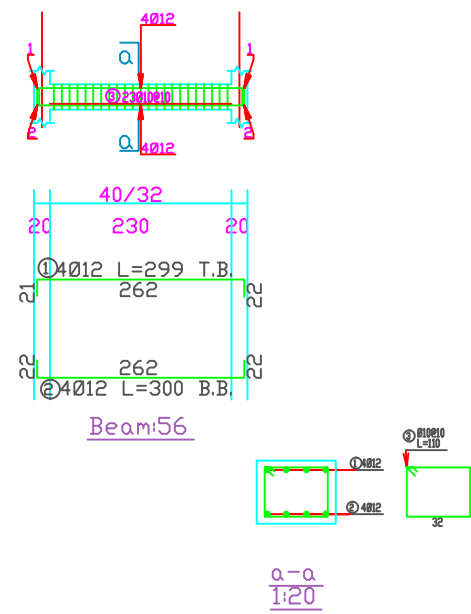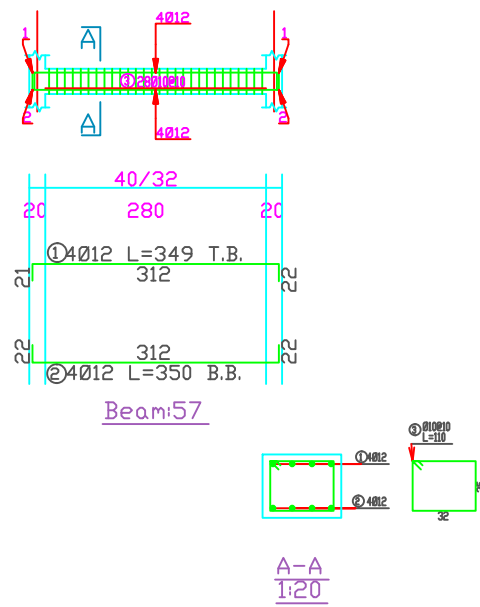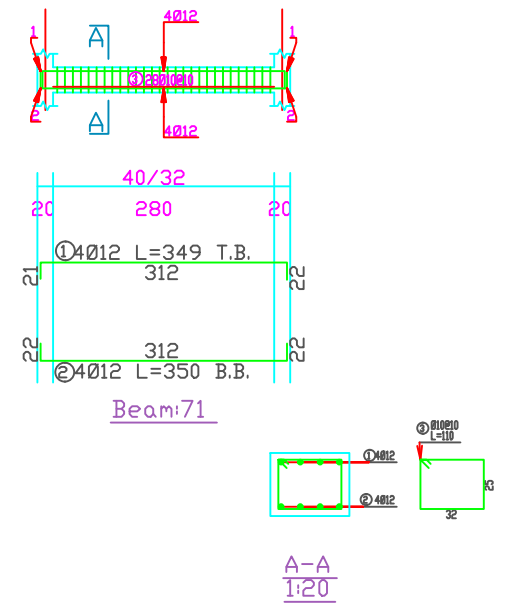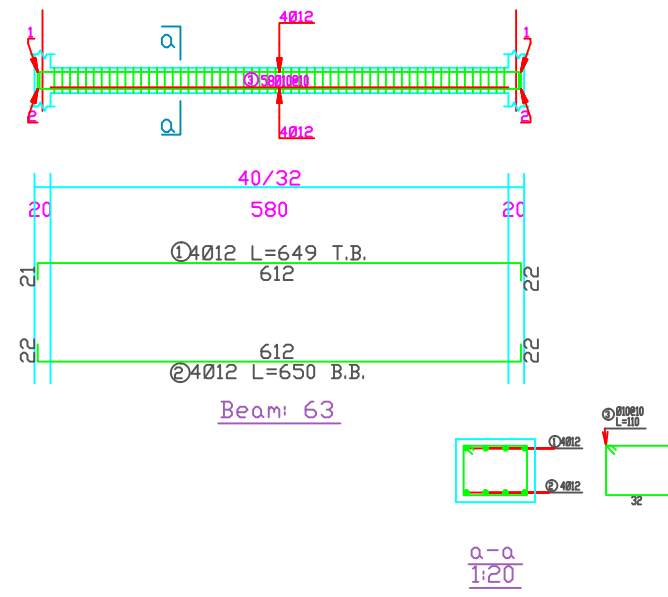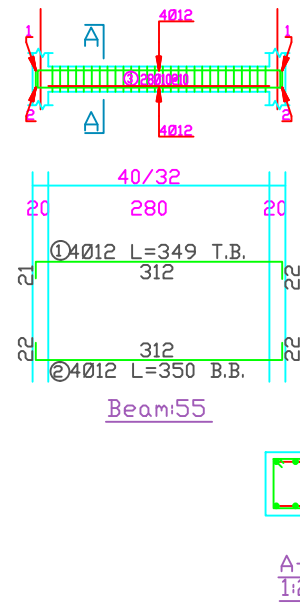



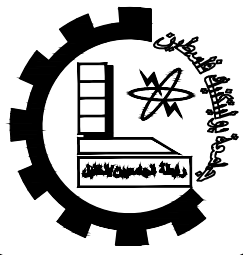

Palestine Polytechnic University

Department of Civil Engineering

College of Engineering

Civil Engineering

Design V

Project I

Eye-specialist Hospital

supervisors:

Dr. Nasr Abboushi  
Design by Roa' Al-jondi

Hamza.haddad  
Mohammad abu lawi

Drawing Symbol

 
S49

Drawing Tittle


SHEAR WALL KEY PLAN


scale

1:100



Shear Wall Key Plan

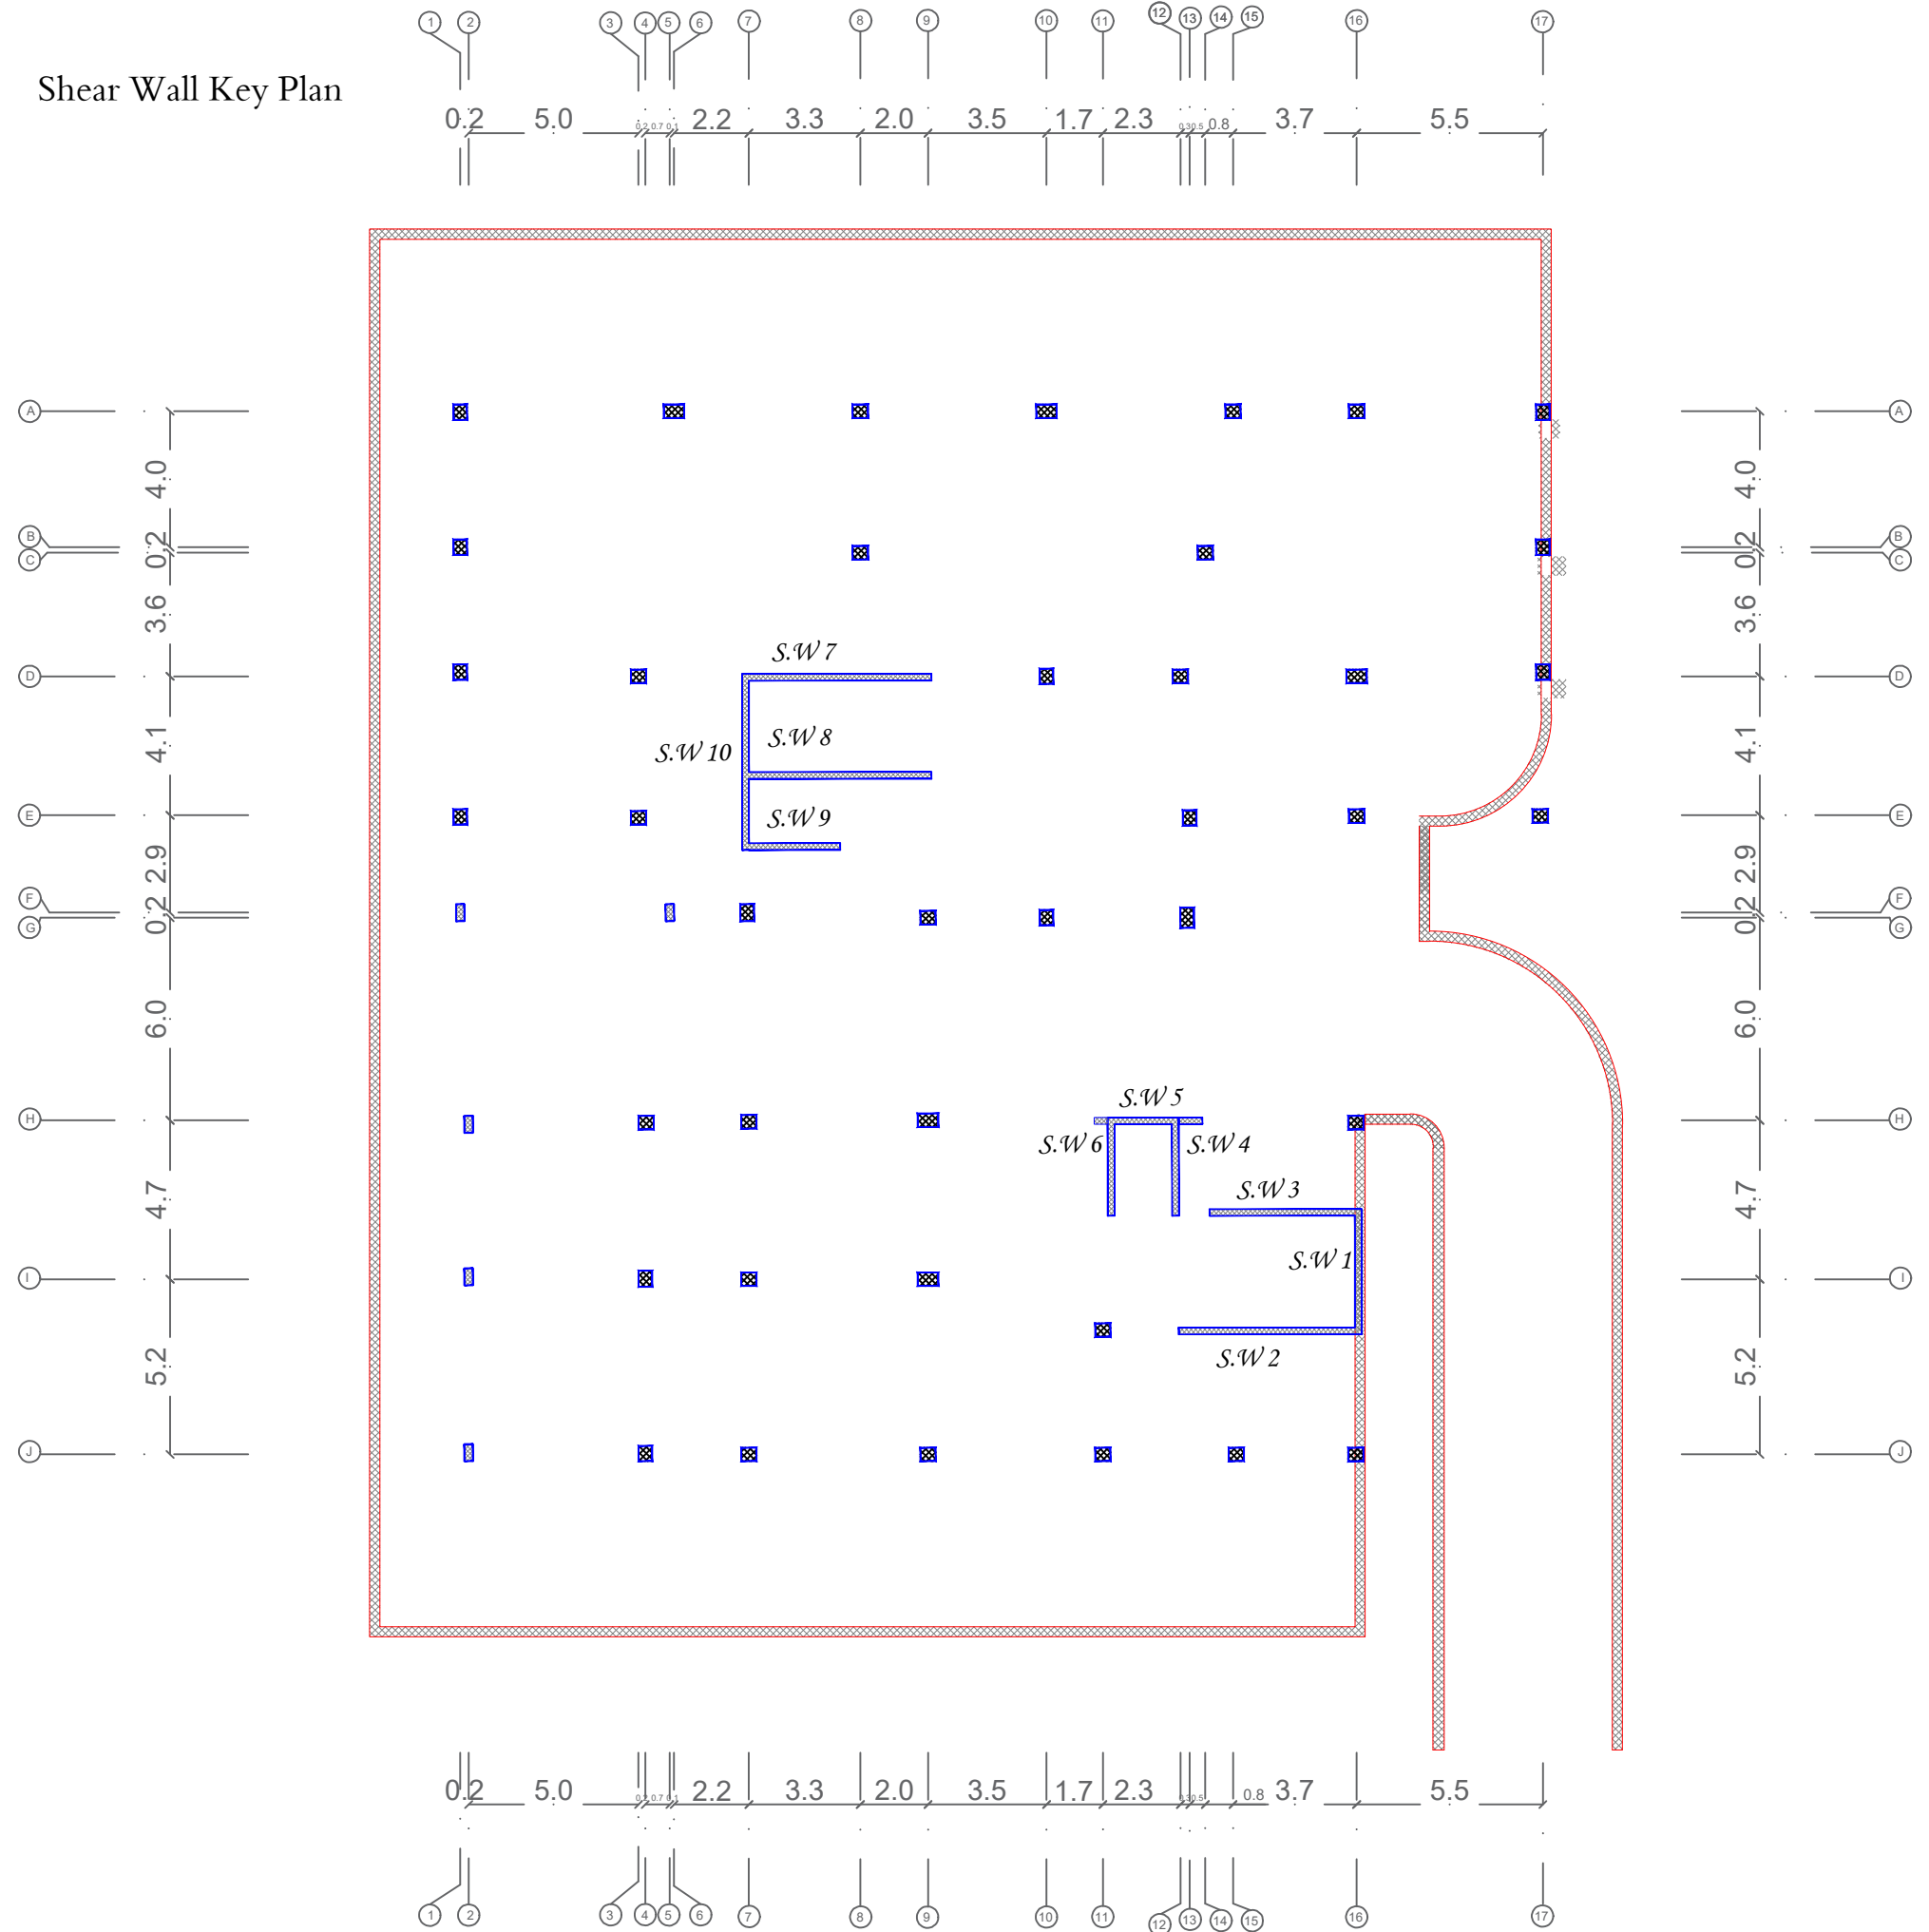

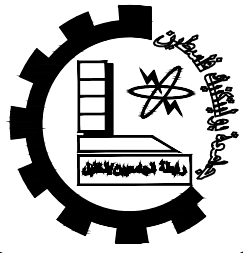

Palestine Polytechnic University

Department of Civil Engineering

College of Engineering

Civil Engineering

Design V

Project I

Eye-specialist Hospital

supervisors:

Dr. Nasr Abboushi  
Design by Roa' Al-jondi

Hamza.haddad  
Mohammad abu lawi

Drawing Symbol

 
S50

Drawing Tittle


SHEAR WALL

scale


1:100




## Shear walls ( 1 & 2 &3)

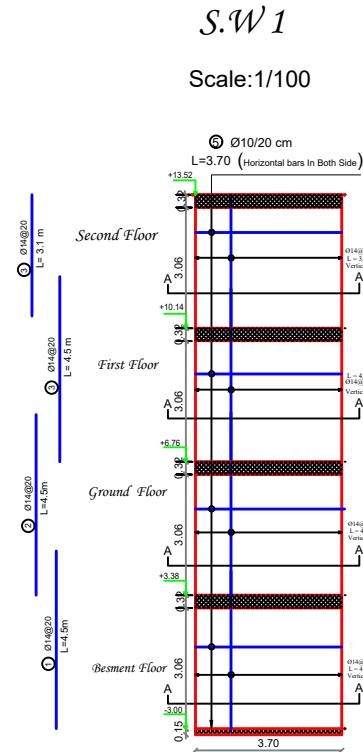


*section(A-A)*  
Scale:1/50

 


Scale:1/25

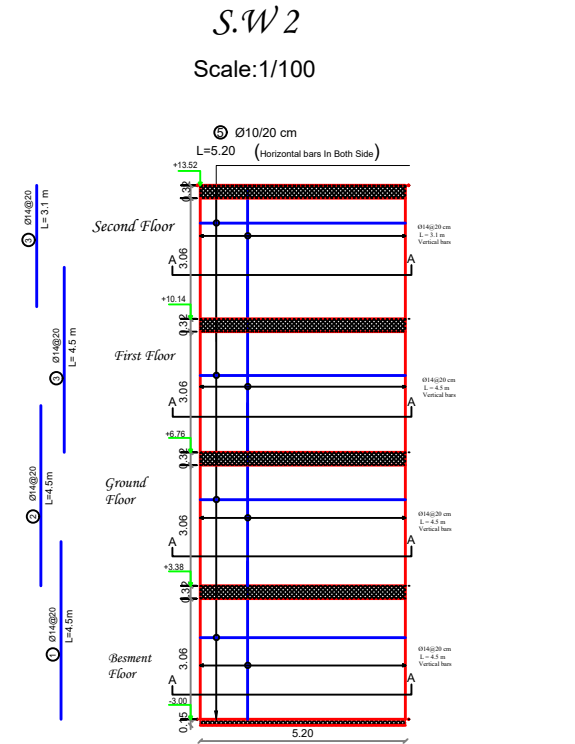


*section(A-A)*  
Scale:1/50

 


Scale:1/25

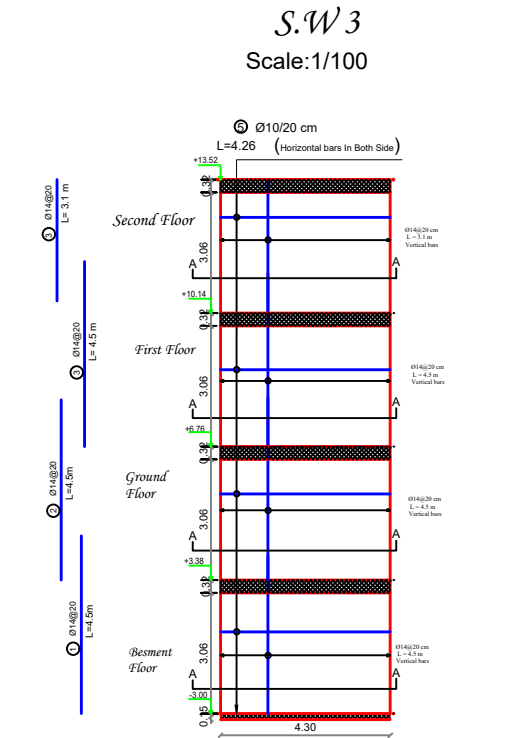

*section(A-A)*  
Scale:1/50

 

Scale:1/25

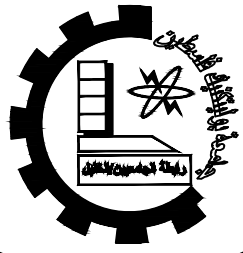

Palestine Polytechnic University

Department of Civil Engineering

College of Engineering

Civil Engineering

Design V

Project I

Eye-specialist Hospital

supervisors:

Dr. Nasr Abboushi  
Design by Roa' Al-jondi

Hamza.haddad  
Mohammad abu lawi

Drawing Symbol

 
S51

Drawing Tittle

SHEAR WALL

scale


1:100



# Shear walls ( 4 & 5 &6)


S.W 4

Scale:1/100

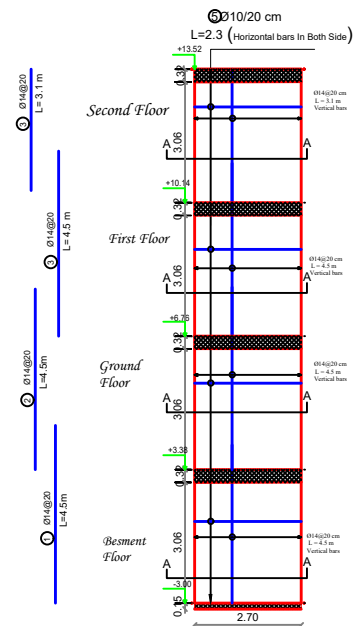

section(A-A)

 Scale:1/50




Scale:1/25

Scale:1/25


S.W 5

Scale:1/100

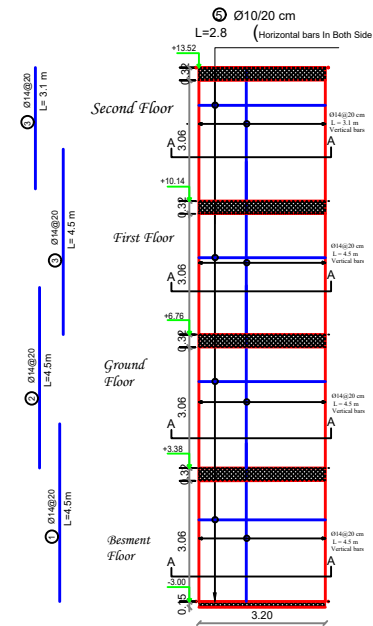

section(A-A)

 Scale:1/50




Scale:1/25

Scale:1/25


S.W 6

Scale:1/100

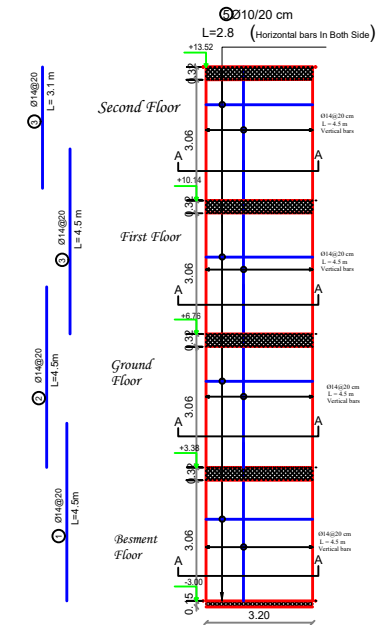


section(A-A)

 Scale:1/50



Scale:1/25

Scale:1/25

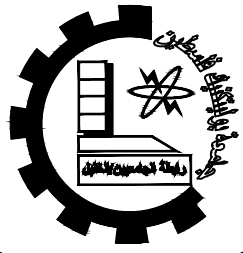

Palestine Polytechnic University

Department of Civil Engineering

College of Engineering

Civil Engineering

Design V

Project I

Eye-specialist Hospital

supervisors:

Dr. Nasr Abboushi  
Design by Roa' Al-jondi

Hamza.haddad  
Mohammad abu lawi

Drawing Symbol

 
S52

Drawing Tittle

SHEAR WALL


scale

1:100




# Shear walls ( 7 & 8 )

S.W 7  
Scale:1/100

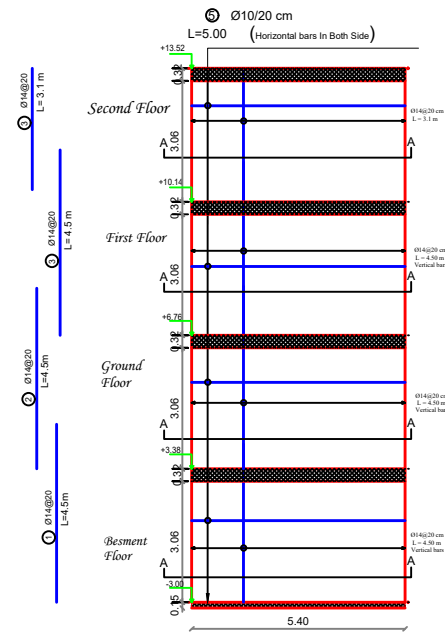


section(A-A)  
Scale:1/50

 


Scale:1/25


S.W 8  
Scale:1/100

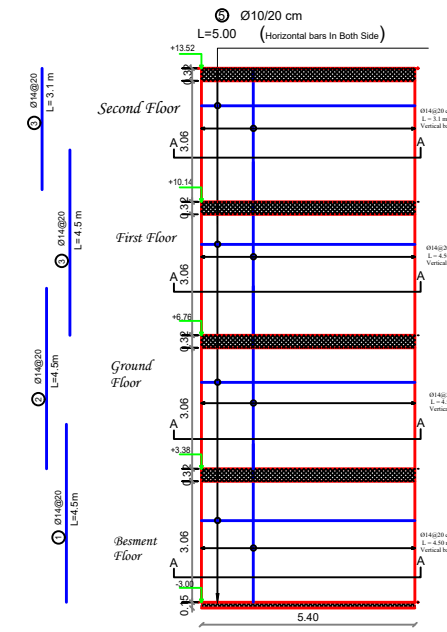

section(A-A)  
Scale:1/50

 

Scale:1/25

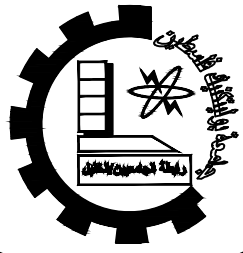

Palestine Polytechnic University

Department of Civil Engineering

College of Engineering

Civil Engineering

Design V

Project I

Eye-specialist Hospital

supervisors:

Dr. Nasr Abboushi  
Design by Roa' Al-jondi

Hamza.haddad  
Mohammad abu lawi

Drawing Symbol

 
S53

Drawing Tittle

SHEAR WALL


scale

1:100




## Shear walls ( 9 & 10 )

S.W 9  
Scale:1/100

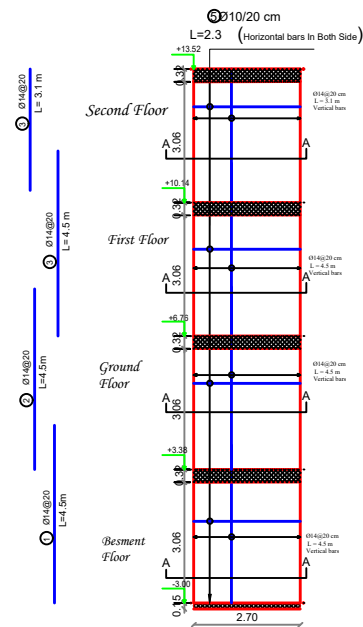


section(A-A)  
Scale:1/50

 


Scale:1/25

S.W 10  
Scale:1/100

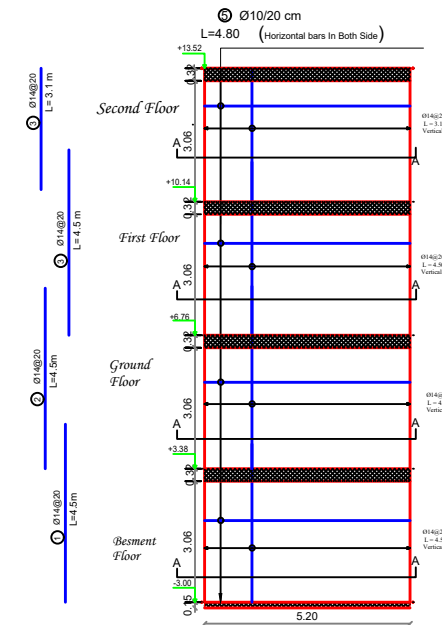

section(A-A)  
Scale:1/50

 

Scale:1/25



